


Le Velo

Le Velo Cafe
148/46 Baywater Drive
Wentworth Point
NSW, 2127

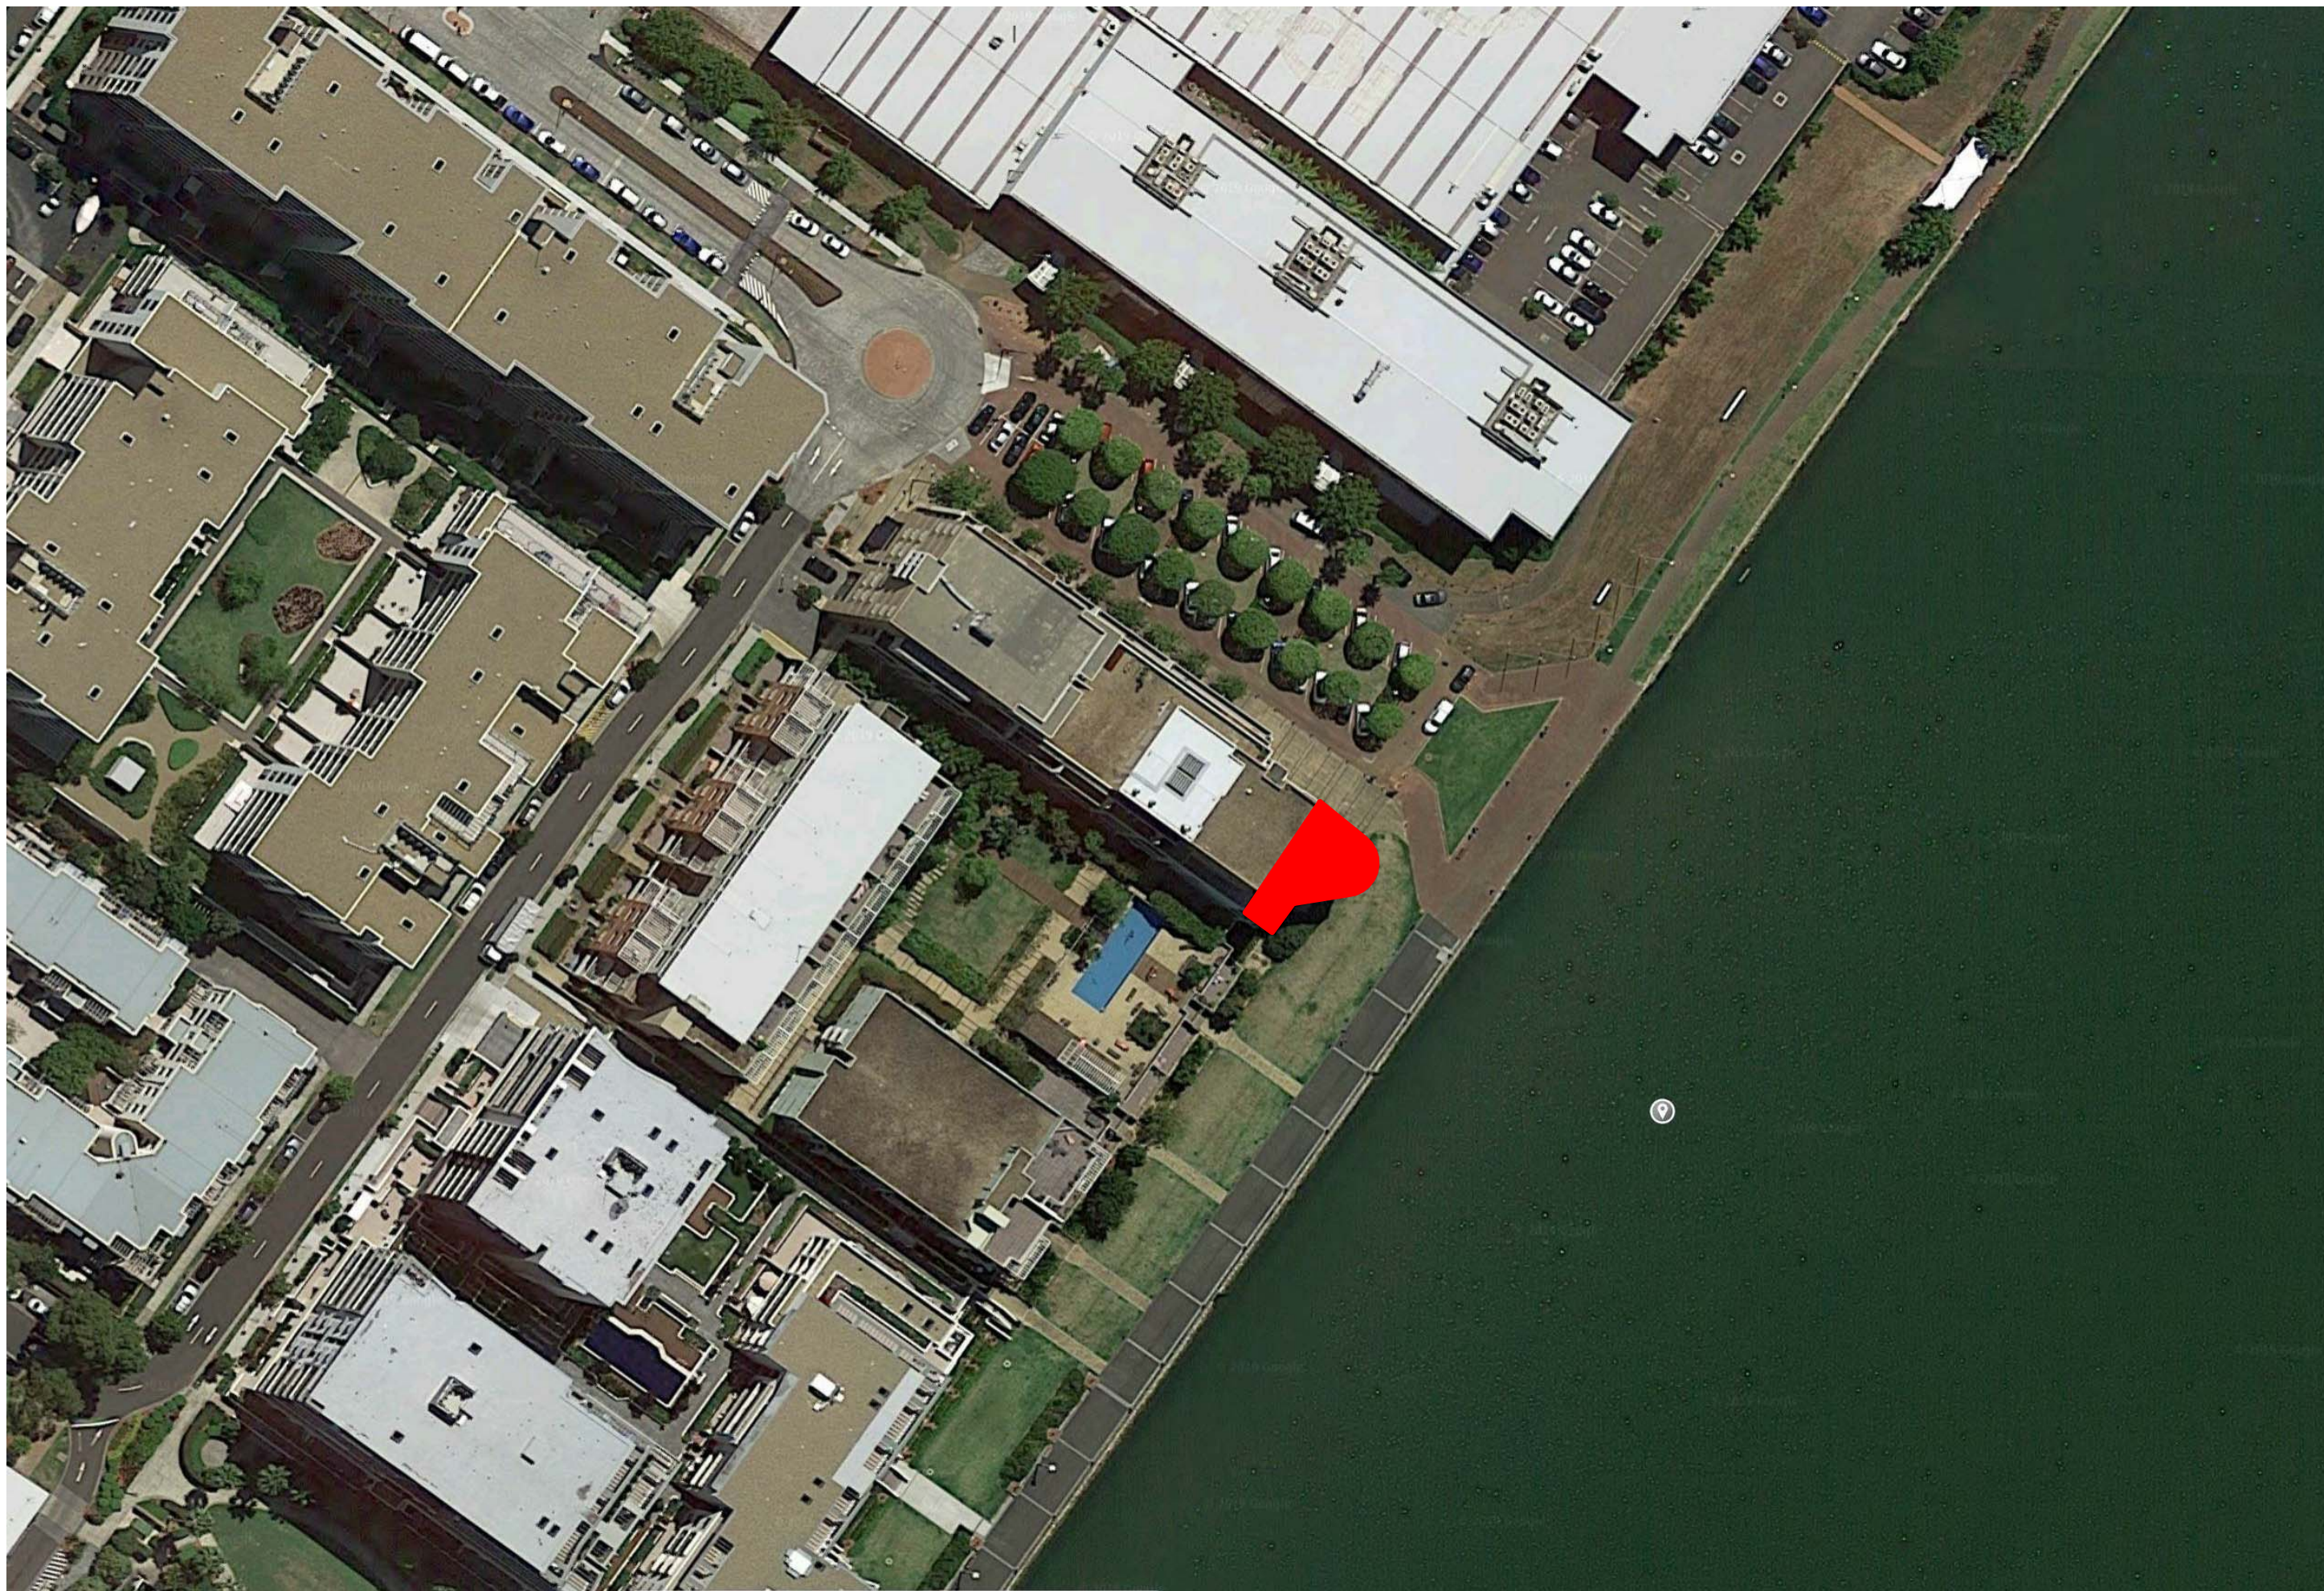

Location Plan

DRAWING LIST

SHEET NUMBER	SHEET NAME	SCALE 1:
A00	COVER PAGE	1
A01	SUN STUDIES	2000
A01	SUN STUDIES	2000
A01	SUN STUDIES	2000
A01	SUN STUDIES	2000
A01	SUN STUDIES	2000
A01	SUN STUDIES	2000
A02	LEVEL ONE FLOOR PLAN	100
A03	LEVEL ONE RCP	100
A04	LEVEL TWO FLOOR PLAN	100
A05	LEVEL TWO RCP	100
A06	SECTION ONE	50
A07	SECTION TWO	50
A08	SECTION THREE	50
A09	BAR DETAIL PLAN & BAR ELEVATIONS 1	20
A09	BAR DETAIL PLAN & BAR ELEVATIONS 1	20
A10	BAR ELEVATIONS 2 & 3	20
A10	BAR ELEVATIONS 2 & 3	20
A11	BAR ELEVATIONS 4 & 5	20
A11	BAR ELEVATIONS 4 & 5	20
A12	BAR ELEVATIONS 6 & 7	20
A12	BAR ELEVATIONS 6 & 7	20
A13	BAR SECTION 1 & ISOMETRIC VIEW	20
A13	BAR SECTION 1 & ISOMETRIC VIEW	20
A14	BAR DETAIL SECTION	5
A15	SHELVING SYSTEM DEATIL SECTION	2
A16	STAIR LOWER & UPPER PLANS	20
A16	STAIR LOWER & UPPER PLANS	20
A17	STAIR ELEVATIONS 1 & 2	20
A17	STAIR ELEVATIONS 1 & 2	20
A18	STAIR ELEVATIONS 3 & 4	20
A18	STAIR ELEVATIONS 3 & 4	20
A19	STAIR ELEVATION 5 & 6	20
A19	STAIR ELEVATION 5 & 6	20
A20	STAIR ELEVATION 7 & 8	20
A20	STAIR ELEVATION 7 & 8	20
A21	STAIR SECTION 1	20
A21	STAIR SECTION 1	20
A22	STAIR DETAIL SECTIONS	5
A22	STAIR DETAIL SECTIONS	5
A23	STAIR ISOMETRIC VIEWS	20
A23	STAIR ISOMETRIC VIEWS	20

ROOM SHEDULE

Name	Area	Level
Accessible Toilet	6 m ²	LEVEL 1
Bar	18 m ²	LEVEL 1
Bar Tables	5 m ²	LEVEL 1
Cleaning Closet	3 m ²	LEVEL 1
Cool Room	11 m ²	LEVEL 1
Dining Room	52 m ²	LEVEL 1
Dish Washing	11 m ²	LEVEL 1
Dry Storage	12 m ²	LEVEL 1
Entrance	17 m ²	LEVEL 1
Female Toilets	13 m ²	LEVEL 1
Food Preperation	15 m ²	LEVEL 1
Freezer Room	5 m ²	LEVEL 1
Male Toilets	7 m ²	LEVEL 1
Mezzanine Dining Room	107 m ²	LEVEL 2
Seating	14 m ²	LEVEL 1
Service Kitchen	23 m ²	LEVEL 1
Staff Room	4 m ²	LEVEL 1
Unisex Basins	5 m ²	LEVEL 1
Walk way	5 m ²	LEVEL 1

LEGEND

CUT PATTERN LEGEND

EXISTING		INSULATION	
CONCRETE		EARTH	
MDF		TILE	
TIMBER		STEEL	
ALUMINUM			

ABBREVIATIONS

FFL	Finished Floor Level	EQ	Specialty Equipment
FCL	Finished Ceiling Level	AP	Electrical Equipment
SE	Services	SA	Plumbing Fixture
MA	Material	LI	Lighting Fixture
FU	Furniture	WC	Water Closet

WALL TYPES

STW1	116mm Dry-Dry Wall 13mm Plaster Board, 90mm Timber Stud Frame13mm Plaster Board
STW2	116mm Wet-Dry Wall 13mm Plaster Board, 90mm Timber Stud Frame13mm Plaster Board, 2mm Glue, 10mm Tile
STW3	116mm Wet-Wet Wall 10mm Tile, 2mm Glue, 13mm Plaster Board, 90mm Timber Stud Frame13mm Plaster Board, 2mm Glue, 10mm Tile

DOOR AND WINDOW TAGS


D1	Door Tag	W1	Window Tag
----	----------	----	------------

Keynote Legend


NOTES

Revisions			Do not scale drawings. Use figured dimensions only. Check and verify levels and dimensions on site prior to commencement of any work, the preparation of drawings or the fabrication of components. This drawing is copyright and can not be reproduced without written consent.	Client Sue & Andy Baker Le Velo	True North	Billy Blue College of Design 46-52 Mountain Street, Ultimo, NSW 2007, Australia +61 (0)2 9999 9999 BILLY BLUE COLLEGE OF DESIGN TORRENS UNIVERSITY AUSTRALIA LAUREATE INTERNATIONAL UNIVERSITIES	Project IDC302A Assessment Brief 2 46 Baywater Drive, Wentworth Point, NSW, 2127 Project number Year. 2019	Drawing Title COVER PAGE Drawing Status PRESENTATION DRAWINGS NOT FOR CONSTRUCTION	Scale Drawing No Issue Date 17.05.2019 Drawn by PRM		
No	Date	Description	Ver. App'd								
01	17.05.2019	PRESENTATION DRAWINGS	Approver								


10/05/2019 8:04:17 AM

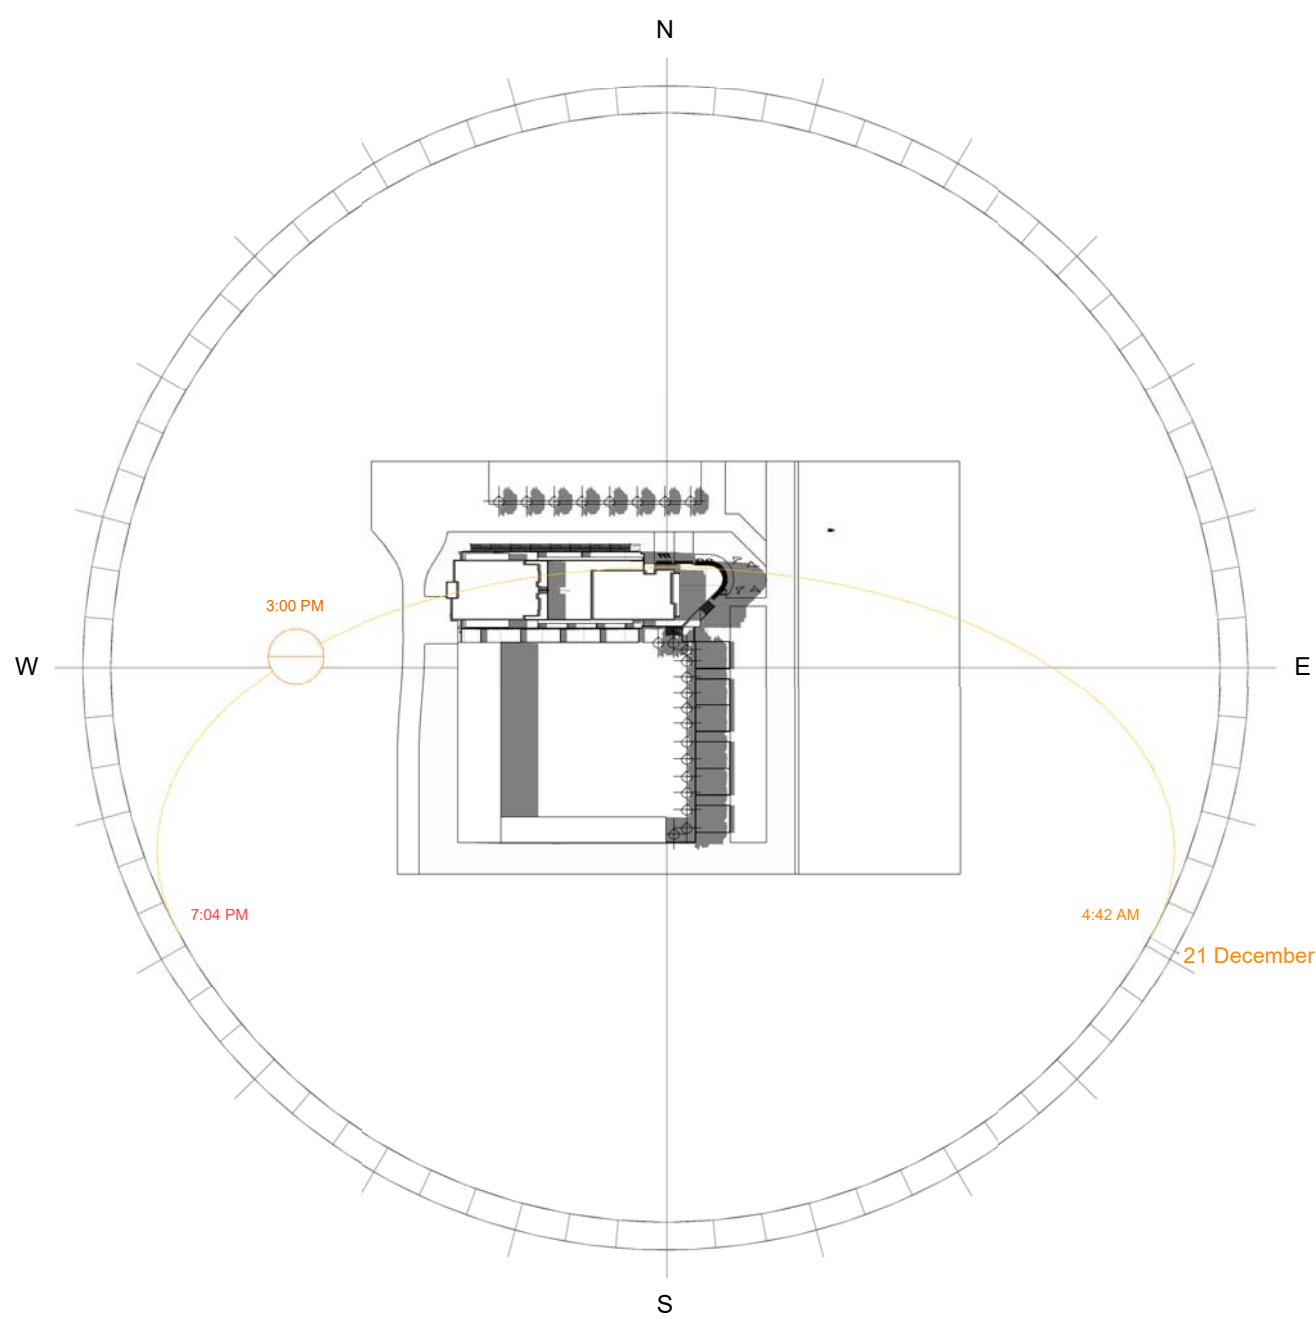


5 3pm Summer

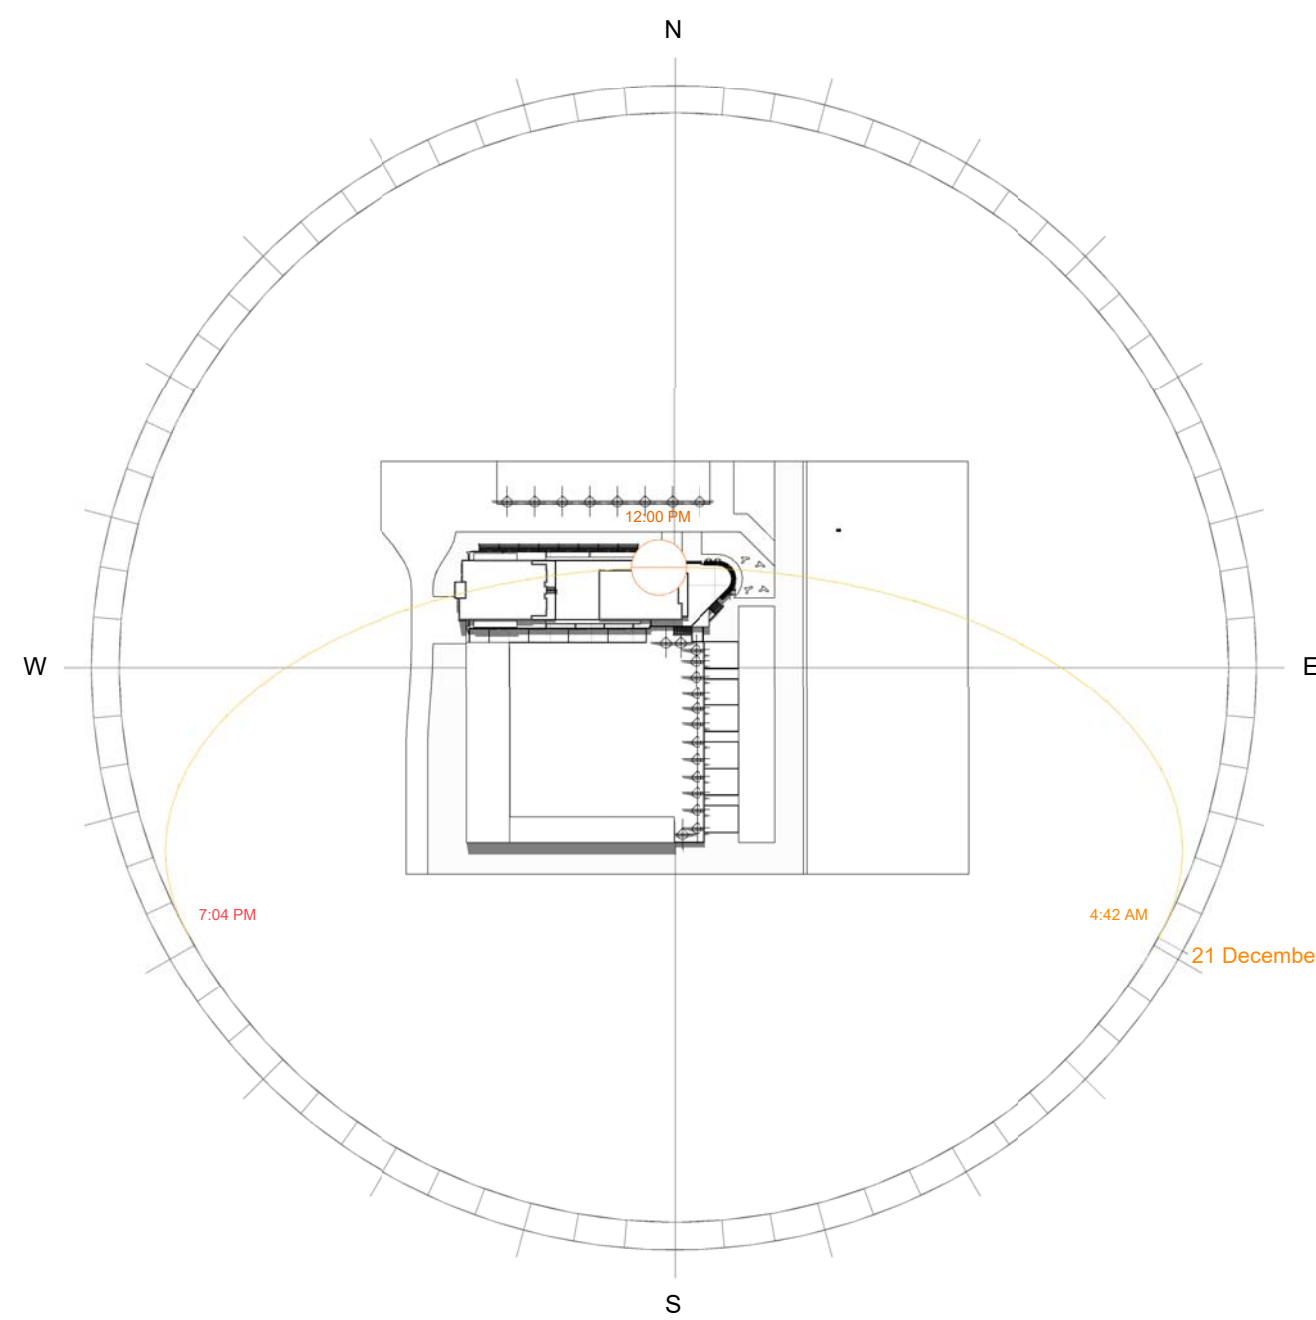


6 12pm Summer

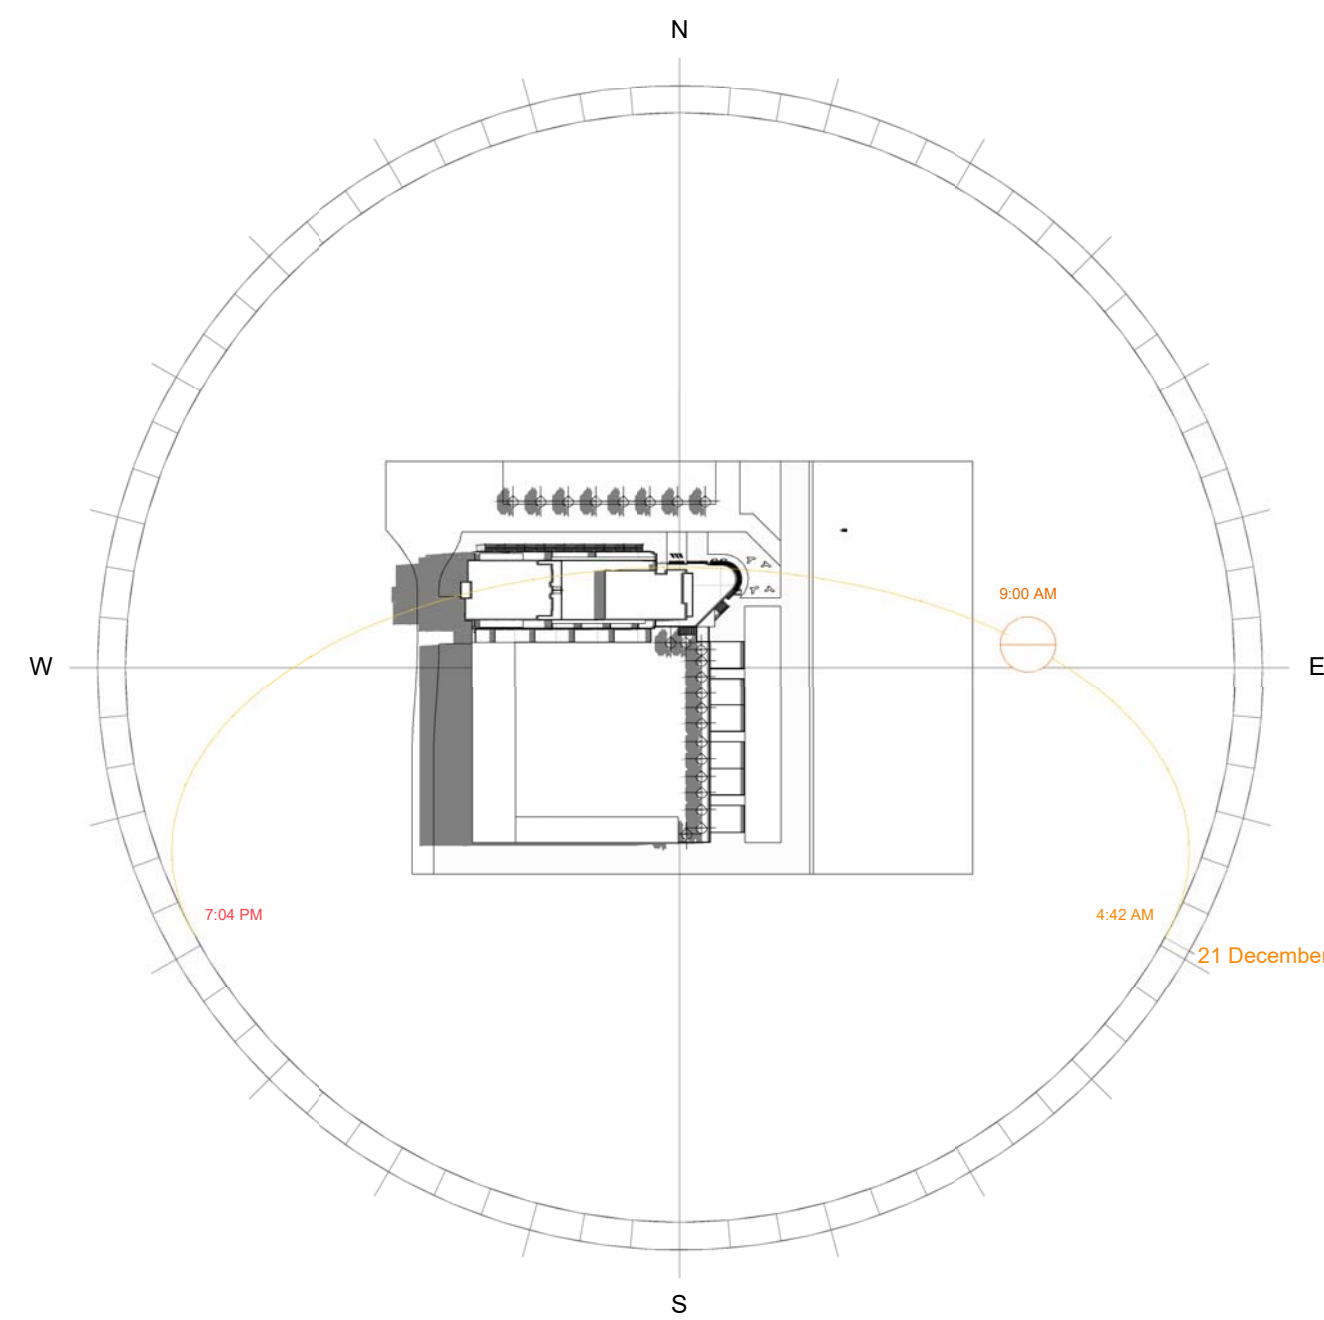


4 9am Summer

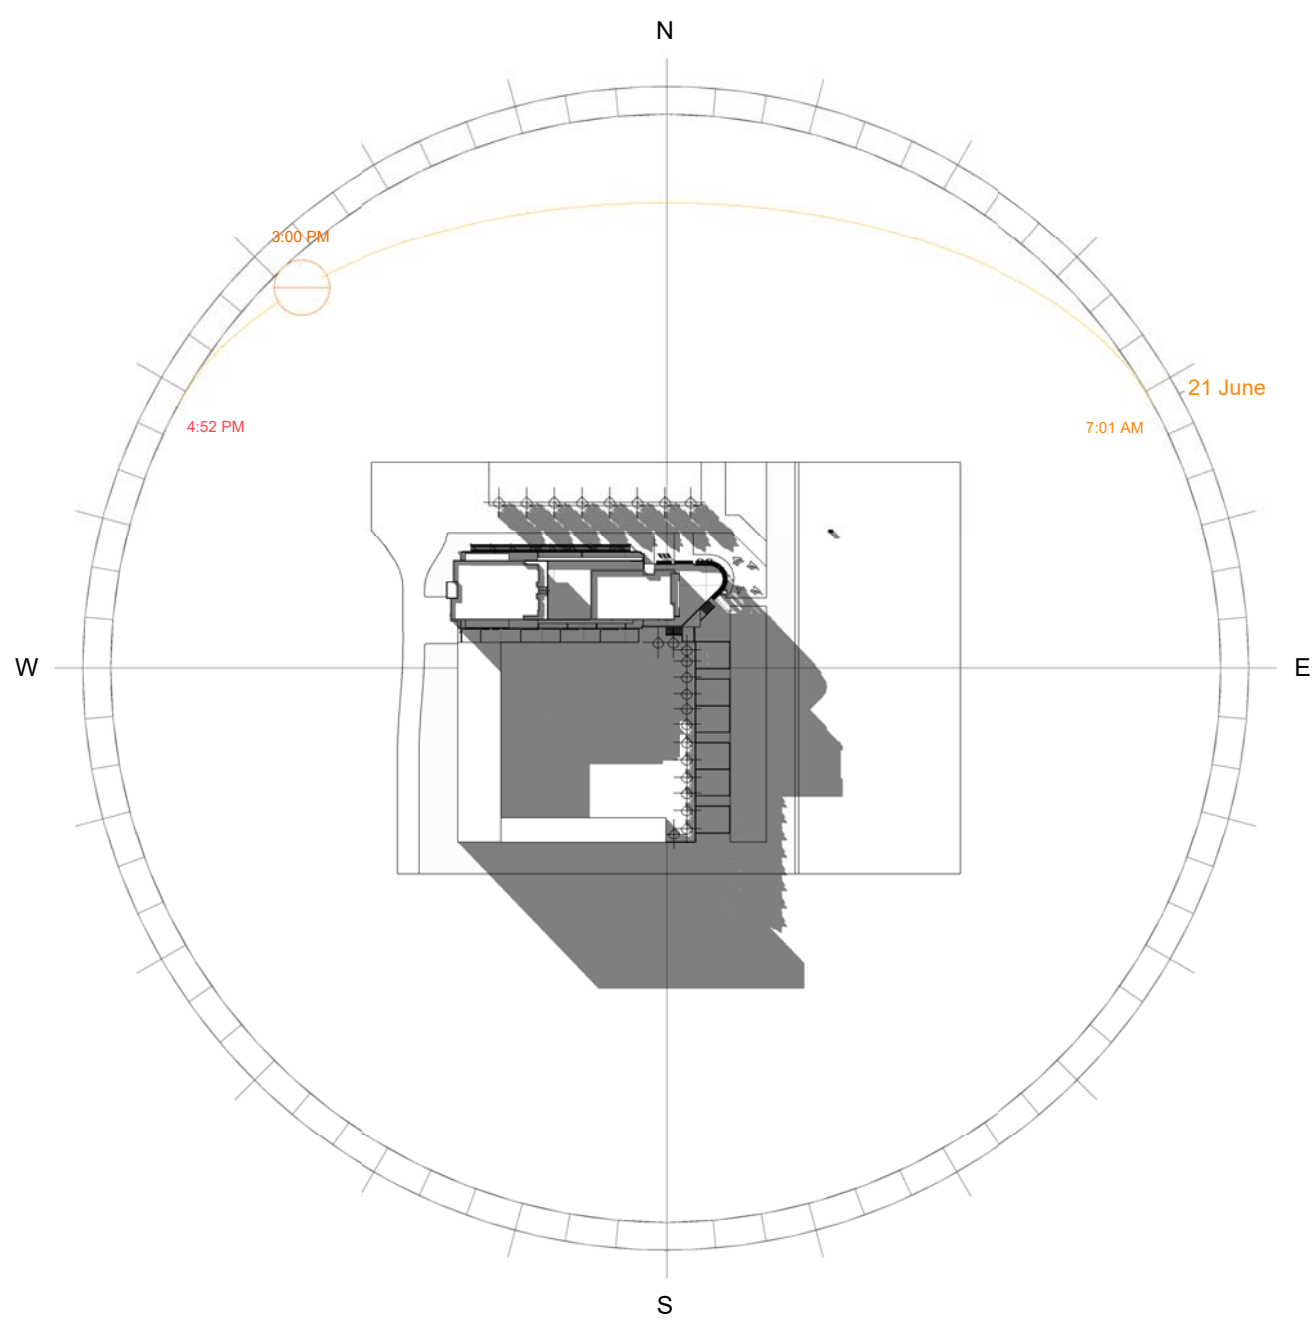

3 3pm Winter

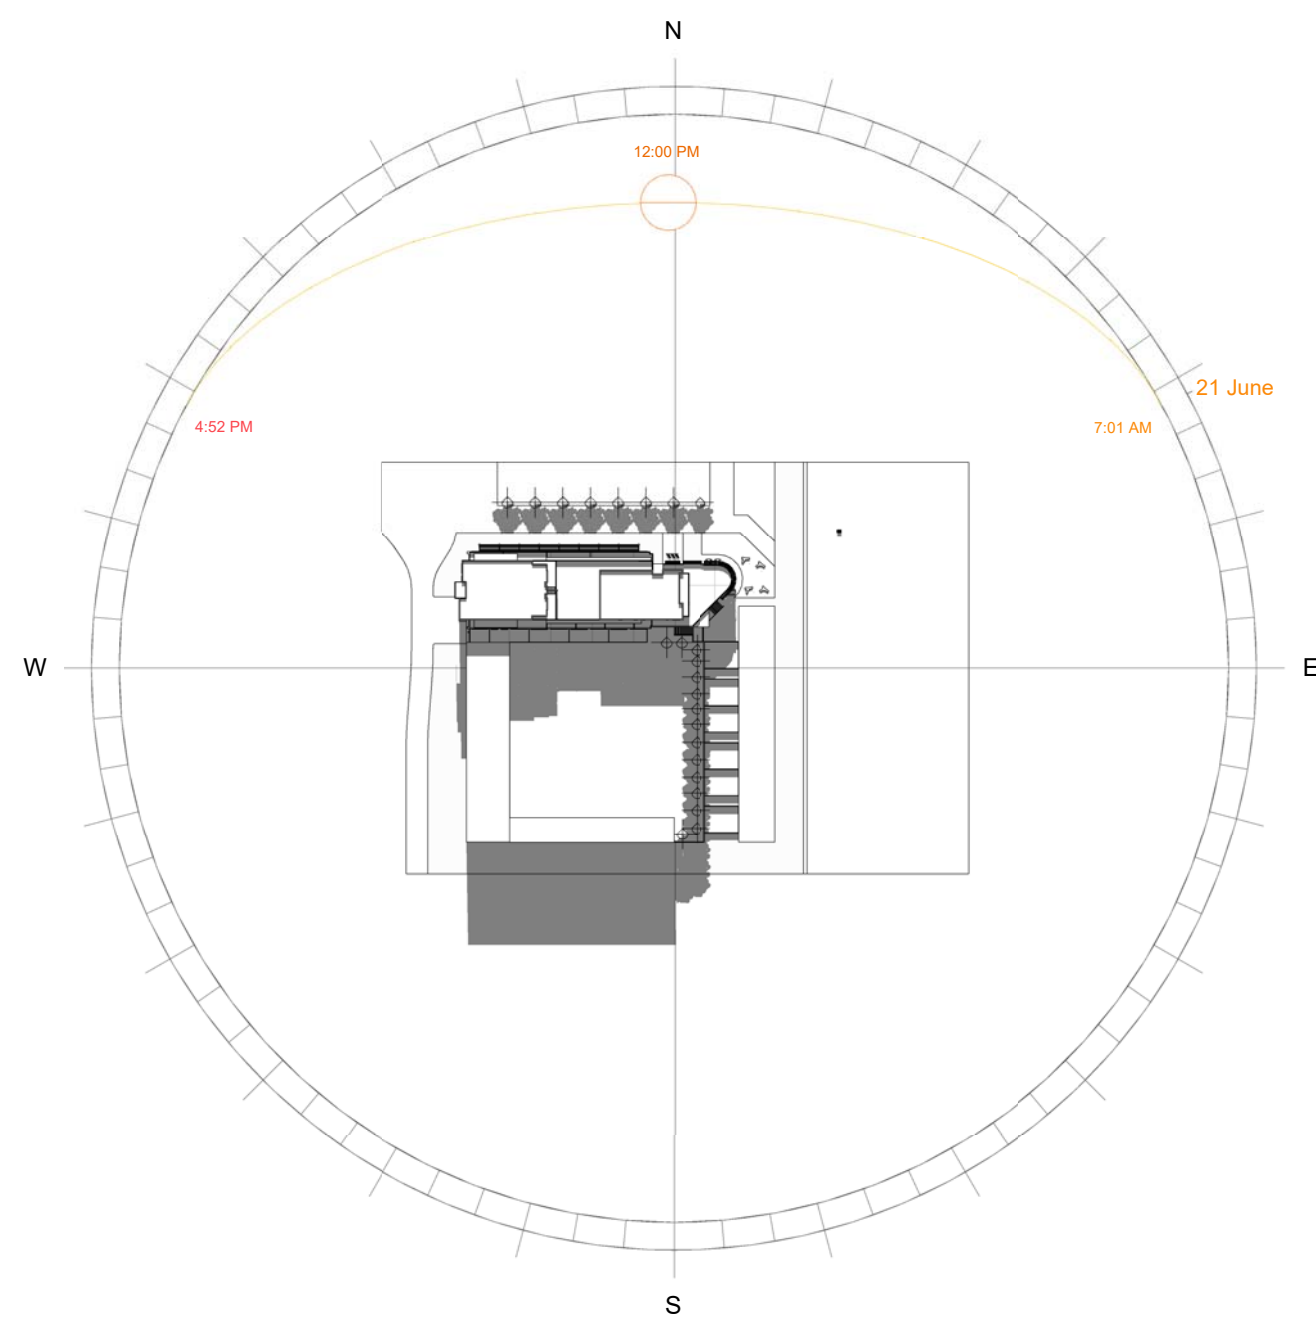

2 12pm Winter

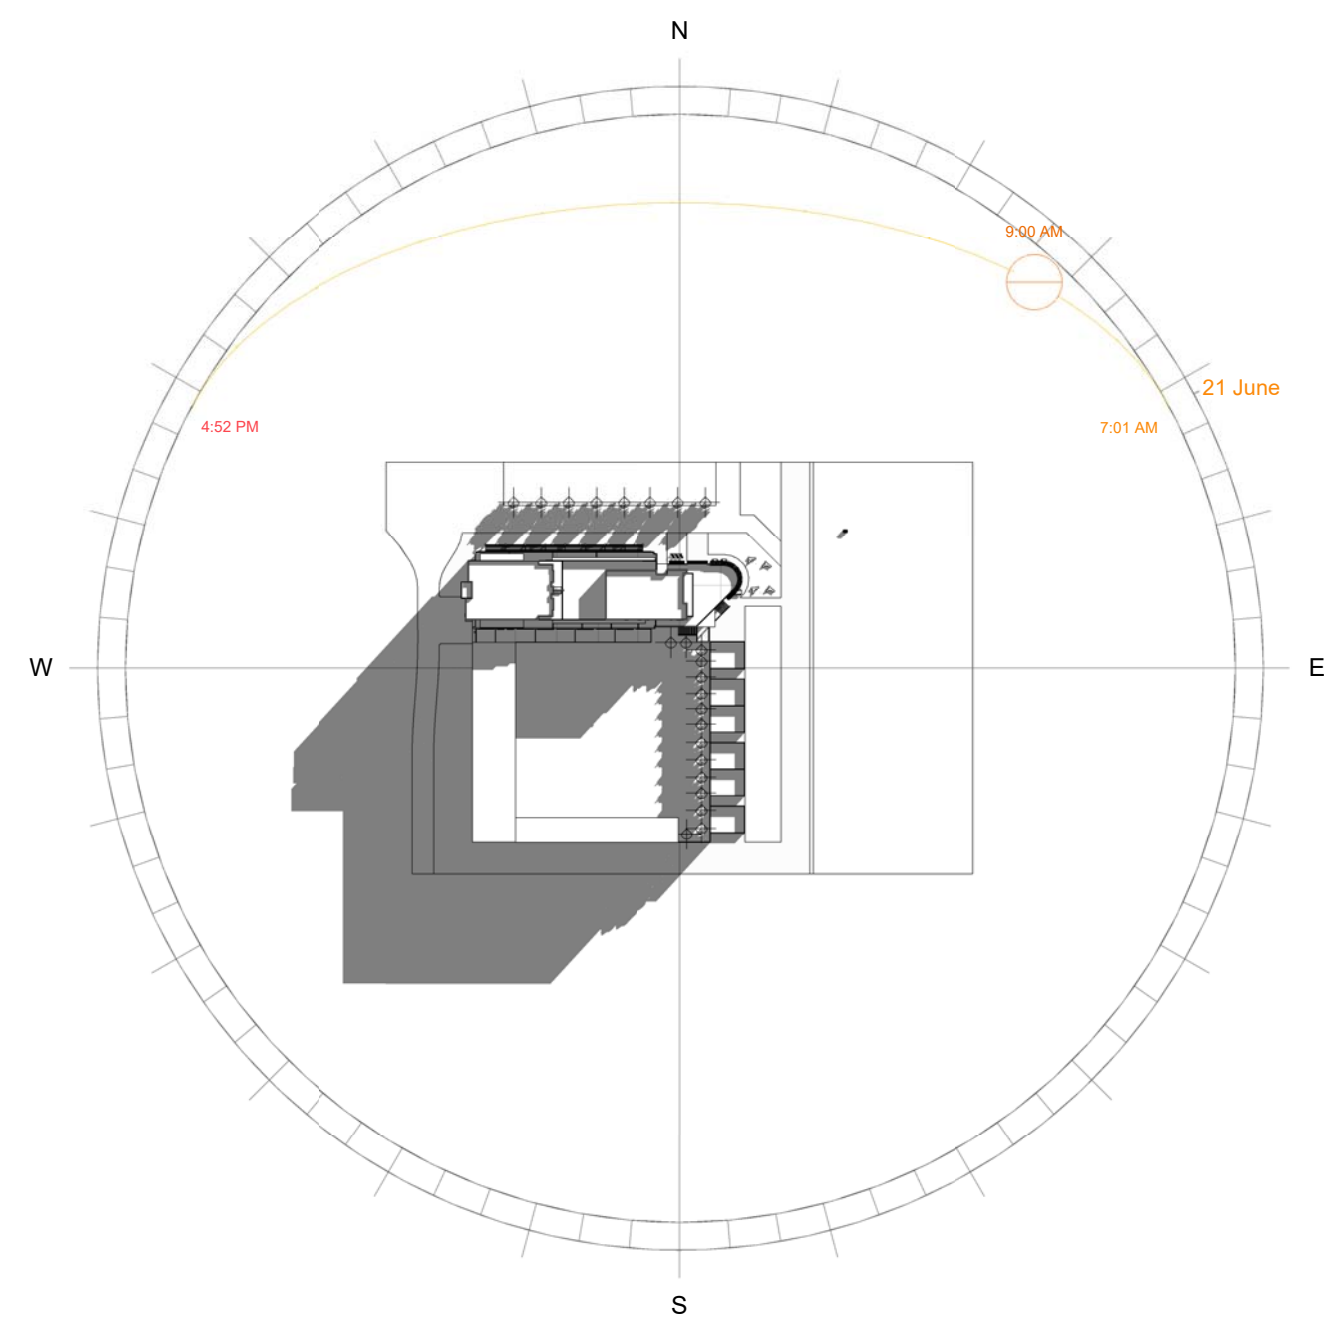

1 9am Winter

LEGEND

CUT PATTERN LEGEND

EXISTING		INSULATION	
CONCRETE		EARTH	
MDF		TILE	
TIMBER		STEEL	
ALUMINUM			

ABBREVIATIONS

FFL	Finished Floor Level	EQ	Specialty Equipment
FCL	Finished Ceiling Level	AP	Electrical Equipment
SE	Services	SA	Plumbing Fixture
MA	Material	LI	Lighting Fixture
FU	Furniture	WC	Water Closet

WALL TYPES

STW1 116mm Dry-Dry Wall
13mm Plaster Board, 90mm Timber Stud Frame13mm Plaster Board

STW2 116mm Wet-Dry Wall
13mm Plaster Board, 90mm Timber Stud Frame13mm Plaster Board, 2mm Glue, 10mm Tile

STW3 116mm Wet-Wet Wall
10mm Tile, 2mm Glue, 13mm Plaster Board, 90mm Timber Stud Frame13mm Plaster Board, 2mm Glue, 10mm Tile

DOOR AND WINDOW TAGS

D1 Door Tag W1 Window Tag

Keynote Legend

NOTES

Revisions			Do not scale drawings. Use figured dimensions only. Check and verify levels and dimensions on site prior to commencement of any work, the preparation of drawings or the fabrication of components. This drawing is copyright and can not be reproduced without written consent.
No	Date	Description	
01	17.05.2019	PRESENTATION DRAWINGS	

Client
Sue & Andy Baker

Le Velo

True North

Billy Blue College of Design
46-52 Mountain Street, Ultimo, NSW 2007, Australia
+61 (0)2 9999 9999

BILLY BLUE
COLLEGE OF DESIGN

TORRENS UNIVERSITY
AUSTRALIA

LAUREATE INTERNATIONAL UNIVERSITIES

Project
IDC302A Assessment Brief 2

46 Baywater Drive, Wentworth Point, NSW, 2127


Project number
Year. 2019

Drawing Title
SUN STUDIES

Drawing Status
PRESENTATION DRAWINGS
NOT FOR CONSTRUCTION

Scale	Drawing No	Issue
	A01	01
Date	17.05.2019	
Drawn by	PRM	

10/05/2019 8:04:56 AM

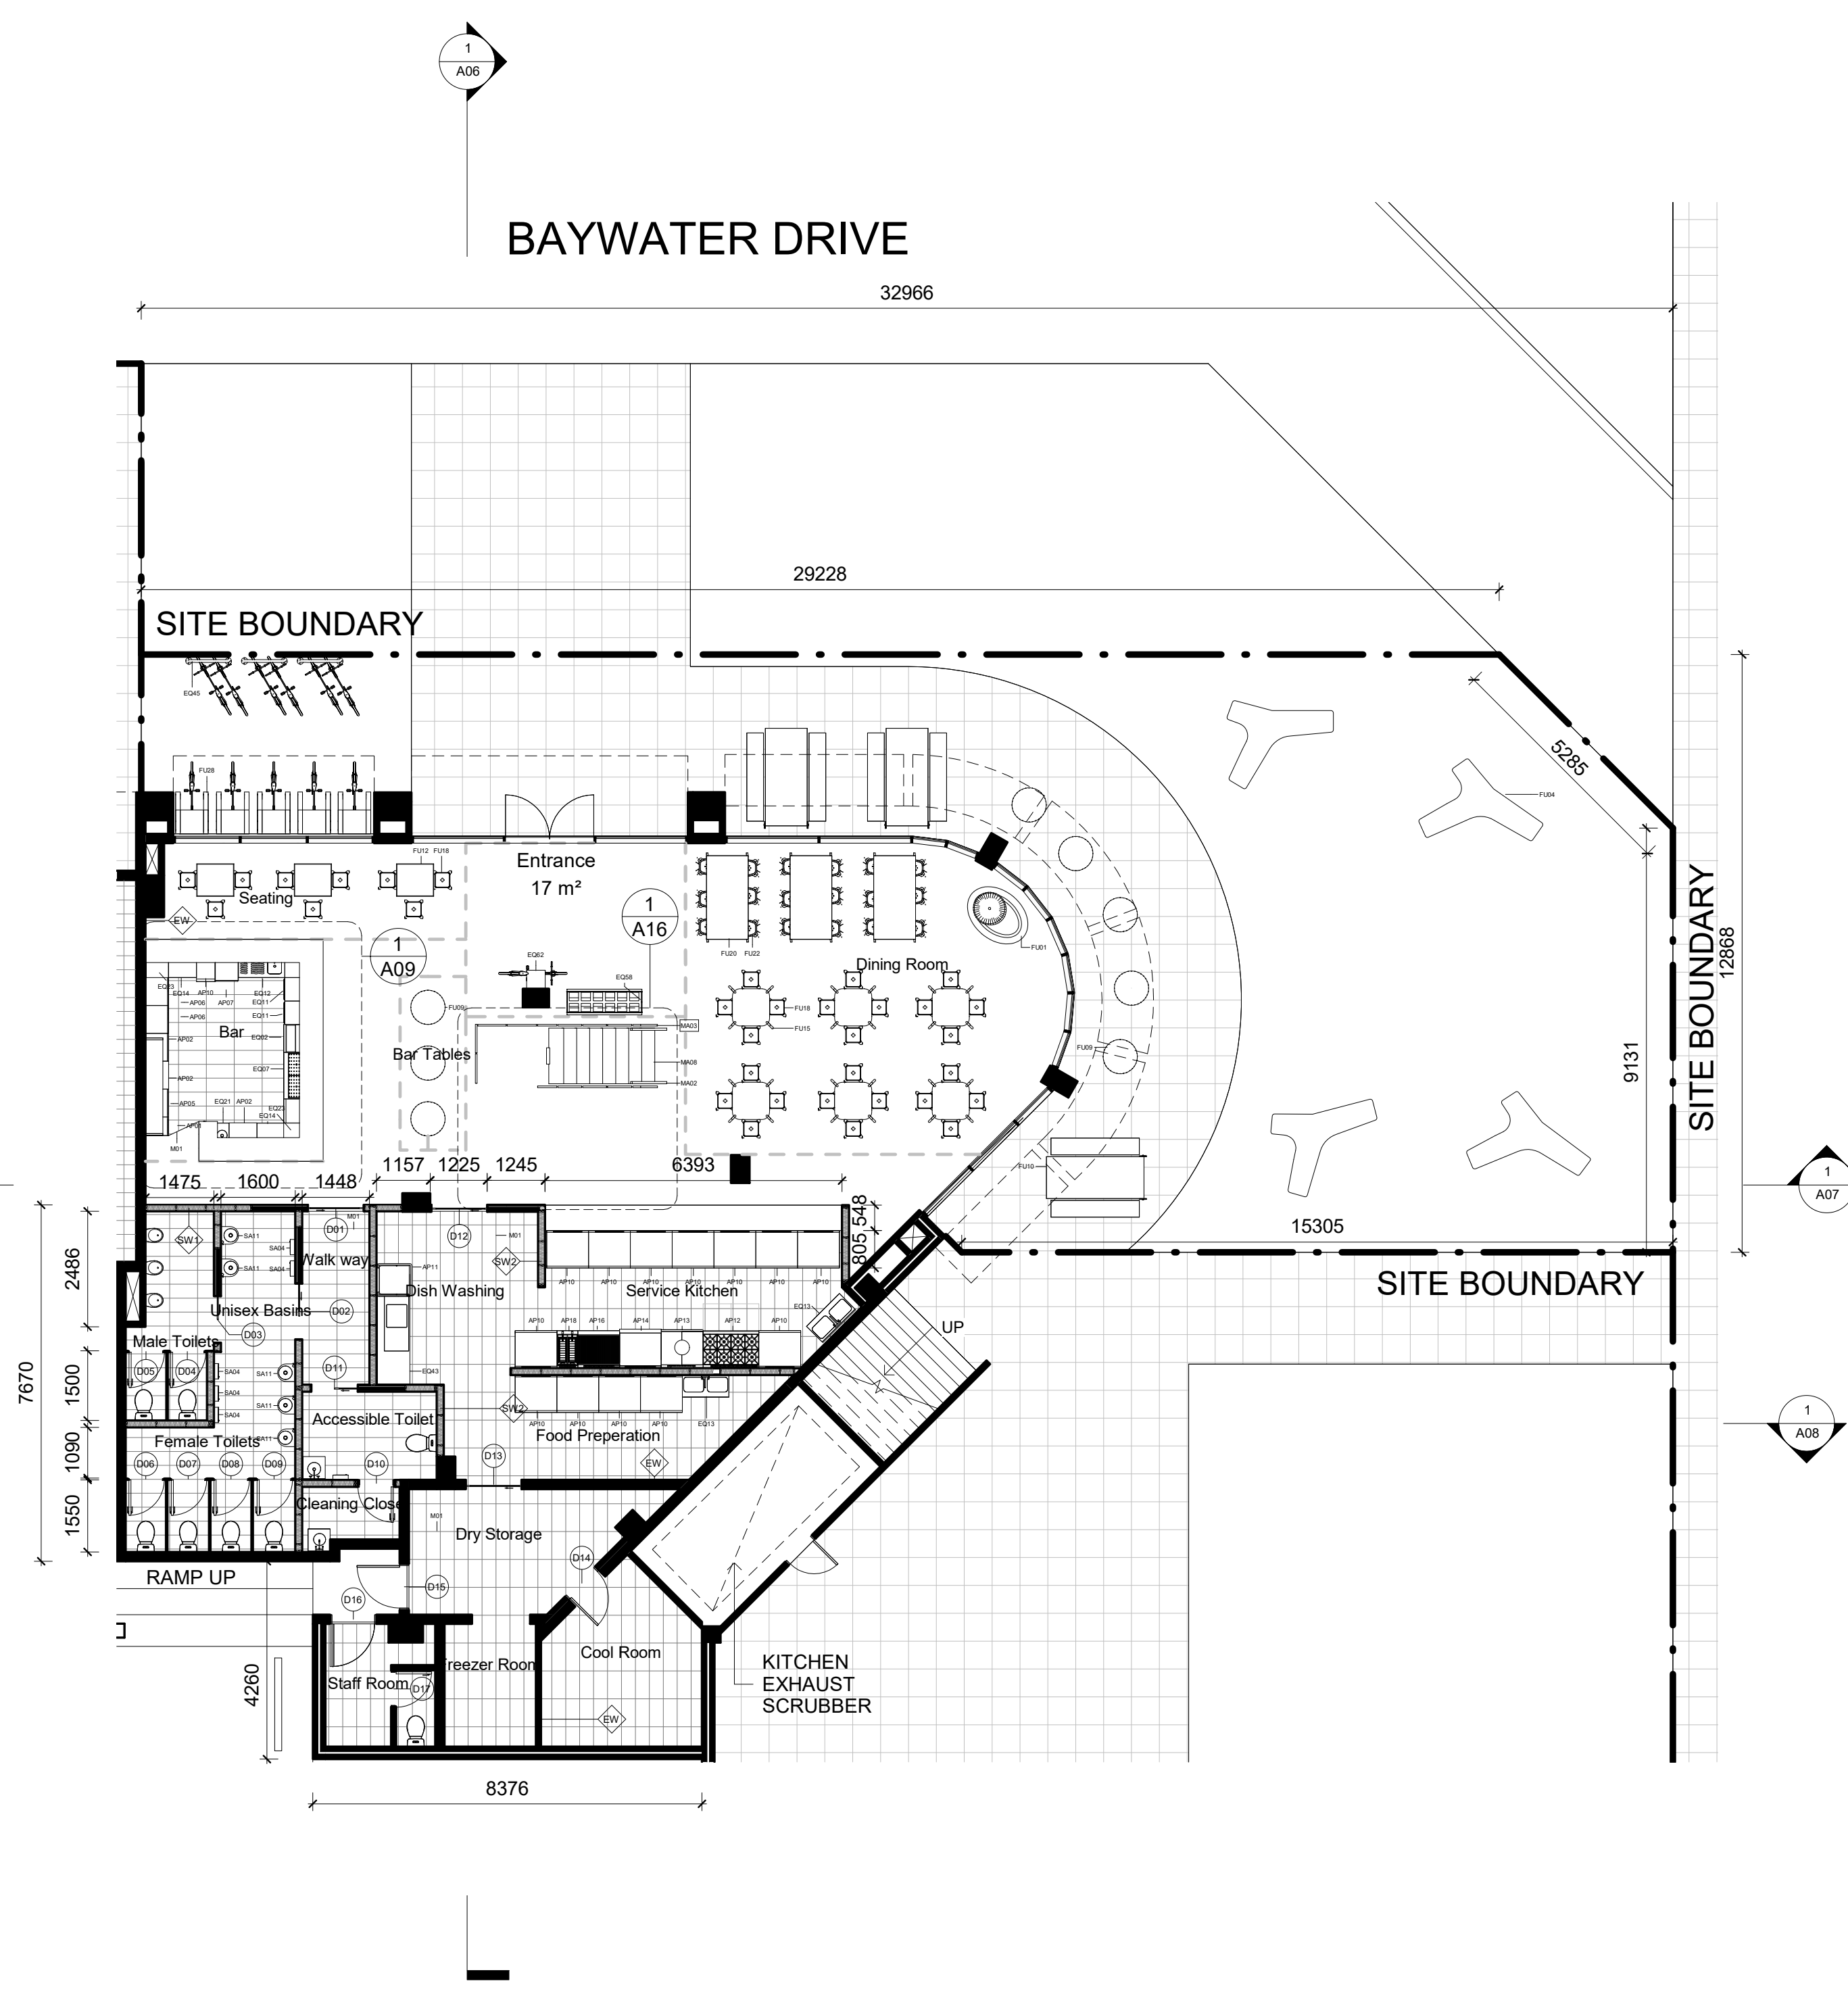

1 LEVEL 1
1 : 100

LEGEND

CUT PATTERN LEGEND

EXISTING	INSULATION
CONCRETE	EARTH
MDF	TILE
TIMBER	STEEL
ALUMINUM	

ABBREVIATIONS

FFL	Finished Floor Level	EQ	Specialty Equipment
FCL	Finished Ceiling Level	AP	Electrical Equipment
SE	Services	SA	Plumbing Fixture
MA	Material	LI	Lighting Fixture
FU	Furniture	WC	Water Closet

WALL TYPES

STW1	116mm Dry-Dry Wall 13mm Plaster Board, 90mm Timber Stud Frame 13mm Plaster Board
STW2	116mm Wet-Dry Wall 13mm Plaster Board, 90mm Timber Stud Frame 13mm Plaster Board, 2mm Glue, 10mm Tile
STW3	116mm Wet-Wet Wall 10mm Tile, 2mm Glue, 13mm Plaster Board, 90mm Timber Stud Frame 13mm Plaster Board, 2mm Glue, 10mm Tile


DOOR AND WINDOW TAGS


D1	Door Tag	W1	Window Tag
----	----------	----	------------


Keynote Legend

- AP01 Refrigeration module B16/704S by IMC
AP02 1x Glass Door add-on module B16/700S by IMC
AP05 1x Wine Chiller add-on module B16/703S
AP06 Mirage Tall single hinged door TC80 by IMC
AP07 Premium Glasswasher and Light Duty Dishwasher GM by Washtech
AP10 Benchtops 900mm BT8900-LS by Waldorf
AP11 Economy Passthrough Dishwasher ME by Washtech
AP12 1x8820 series 8 Burners double static oven RN8820G by Waldorf
AP13 8100 Series Target Top with Refrigerated Base Model RN8100G-RB by Waldorf
AP14 Gas Griddle 900mm GP8900G-LS by Waldorf
AP16 8900 series Charnitt 900mm CH8900G-LS by Waldorf
AP18 1x Gas Fryer FN8120C by Waldorf
EQ02 Ice Chest with covers BZ54/060 by IMC
EQ07 Perforated Workshop BZ59/100 by IMC
EQ11 Basket Rack with telescopic Slides BZ23/055 by IMC
EQ12 Single Sink BZ51/100 by IMC
EQ13 Double Sink BZ52/100 by IMC
EQ14 Worktop Unit BZ50/060 by IMC
EQ21 Leg Frame B602/208 by IMC
EQ23 Corner Top BZ17/051 by IMC
EQ43 Dishwasher inlet bench with sink and splash back R17120L By Ryno
EQ45 Semi Hoop Bike Stand BST03 by Street Furniture
EQ58 Kit coat stand and hook by Vilagrasso
EQ62 Bike holder by A.I.D
FU01 Bdllove Planter by BD Barcelona
FU04 Twig Bench By Derlot Editions
FU09 Jill Dinning Table Navy by Tait
FU10
FU12 TopTop for Dr. Yeas Square Table by Kartell
FU15 1x Solid Table by One Third
FU18 1x Good One Barstool (H750mm) by Tait
FU20 Good One Table by Tait
FU22 tba
FU28 Bike holder PIT IN by Muu Design Studio
M01
MA02 Powder coated Steel in Navy Blue
MA03 Tempered Glass Clear white
MA08
SA04 TrimLine Series Recessed Paper Towel Dispenser (B3803) by rba
SA11 Full height basin (RBA8881-100) by rba.

 NOTES



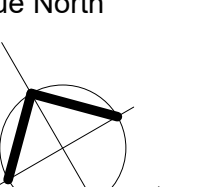Revisions			Do not scale drawings. Use figured dimensions only. Check and verify levels and dimensions on site prior to commencement of any work, the preparation of drawings or the fabrication of components. This drawing is copyright and can not be reproduced without written consent.	Client Sue & Andy Baker 	True North 	Billy Blue College of Design 46-52 Mountain Street, Ultimo, NSW 2007, Australia +61 (0)2 9999 9999   	Project IDC302A Assessment Brief 2 46 Baywater Drive, Wentworth Point, NSW, 2127 Project number Year. 2019	Drawing Title LEVEL ONE FLOOR PLAN Drawing Status PRESENTATION DRAWINGS NOT FOR CONSTRUCTION	Scale	Drawing No	Issue	
No	Date	Description							Ver. App'd	1:100	A02	01
01	17.05.2019	PRESENTATION DRAWINGS							Approver	Date	17.05.2019	Drawn by

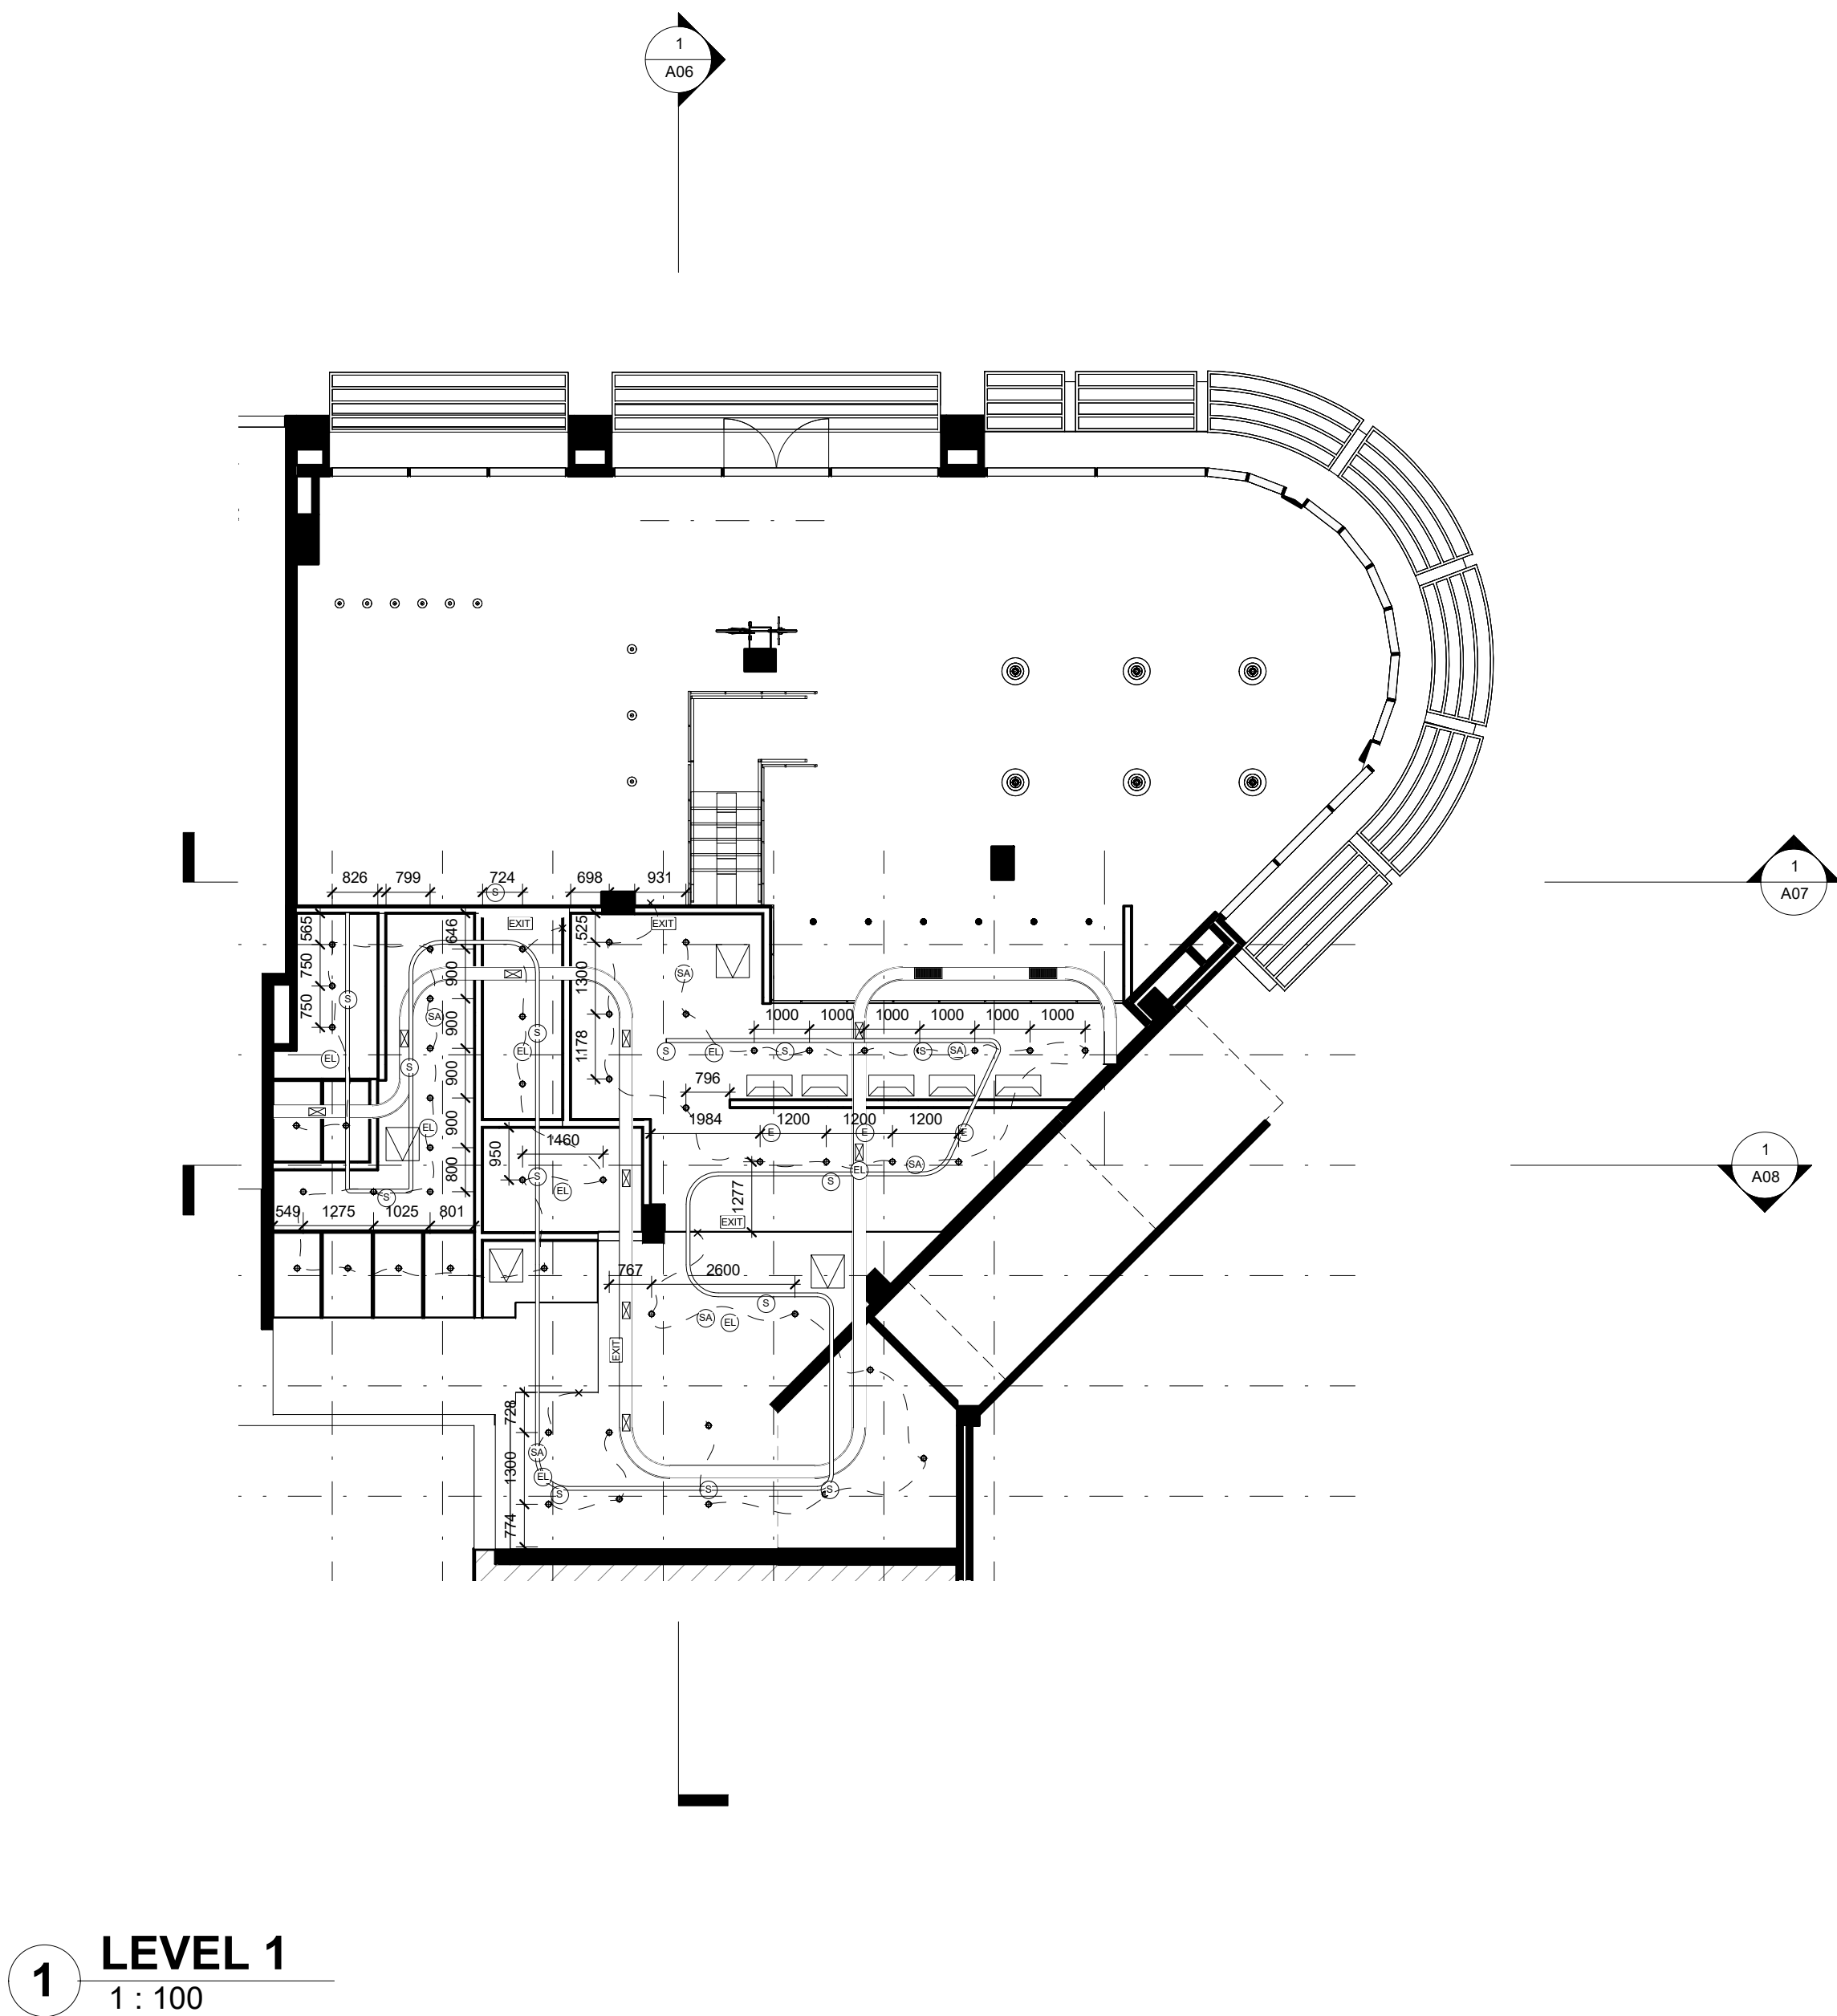

RCP LEGEND

- Pendant Light
- Down Light
- Wall Mounted Light
- Switch
- Two Way Switch
- Wiring
- Grid Line
- Smoke Alarm
- Centreline
- Sprinkler
- Airconditioning Grill in Dropped Ceiling
- Airconditioning Grill Exposed
- CL01 13mm Plaster Board with Rondo Suspended Hooks
- 600x600mm Access Panel
- EXIT Exit Sign
- Range Hood
- Ventilation
- EL Emergency Light
- E Exhaust Fan

LEGEND

CUT PATTERN LEGEND

- | | |
|----------|------------|
| EXISTING | INSULATION |
| CONCRETE | EARTH |
| MDF | TILE |
| TIMBER | STEEL |
| ALUMINUM | |

ABBREVIATIONS

- | | | | |
|-----|------------------------|----|----------------------|
| FFL | Finished Floor Level | EQ | Specialty Equipment |
| FCL | Finished Ceiling Level | AP | Electrical Equipment |
| SE | Services | SA | Plumbing Fixture |
| MA | Material | LI | Lighting Fixture |
| FU | Furniture | WC | Water Closet |

WALL TYPES

- STW1 116mm Dry-Dry Wall
13mm Plaster Board, 90mm Timber Stud Frame13mm Plaster Board
- STW2 116mm Wet-Dry Wall
13mm Plaster Board, 90mm Timber Stud Frame13mm Plaster Board, 2mm Glue, 10mm Tile
- Keynote Legend: Wet Wall
STW3 10mm Tile, 2mm Glue, 13mm Plaster Board, 90mm Timber Stud Frame13mm Plaster Board, 2mm Glue, 10mm Tile

DOOR AND WINDOW TAGS

- D1 Door Tag
- W1 Window Tag

NOTES

Revisions		
No	Date	Description
01	17.05.2019	PRESENTATION DRAWINGS

Ver. App'd
Approver

Do not scale drawings. Use figured dimensions only. Check and verify levels and dimensions on site prior to commencement of any work, the preparation of drawings or the fabrication of components.
This drawing is copyright and can not be reproduced without written consent.

Client
Sue & Andy Baker

Le Velo

True North




Billy Blue College of Design
46-52 Mountain Street, Ultimo, NSW 2007, Australia
+61 (0)2 9999 9999



Project
IDC302A Assessment Brief 2
46 Baywater Drive, Wentworth Point, NSW, 2127
Project number
Year. 2019

Drawing Title
LEVEL ONE RCP
Drawing Status
PRESENTATION DRAWINGS
NOT FOR CONSTRUCTION

Scale
1:100
Date
17.05.2019
Drawing No
A03
Issue
01
Drawn by
PRM

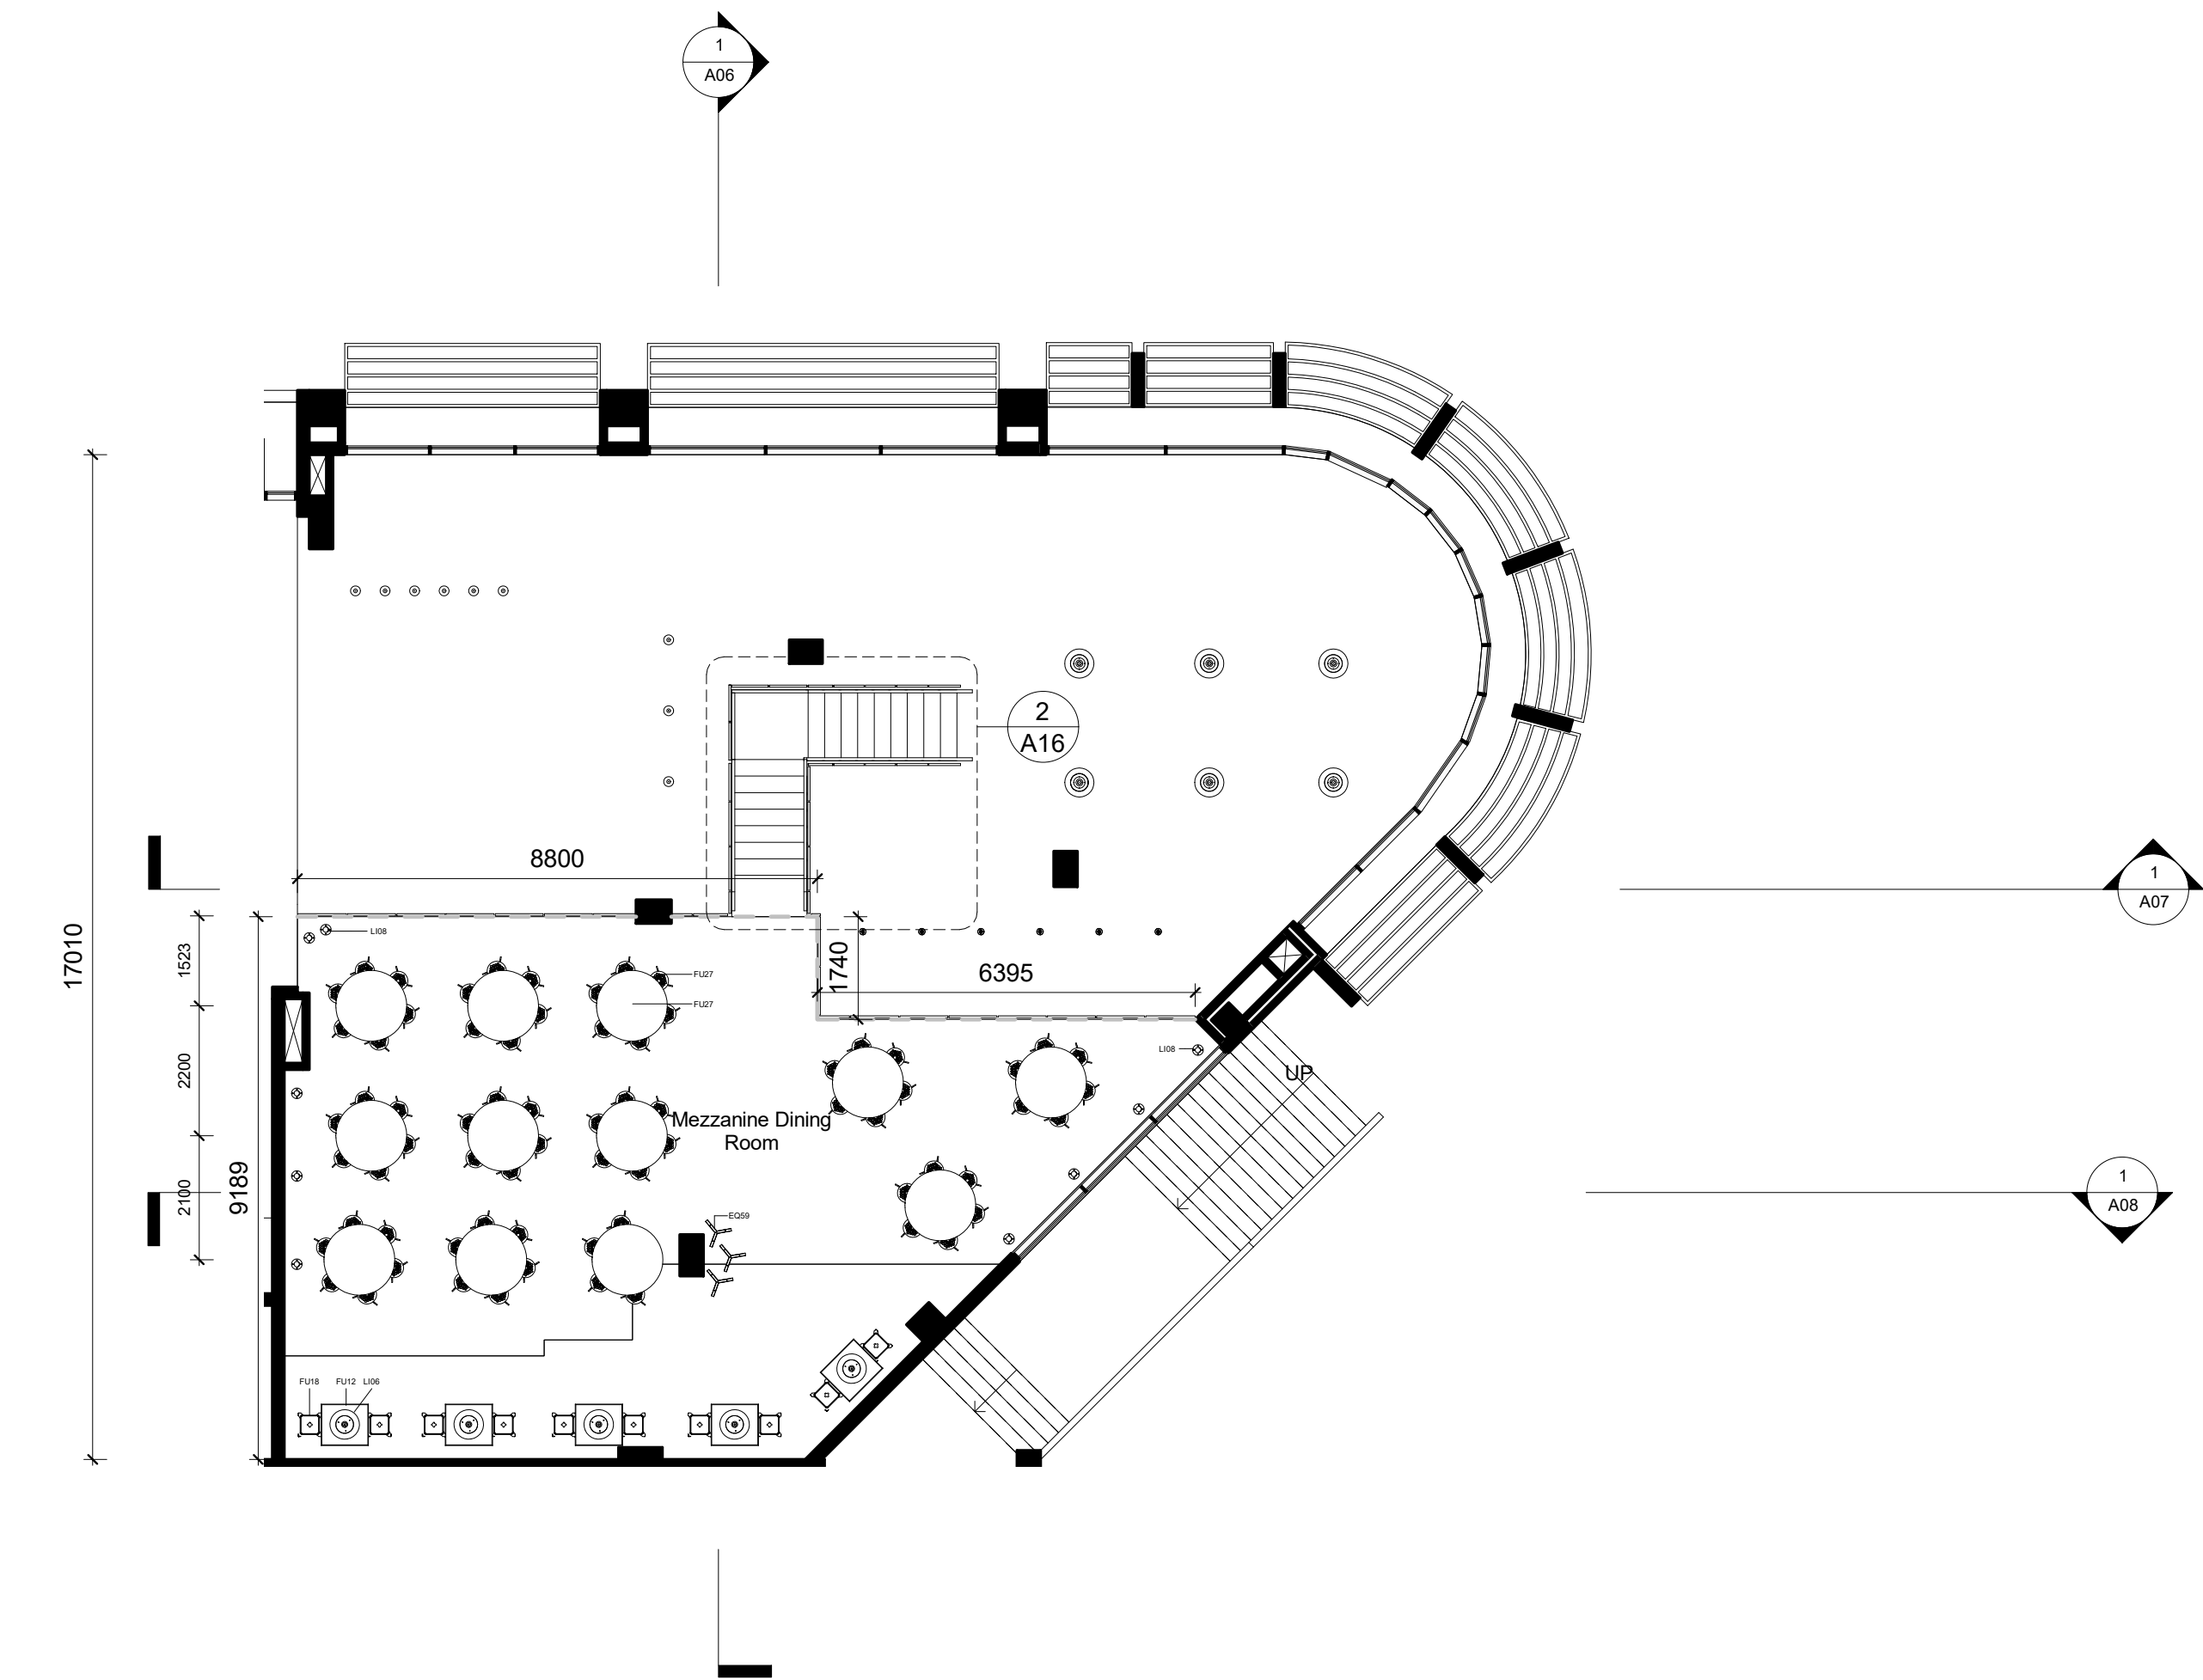

1 LEVEL 2
1 : 100


LEGEND			
CUT PATTERN LEGEND			
EXISTING		INSULATION	
CONCRETE		EARTH	
MDF		TILE	
TIMBER		STEEL	
ALUMINUM			
ABBREVIATIONS			
FFL	Finished Floor Level	EQ	Specialty Equipment
FCL	Finished Ceiling Level	AP	Electrical Equipment
SE	Services	SA	Plumbing Fixture
MA	Material	LI	Lighting Fixture
FU	Furniture	WC	Water Closet

WALL TYPES	
STW1	116mm Dry-Dry Wall 13mm Plaster Board, 90mm Timber Stud Frame 13mm Plaster Board
STW2	116mm Wet-Dry Wall 13mm Plaster Board, 90mm Timber Stud Frame 13mm Plaster Board, 2mm Glue, 10mm Tile
STW3	116mm Wet-Wet Wall 10mm Tile, 2mm Glue, 13mm Plaster Board, 90mm Timber Stud Frame 13mm Plaster Board, 2mm Glue, 10mm Tile

DOOR AND WINDOW TAGS	
D1	Door Tag
W1	Window Tag


Keynote Legend	
EQ59	Bend Coat stand by Cascando
FU12	TopTop for Dr. Yeas Square Table by Kartell
FU18	1x Good One Barstool (H750mm) by Tait
FU27	Screw table by Tom Dixon(H=750mm x D=1200mm)
LI06	Pale Rose Pendant PH50 by Louis Poulsen
LI08	Flindt Bollard by Louis Poulsen

 NOTES	



Revisions			Do not scale drawings. Use figured dimensions only. Check and verify levels and dimensions on site prior to commencement of any work, the preparation of drawings or the fabrication of components. This drawing is copyright and can not be reproduced without written consent.	Client Sue & Andy Baker Le Velo	True North 	Billy Blue College of Design 46-52 Mountain Street, Ultimo, NSW 2007, Australia +61 (0)2 9999 9999    LAUREATE INTERNATIONAL UNIVERSITIES	Project IDC302A Assessment Brief 2 46 Baywater Drive, Wentworth Point, NSW, 2127 Project number Year. 2019	Drawing Title LEVEL TWO FLOOR PLAN Drawing Status PRESENTATION DRAWINGS NOT FOR CONSTRUCTION	Scale	Drawing No	Issue	
No	Date	Description							Ver. App'd	1:100	A04	01
01	17.05.2019	PRESENTATION DRAWINGS							Approver	Date	17.05.2019	
										Drawn by	PRM	

1 LEVEL 2
1 : 100

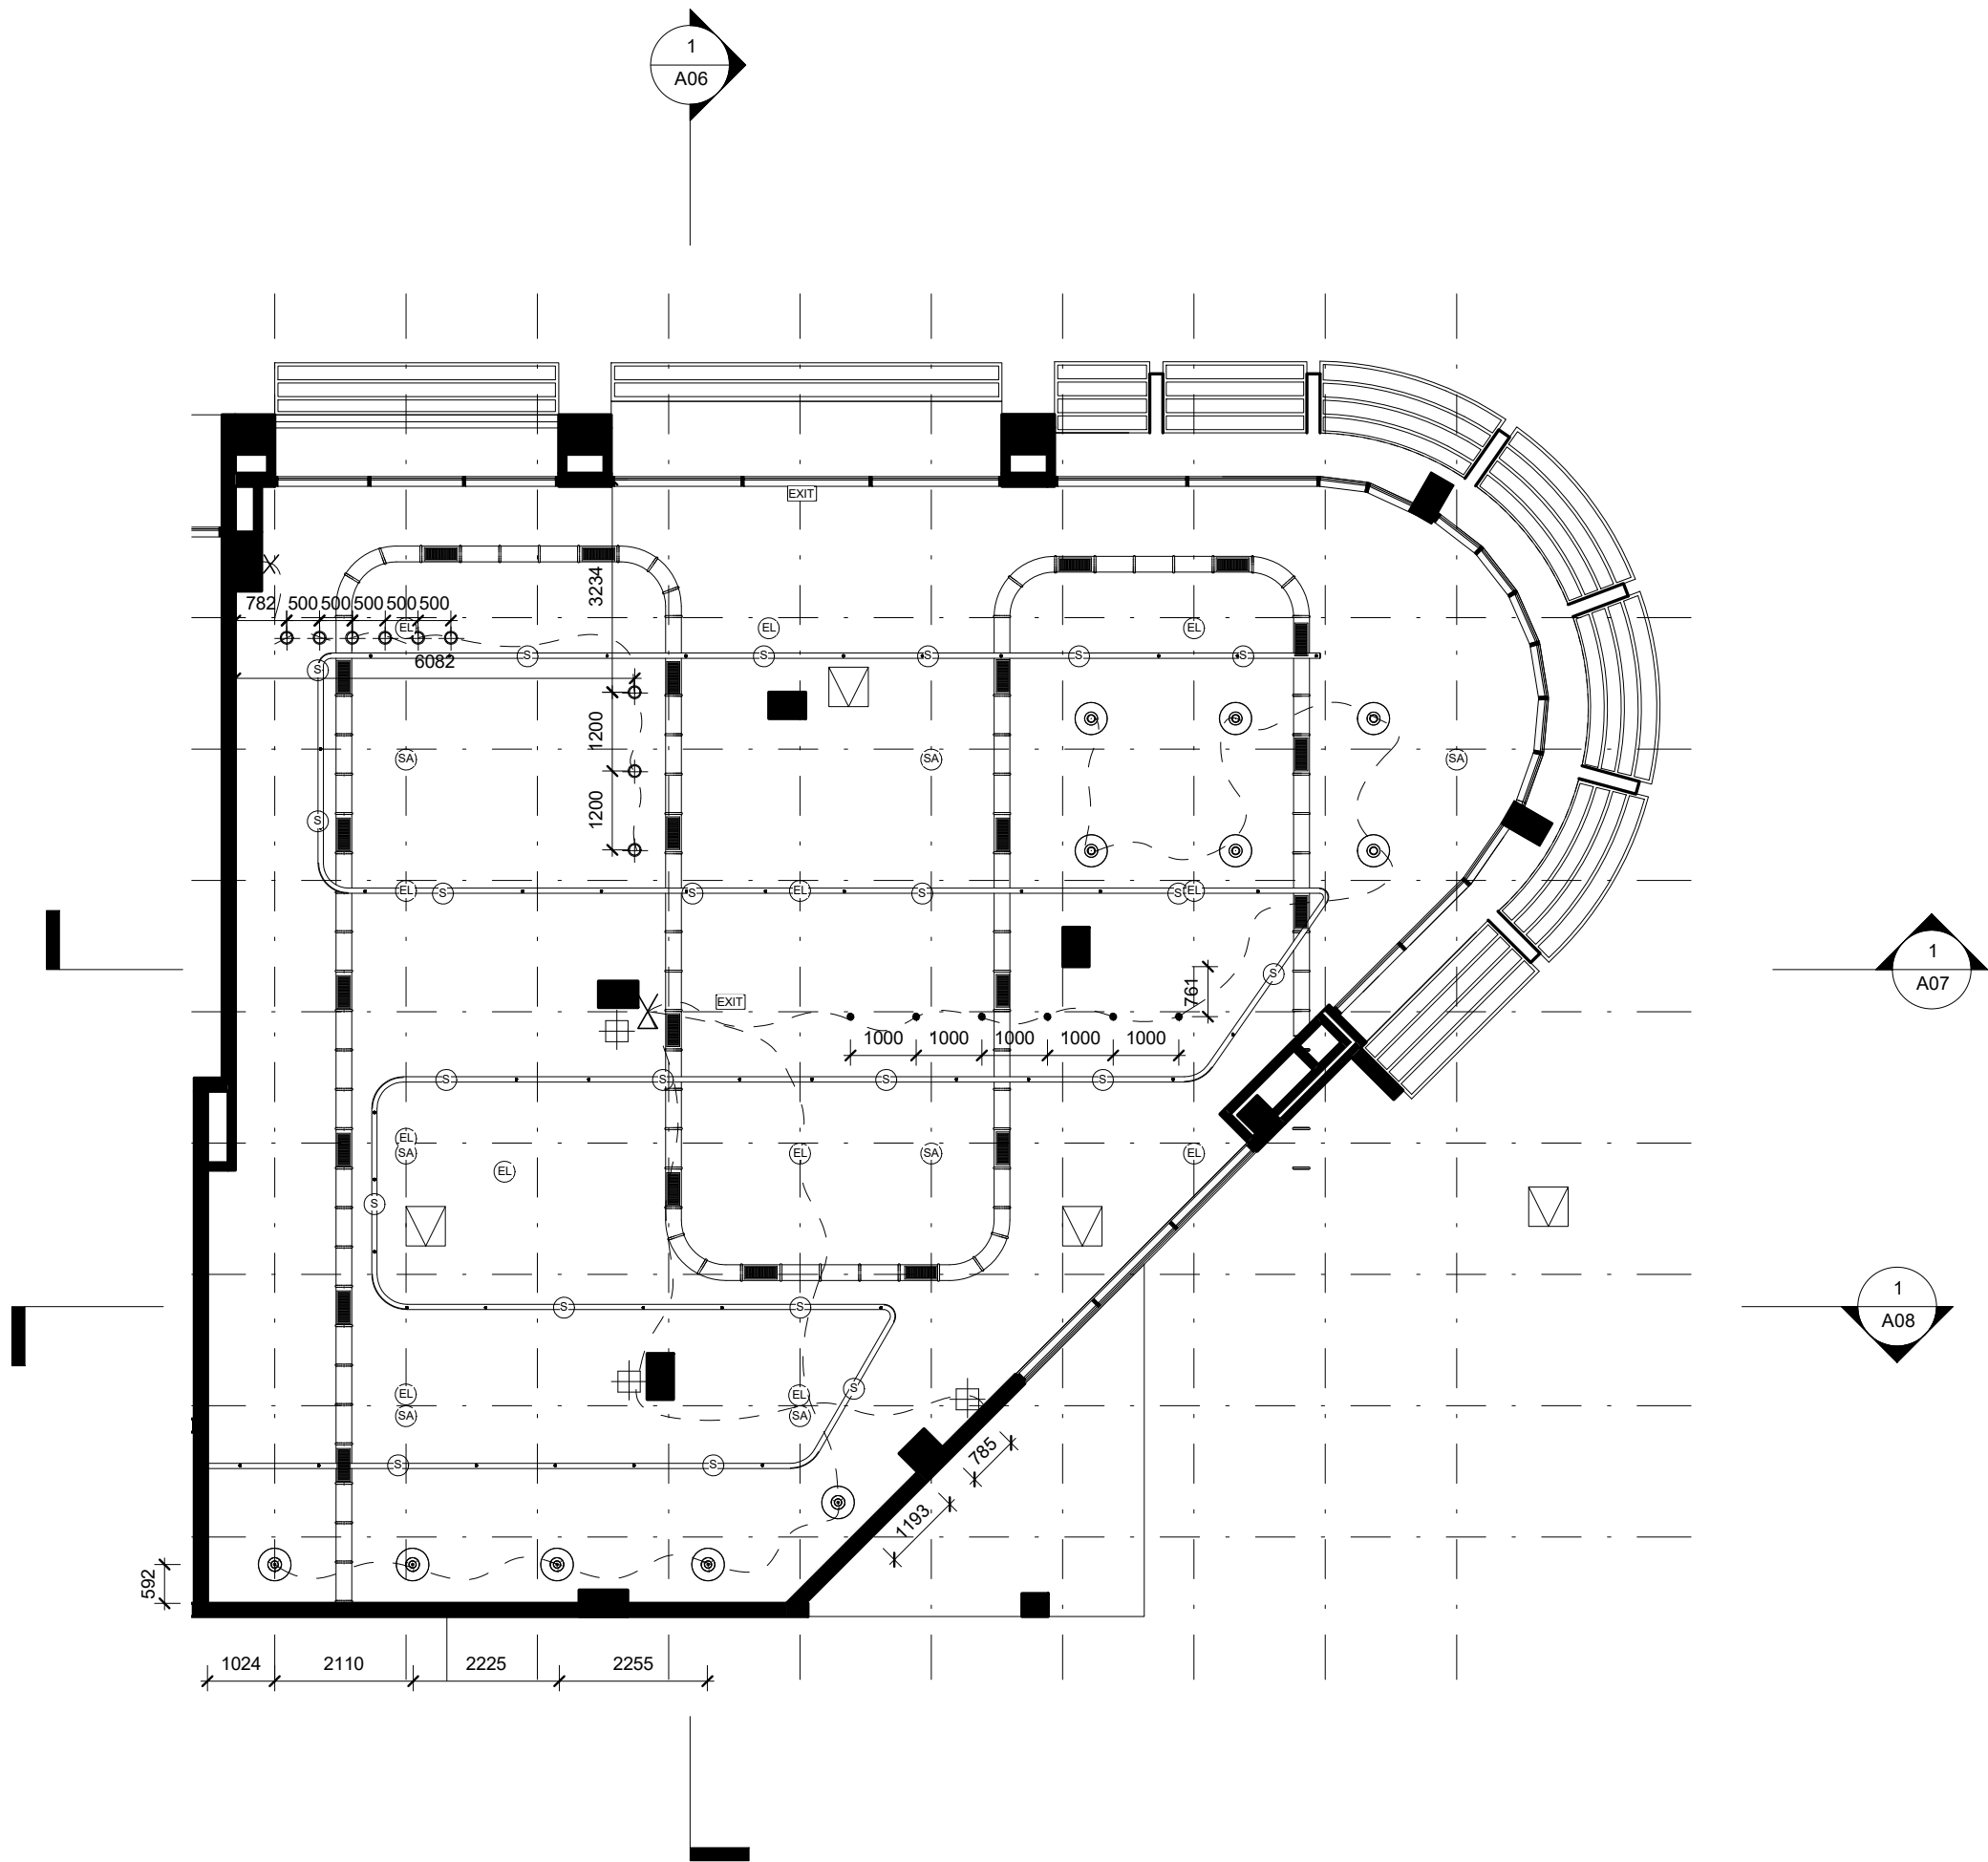

RCP LEGEND

- Pendant Light
- Down Light
- Wall Mounted Light
- Switch
- Two Way Switch
- Wiring
- Grid Line
- Smoke Alarm
- Centreline
- Sprinkler
- Airconditioning Grill in Dropped Ceiling
- Airconditioning Grill Exposed
- 13mm Plaster Board with Rondo Suspended Hooks
- 600x600mm Access Panel
- Exit Sign
- Range Hood
- Ventilation
- Emergency Light
- Exhaust Fan

LEGEND


- CUT PATTERN LEGEND
- | | |
|----------|------------|
| EXISTING | INSULATION |
| CONCRETE | EARTH |
| MDF | TILE |
| TIMBER | STEEL |
| ALUMINUM | |
- ABBREVIATIONS
- | | | | |
|-----|------------------------|----|----------------------|
| FFL | Finished Floor Level | EQ | Specialty Equipment |
| FCL | Finished Ceiling Level | AP | Electrical Equipment |
| SE | Services | SA | Plumbing Fixture |
| MA | Material | LI | Lighting Fixture |
| FU | Furniture | WC | Water Closet |


- WALL TYPES
- | | |
|------|--|
| STW1 | 116mm Dry-Dry Wall
13mm Plaster Board, 90mm Timber Stud
Frame13mm Plaster Board |
| STW2 | 116mm Wet-Dry Wall
13mm Plaster Board, 90mm Timber Stud
Frame13mm Plaster Board, 2mm Glue,
10mm Tile |
| STW3 | 116mm Wet-Wet Wall
10mm Tile, 2mm Glue, 13mm Plaster
Board, 90mm Timber Stud Frame13mm
Plaster Board, 2mm Glue, 10mm Tile |


- DOOR AND WINDOW TAGS
- | | | | |
|----|----------|----|------------|
| D1 | Door Tag | W1 | Window Tag |
|----|----------|----|------------|

Keynote Legend

 NOTES



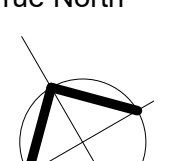Revisions			Do not scale drawings. Use figured dimensions only. Check and verify levels and dimensions on site prior to commencement of any work, the preparation of drawings or the fabrication of components. This drawing is copyright and can not be reproduced without written consent.	Client Sue & Andy Baker 	True North 	Billy Blue College of Design 46-52 Mountain Street, Ultimo, NSW 2007, Australia +61 (0)2 9999 9999    LAUREATE INTERNATIONAL UNIVERSITIES	Project IDC302A Assessment Brief 2 46 Baywater Drive, Wentworth Point, NSW, 2127 Project number Year. 2019	Drawing Title LEVEL TWO RCP Drawing Status PRESENTATION DRAWINGS NOT FOR CONSTRUCTION	Scale	Drawing No	Issue	
No	Date	Description							Ver. App'd	1:100	A05	01
01	17.05.2019	PRESENTATION DRAWINGS							Approver	Date	17.05.2019	Drawn by

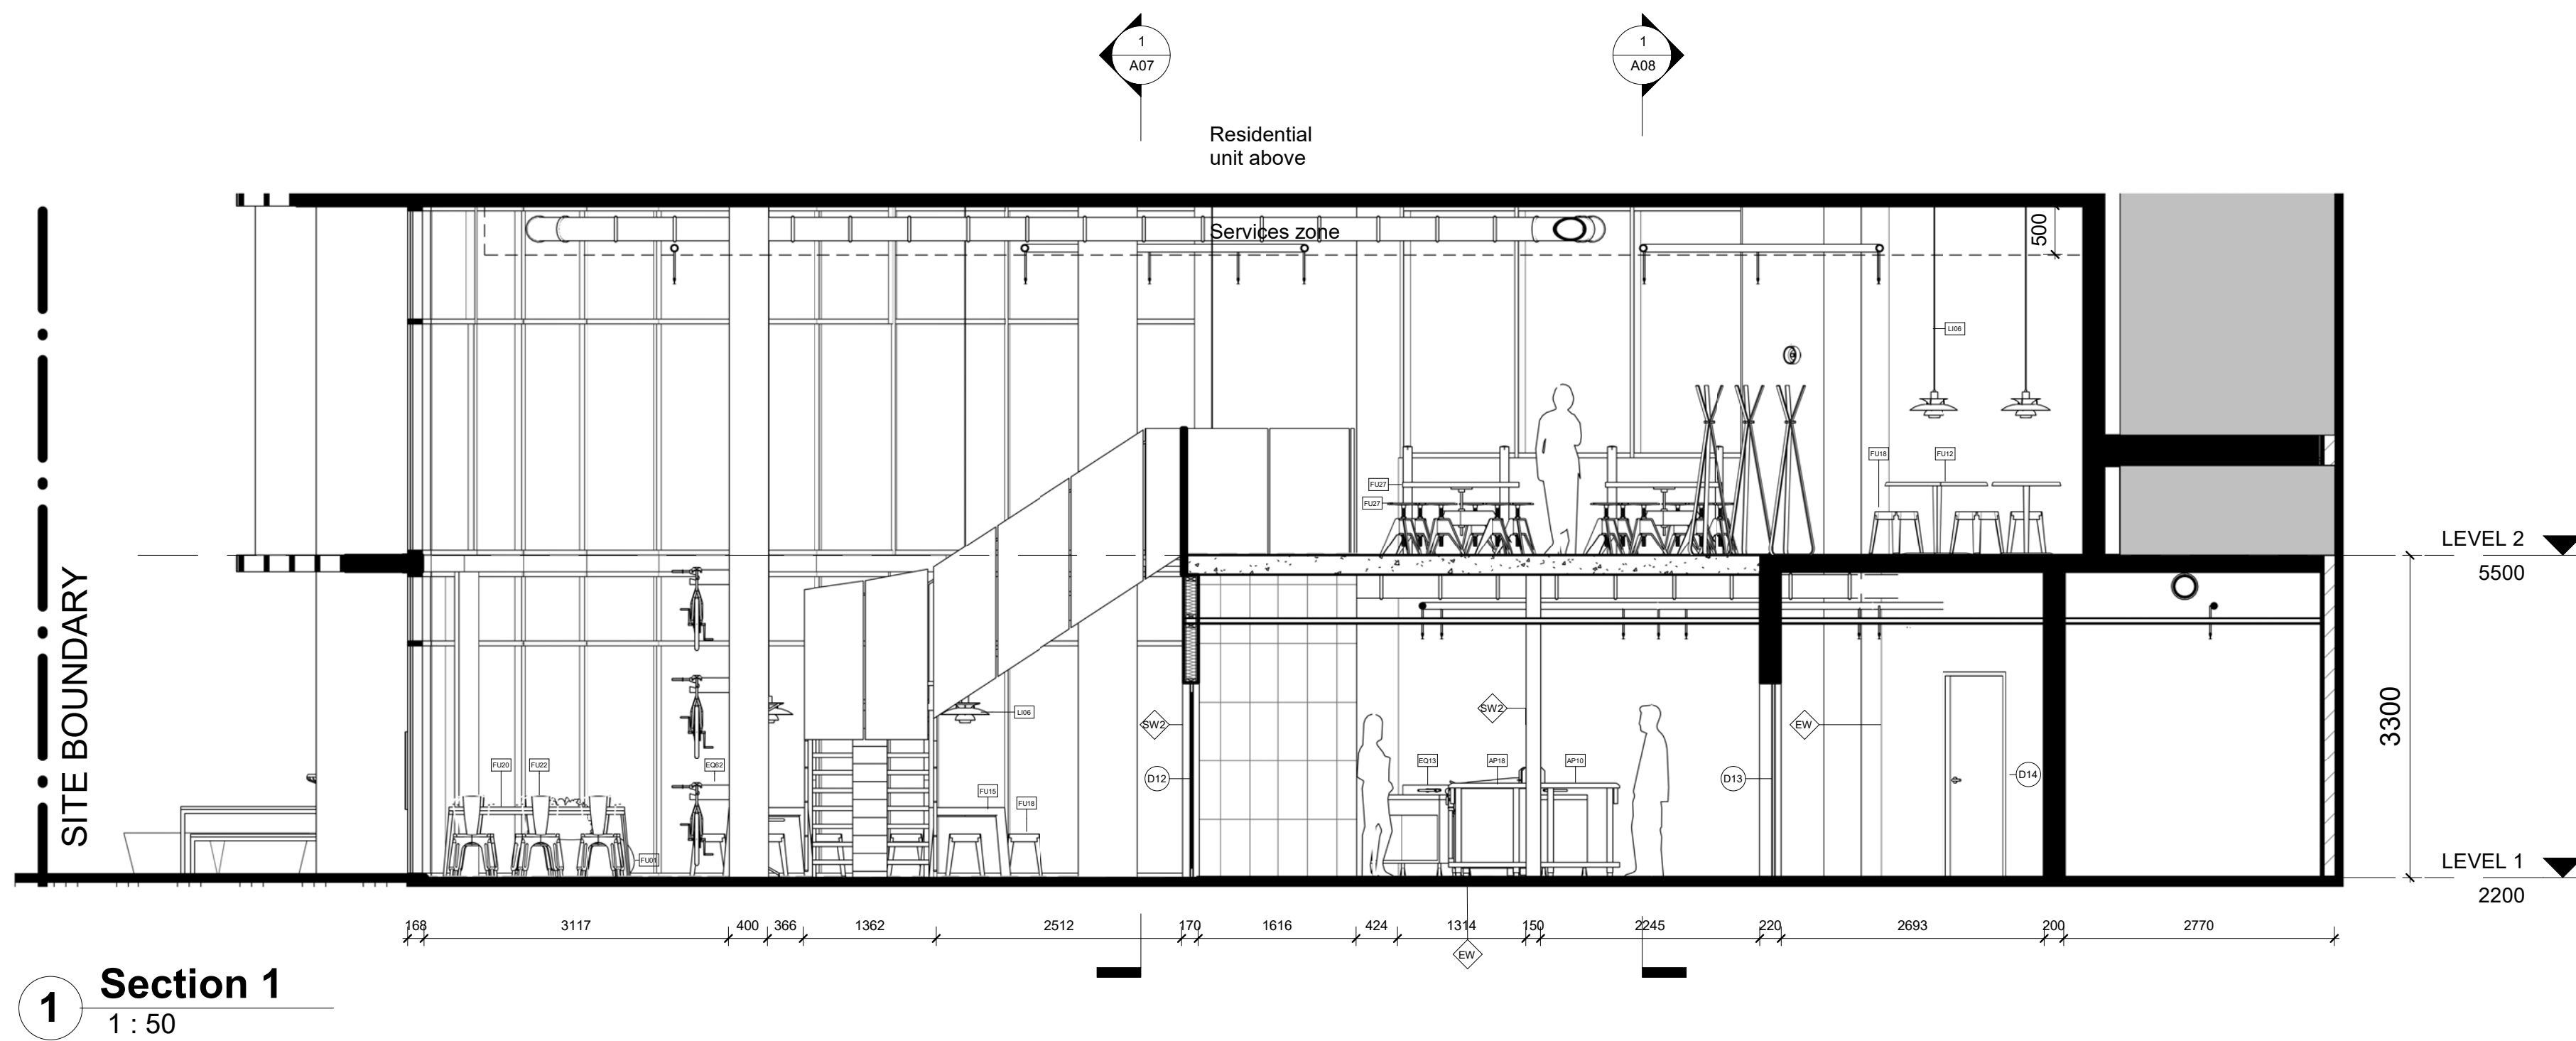


LEGEND			
CUT PATTERN LEGEND			
EXISTING		INSULATION	
CONCRETE		EARTH	
MDF		TILE	
TIMBER		STEEL	
ALUMINUM			
ABBREVIATIONS			
FFL	Finished Floor Level	EQ	Specialty Equipment
FCL	Finished Ceiling Level	AP	Electrical Equipment
SE	Services	SA	Plumbing Fixture
MA	Material	LI	Lighting Fixture
FU	Furniture	WC	Water Closet


WALL TYPES	
STW1	116mm Dry-Dry Wall 13mm Plaster Board, 90mm Timber Stud Frame13mm Plaster Board
STW2	116mm Wet-Dry Wall 13mm Plaster Board, 90mm Timber Stud Frame13mm Plaster Board, 2mm Glue, 10mm Tile
STW3	116mm Wet-Wet Wall 10mm Tile, 2mm Glue, 13mm Plaster Board, 90mm Timber Stud Frame13mm Plaster Board, 2mm Glue, 10mm Tile
DOOR AND WINDOW TAGS	
D1	Door Tag
W1	Window Tag

Keynote Legend	
AP10	Benchtops 900mm BT8900-LS by Waldorf
AP18	1x Gas Fryer FN8120G by Waldorf
EQ13	Double Sink BZ52/100 by IMC
EQ62	Bike holder by A.I.D
FU01	Bidove Planter by BD Barcelona
FU12	TopTop for Dr. Yeas Square Table by Kartell
FU15	1x Solid Table by One Third
FU18	1x Good One Barstool (H750mm) by Tait
FU20	Good One Table by Tait
FU22	tba
FU27	Screw table by Tom Dixon(H=750mm x D=1200mm)
LI06	Pale Rose Pendant PH50 by Louis Poulsen

 NOTES	



Revisions			Client	True North	Project	Drawing Title	Scale	Drawing No	Issue
No	Date	Description							
01	17.05.2019	PRESENTATION DRAWINGS	Ver. App'd Approver	Sue & Andy Baker	Billy Blue College of Design 46-52 Mountain Street, Ultimo, NSW 2007, Australia +61 (0)2 9999 9999	IDC302A Assessment Brief 2 46 Baywater Drive, Wentworth Point, NSW, 2127 Project number Year. 2019	1:50	A06	01
			Do not scale drawings. Use figured dimensions only. Check and verify levels and dimensions on site prior to commencement of any work, the preparation of drawings or the fabrication of components. This drawing is copyright and can not be reproduced without written consent.			PRESENTATION DRAWINGS NOT FOR CONSTRUCTION	Date	17.05.2019	
			Le Velo				Drawn by	PRM	

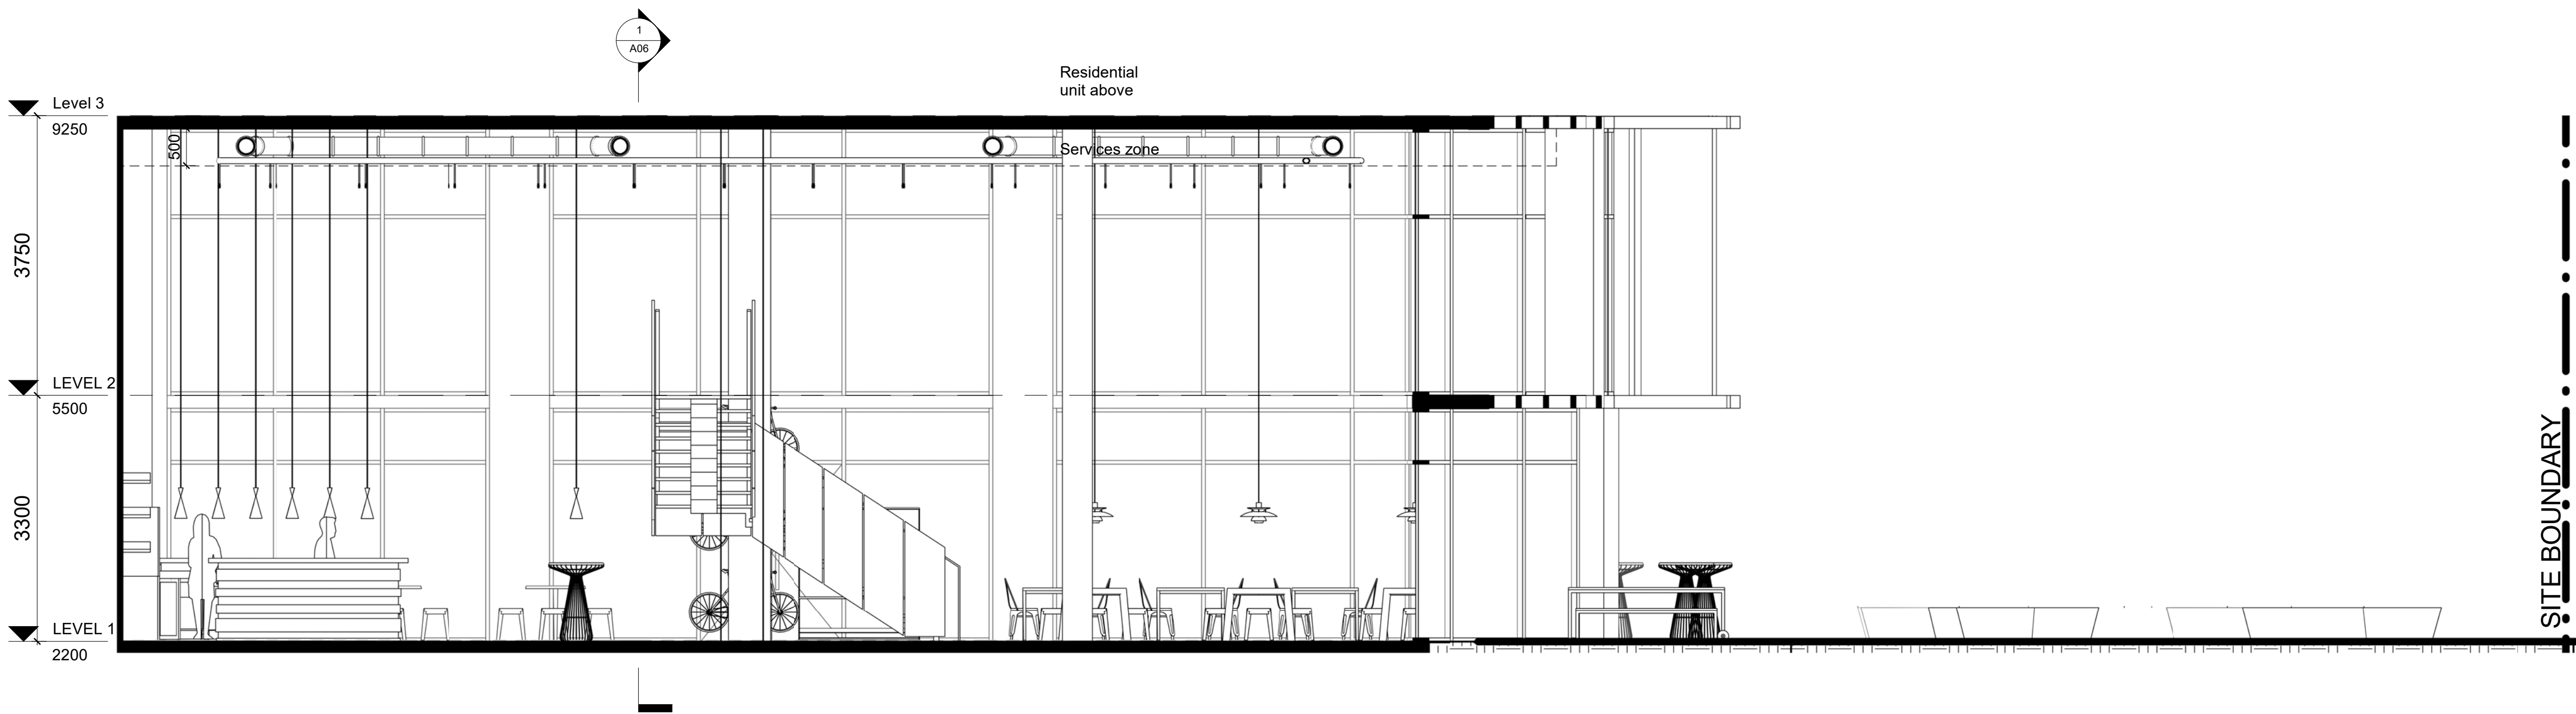

LEGEND

CUT PATTERN LEGEND

EXISTING		INSULATION	
CONCRETE		EARTH	
MDF		TILE	
TIMBER		STEEL	
ALUMINUM			

ABBREVIATIONS

FFL	Finished Floor Level	EQ	Specialty Equipment
FCL	Finished Ceiling Level	AP	Electrical Equipment
SE	Services	SA	Plumbing Fixture
MA	Material	LI	Lighting Fixture
FU	Furniture	WC	Water Closet

WALL TYPES


STW1	116mm Dry-Dry Wall 13mm Plaster Board, 90mm Timber Stud Frame 13mm Plaster Board
STW2	116mm Wet-Dry Wall 13mm Plaster Board, 90mm Timber Stud Frame 13mm Plaster Board, 2mm Glue, 10mm Tile
STW3	116mm Wet-Wet Wall 10mm Tile, 2mm Glue, 13mm Plaster Board, 90mm Timber Stud Frame 13mm Plaster Board, 2mm Glue, 10mm Tile

DOOR AND WINDOW TAGS

D1	Door Tag	W1	Window Tag
----	----------	----	------------

Keynote Legend

 NOTES




1 Section 2

1 : 50

Revisions			Do not scale drawings. Use figured dimensions only. Check and verify levels and dimensions on site prior to commencement of any work, the preparation of drawings or the fabrication of components. This drawing is copyright and can not be reproduced without written consent.	Client Sue & Andy Baker 	True North	Billy Blue College of Design 46-52 Mountain Street, Ultimo, NSW 2007, Australia +61 (0)2 9999 9999 	Project IDC302A Assessment Brief 2 46 Baywater Drive, Wentworth Point, NSW, 2127 Project number Year. 2019	Drawing Title SECTION TWO Drawing Status PRESENTATION DRAWINGS NOT FOR CONSTRUCTION	Scale	Drawing No	Issue
No	Date	Description							1:50	A07	01
01	17.05.2019	PRESENTATION DRAWINGS							Date	17.05.2019	
									Drawn by	PRM	

SITE BOUNDARY

1 Section 3
1 : 50

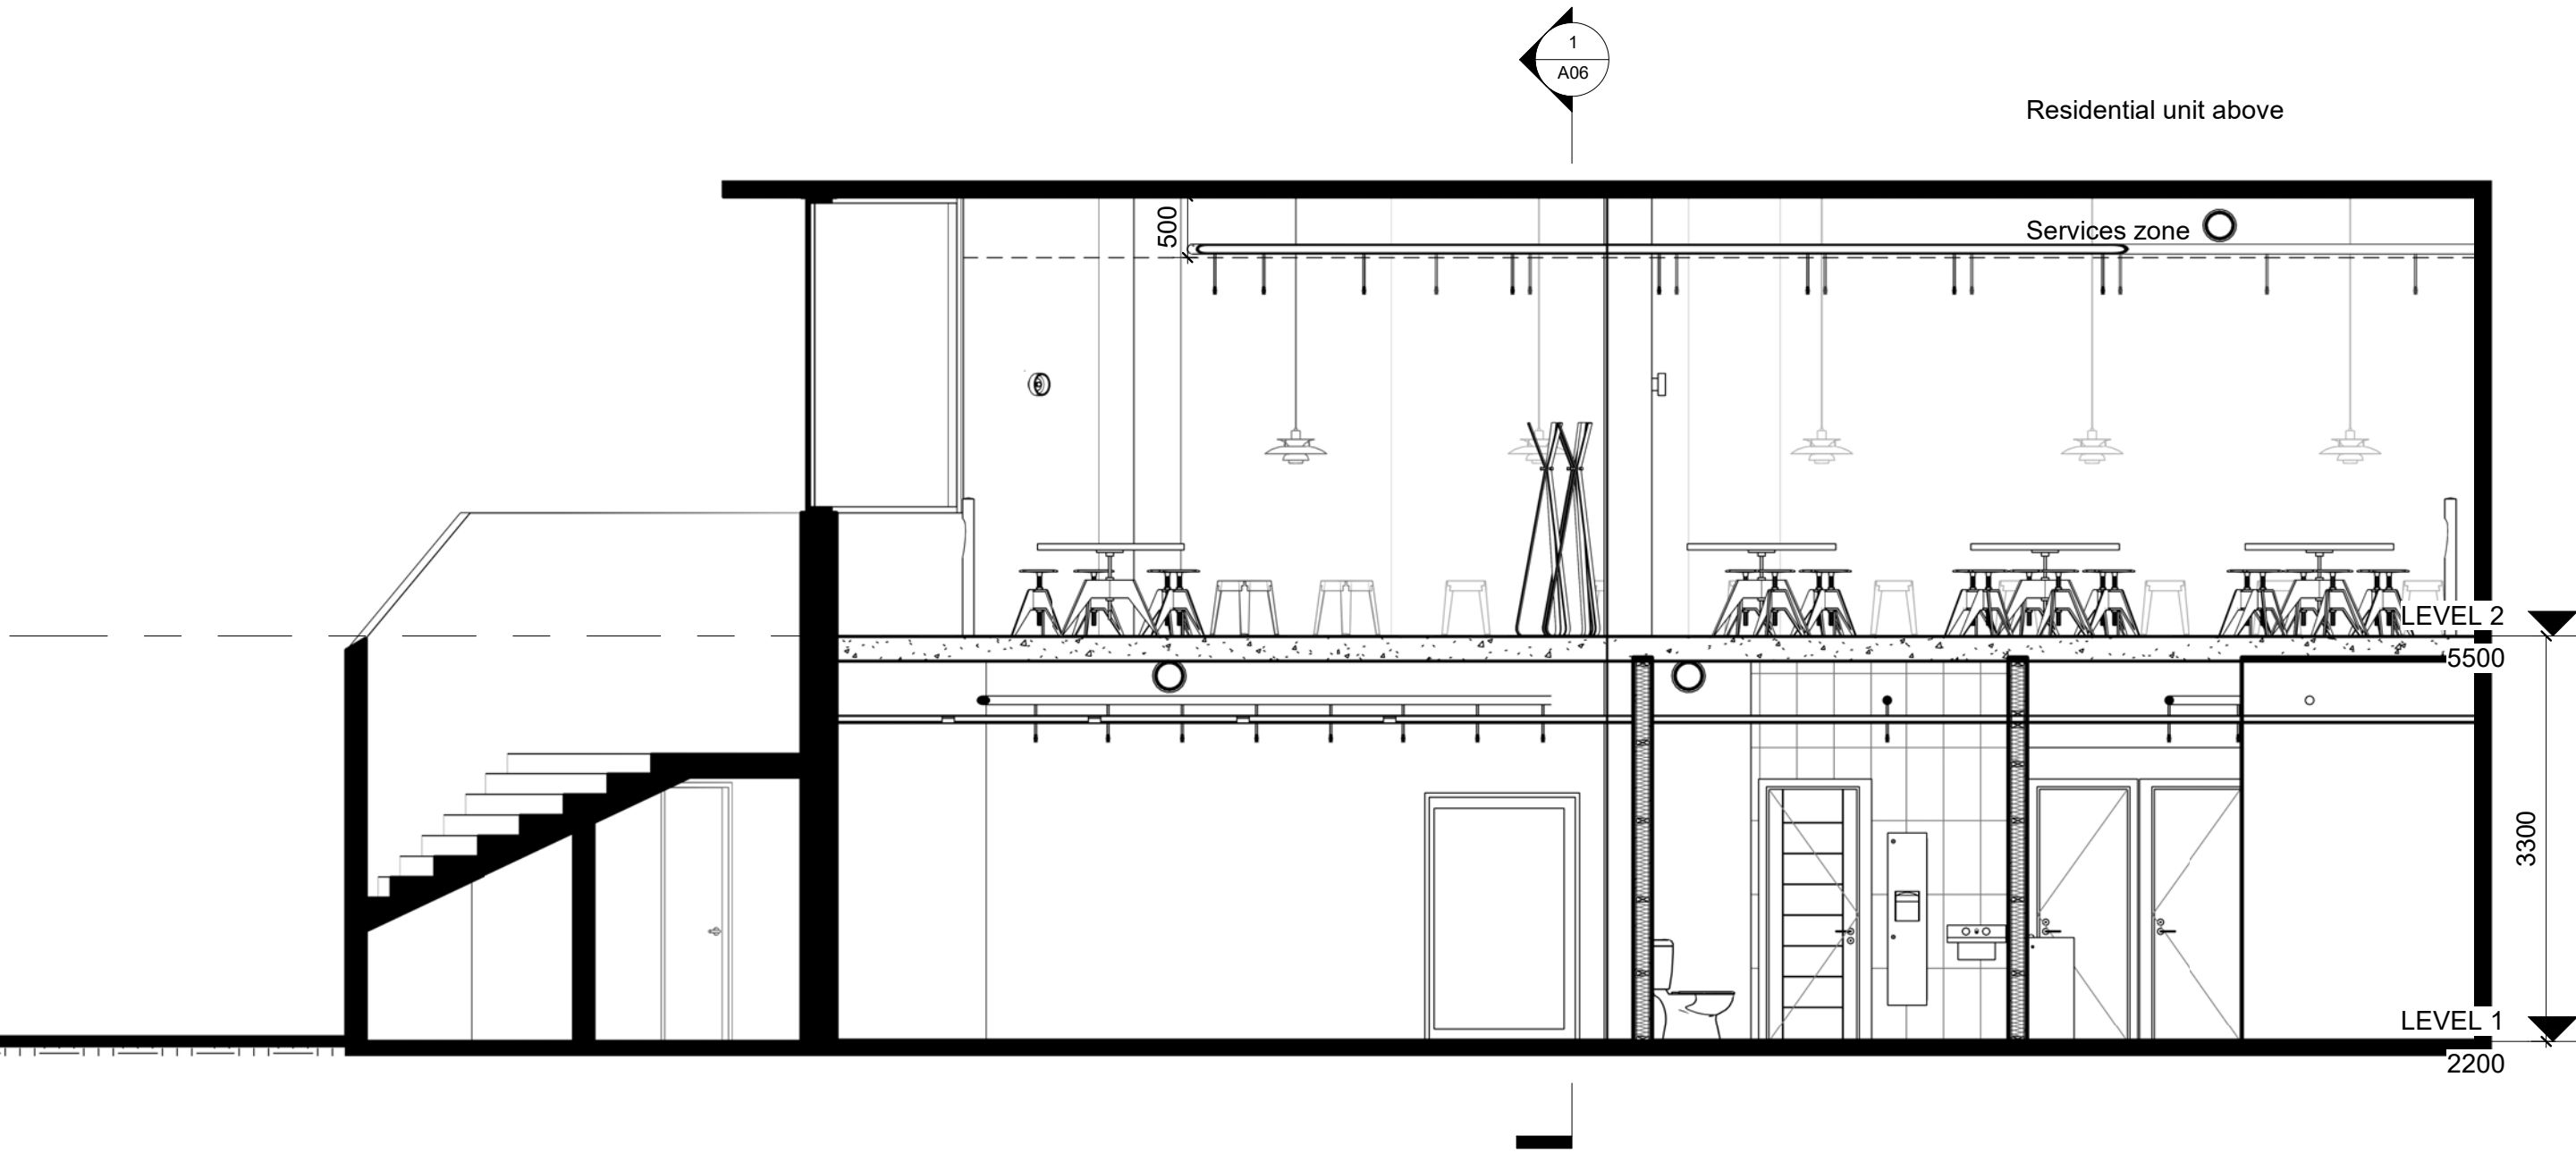

LEGEND

CUT PATTERN LEGEND

EXISTING		INSULATION	
CONCRETE		EARTH	
MDF		TILE	
TIMBER		STEEL	
ALUMINUM			

ABBREVIATIONS

FFL	Finished Floor Level	EQ	Specialty Equipment
FCL	Finished Ceiling Level	AP	Electrical Equipment
SE	Services	SA	Plumbing Fixture
MA	Material	LI	Lighting Fixture
FU	Furniture	WC	Water Closet

WALL TYPES


STW1	116mm Dry-Dry Wall 13mm Plaster Board, 90mm Timber Stud Frame 13mm Plaster Board
STW2	116mm Wet-Dry Wall 13mm Plaster Board, 90mm Timber Stud Frame 13mm Plaster Board, 2mm Glue, 10mm Tile
STW3	116mm Wet-Wet Wall 10mm Tile, 2mm Glue, 13mm Plaster Board, 90mm Timber Stud Frame 13mm Plaster Board, 2mm Glue, 10mm Tile

DOOR AND WINDOW TAGS

D1	Door Tag	W1	Window Tag
----	----------	----	------------

Keynote Legend

 NOTES



Revisions			Do not scale drawings. Use figured dimensions only. Check and verify levels and dimensions on site prior to commencement of any work, the preparation of drawings or the fabrication of components. This drawing is copyright and can not be reproduced without written consent.	Client Sue & Andy Baker 	True North	 BILLY BLUE COLLEGE OF DESIGN  TORRENS UNIVERSITY AUSTRALIA  LAUREATE INTERNATIONAL UNIVERSITIES	Project IDC302A Assessment Brief 2 46 Baywater Drive, Wentworth Point, NSW, 2127 Project number Year. 2019	Drawing Title SECTION THREE Drawing Status PRESENTATION DRAWINGS NOT FOR CONSTRUCTION	Scale	Drawing No	Issue	
No	Date	Description							Ver. App'd	1:50	A08	01
01	17.05.2019	PRESENTATION DRAWINGS							Approver	Date	17.05.2019	
										Drawn by	PRM	

1 BAR Detail Plan
1 : 20

2 BAR Elevation 1
1 : 20

LEGEND

CUT PATTERN LEGEND

EXISTING		INSULATION	
CONCRETE		EARTH	
MDF		TILE	
TIMBER		STEEL	
ALUMINUM			

ABBREVIATIONS

FFL	Finished Floor Level	EQ	Specialty Equipment
FCL	Finished Ceiling Level	AP	Electrical Equipment
SE	Services	SA	Plumbing Fixture
MA	Material	LI	Lighting Fixture
FU	Furniture	WC	Water Closet

WALL TYPES

STW1	116mm Dry-Dry Wall 13mm Plaster Board, 90mm Timber Stud Frame 13mm Plaster Board
STW2	116mm Wet-Dry Wall 13mm Plaster Board, 90mm Timber Stud Frame 13mm Plaster Board, 2mm Glue, 10mm Tile
STW3	116mm Wet-Wet Wall 10mm Tile, 2mm Glue, 13mm Plaster Board, 90mm Timber Stud Frame 13mm Plaster Board, 2mm Glue, 10mm Tile


DOOR AND WINDOW TAGS

D1	Door Tag	W1	Window Tag
----	----------	----	------------

Keynote Legend

AP01 Refrigeration module B16/704S by IMC
AP02 1x Glass Door add-on module B16/700S by IMC
AP05 1x Wire Chiller add-on module B16/703S
AP06 Mirage Tall single hinged door TC60 by IMC
AP07 Premium Glasswasher and Light Duty Dishwasher GM by Washtech
AP10 Benchtops 900mm BT8900-LS by Waldorf
EQ02 Ice Chest with covers BZ54/060 by IMC
EQ07 Perforated Workshop BZ59/100 by IMC
EQ11 Basket Rack with telescopic Slides BZ23/055 by IMC
EQ12 Single Sink BZ51/100 by IMC
EQ14 Worktop Unit BZ50/060 by IMC
EQ16 Tilt Unit BZ67/055 by IMC
EQ21 Leg Frame BB02/208 by IMC
EQ23 Corner Top BZ17/051 by IMC
EQ29 Painted Steel Bar support BB70/001 by IMC
LI01 Beat flat tall pendant by Tom Dixon
MA01 Tile Floor

 NOTES



Revisions		
No	Date	Description
01	17.05.2019	PRESENTATION DRAWINGS

Do not scale drawings. Use figured dimensions only. Check and verify levels and dimensions on site prior to commencement of any work, the preparation of drawings or the fabrication of components.
This drawing is copyright and can not be reproduced without written consent.

Client
Sue & Andy Baker

Le Velo

True North

Billy Blue College of Design
46-52 Mountain Street, Ultimo, NSW 2007, Australia
+61 (0)2 9999 9999




Project
IDC302A Assessment Brief 2
46 Baywater Drive, Wentworth Point, NSW, 2127
Project number
Year. 2019


Drawing Title
BAR DETAIL PLAN & BAR ELEVATIONS 1
Drawing Status
PRESENTATION DRAWINGS
NOT FOR CONSTRUCTION

Scale
1:20
Drawing No
A09
Issue
01
Date
17.05.2019
Drawn by
PRM

10/05/2019 8:06:55 AM

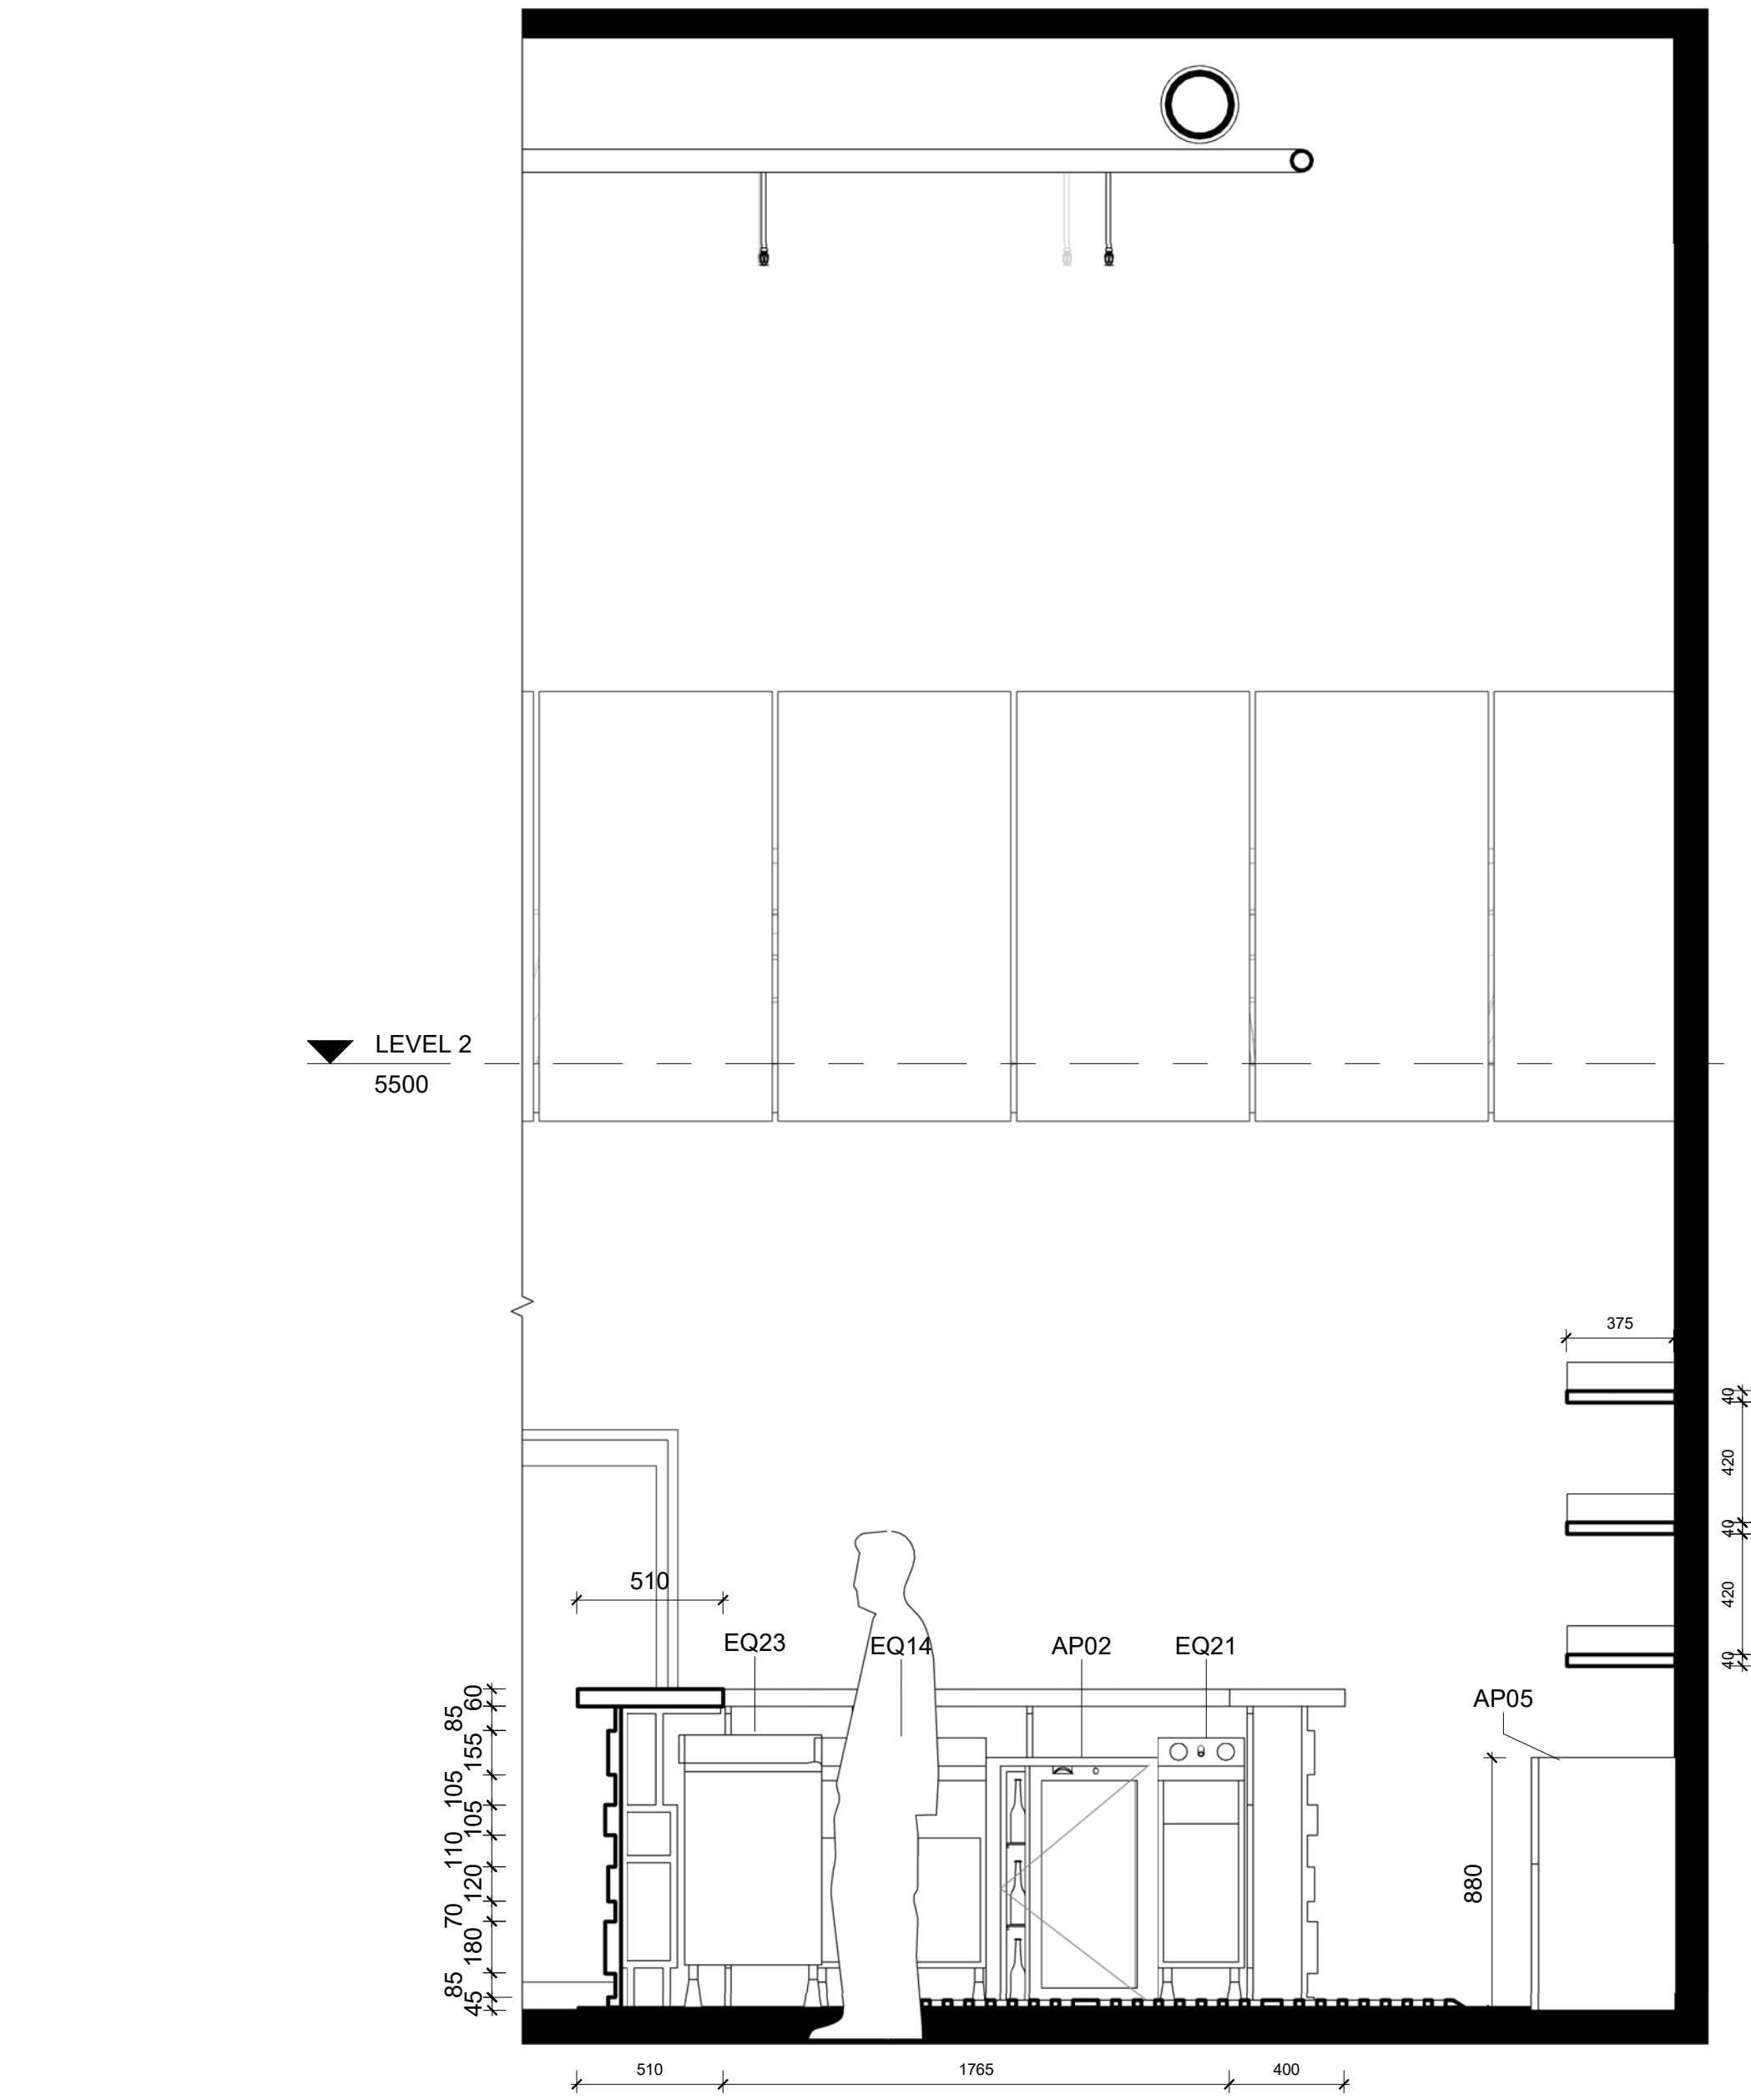

1 BAR Elevation 2
1 : 20

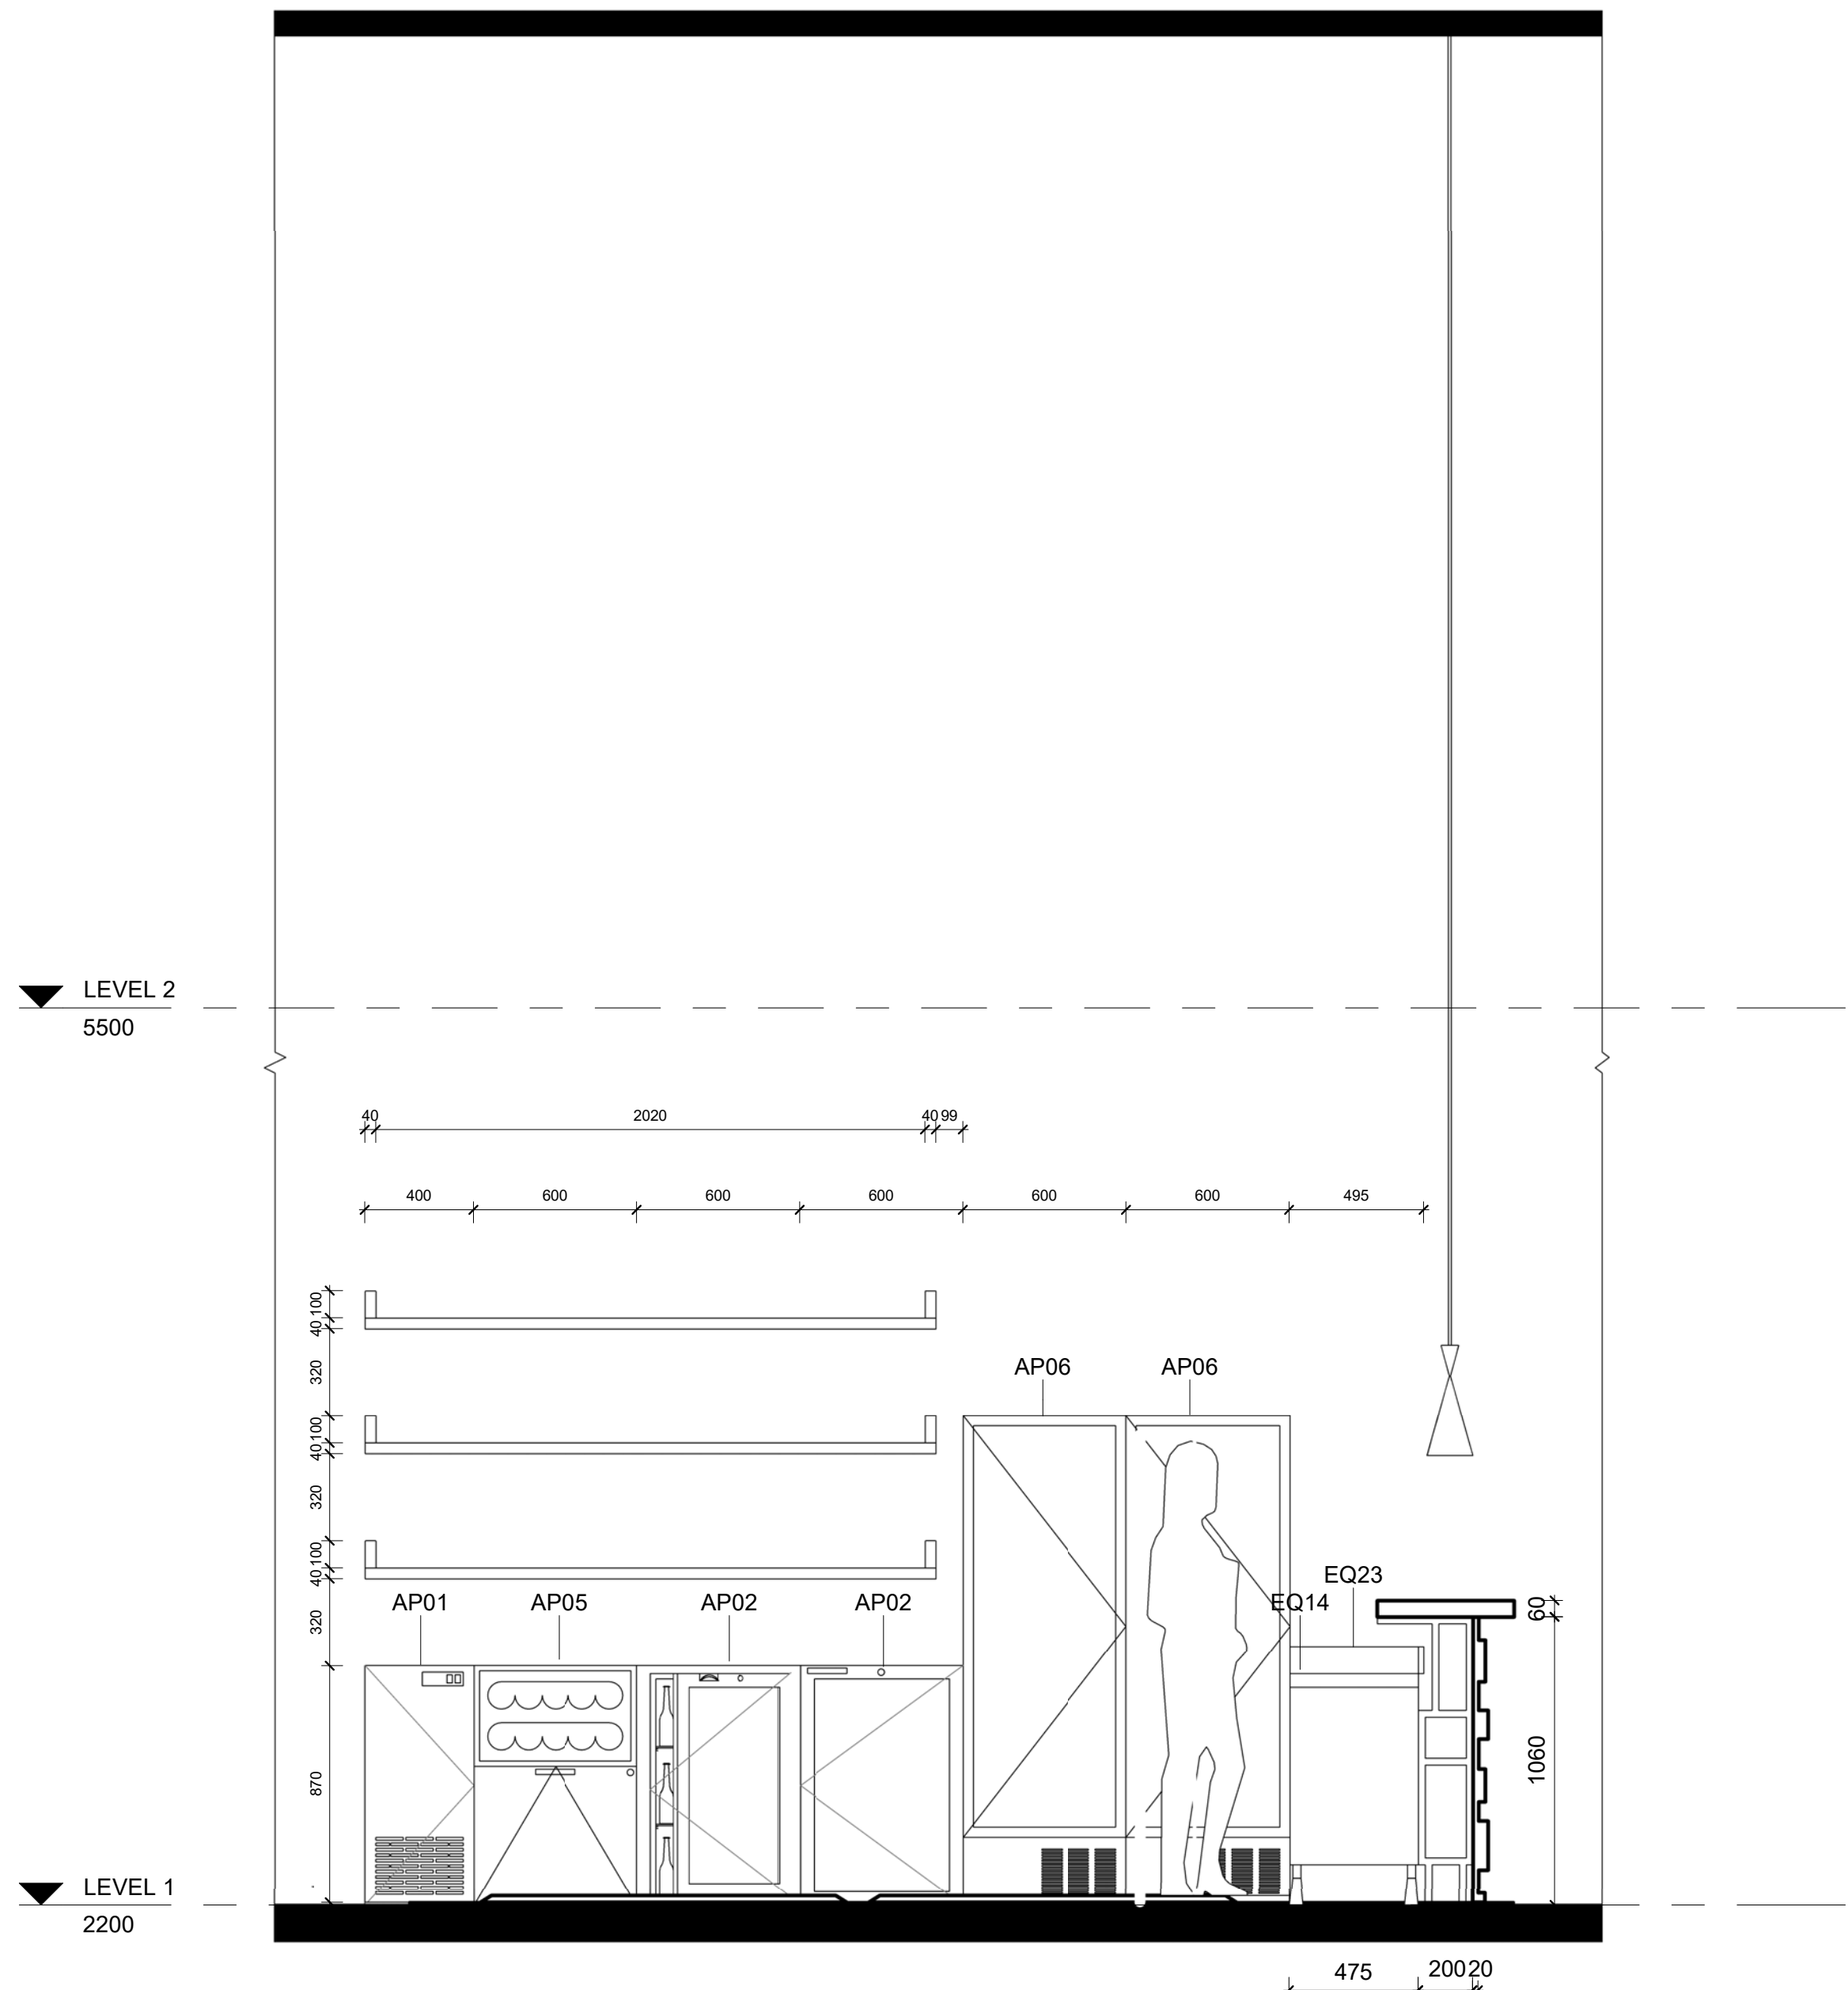

2 BAR Elevation 3
1 : 20

LEGEND

CUT PATTERN LEGEND

EXISTING	INSULATION
CONCRETE	EARTH
MDF	TILE
TIMBER	STEEL
ALUMINUM	

ABBREVIATIONS

FFL	Finished Floor Level	EQ	Specialty Equipment
FCL	Finished Ceiling Level	AP	Electrical Equipment
SE	Services	SA	Plumbing Fixture
MA	Material	LI	Lighting Fixture
FU	Furniture	WC	Water Closet

WALL TYPES

STW1	116mm Dry-Dry Wall 13mm Plaster Board, 90mm Timber Stud Frame13mm Plaster Board
STW2	116mm Wet-Dry Wall 13mm Plaster Board, 90mm Timber Stud Frame13mm Plaster Board, 2mm Glue, 10mm Tile
STW3	116mm Wet-Wet Wall 10mm Tile, 2mm Glue, 13mm Plaster Board, 90mm Timber Stud Frame13mm Plaster Board, 2mm Glue, 10mm Tile

DOOR AND WINDOW TAGS


D1	Door Tag	W1	Window Tag
----	----------	----	------------

Keynote Legend


AP01 Refrigeration module B16/704S by IMC
AP02 1x Glass Door add-on module B16/700S by IMC
AP05 1x Wine Chiller add-on module B16/703S by IMC
AP06 Mirage Tall single hinged door TC60 by IMC
EQ14 Worktop Unit BZ50/060 by IMC
EQ21 Leg Frame BB02/208 by IMC
EQ23 Corner Top BZ17/051 by IMC

NOTES

Revisions			Client	True North	Project	Drawing Title	Scale	Drawing No	Issue
No	Date	Description							
01	17.05.2019	PRESENTATION DRAWINGS	Sue & Andy Baker		IDC302A Assessment Brief 2	BAR ELEVATIONS 2 & 3	1:20	A10	01
			Le Velo		46 Baywater Drive, Wentworth Point, NSW, 2127		Date	17.05.2019	
					Project number	Drawing Status	Drawn by	PRM	
					Year. 2019	PRESENTATION DRAWINGS NOT FOR CONSTRUCTION			

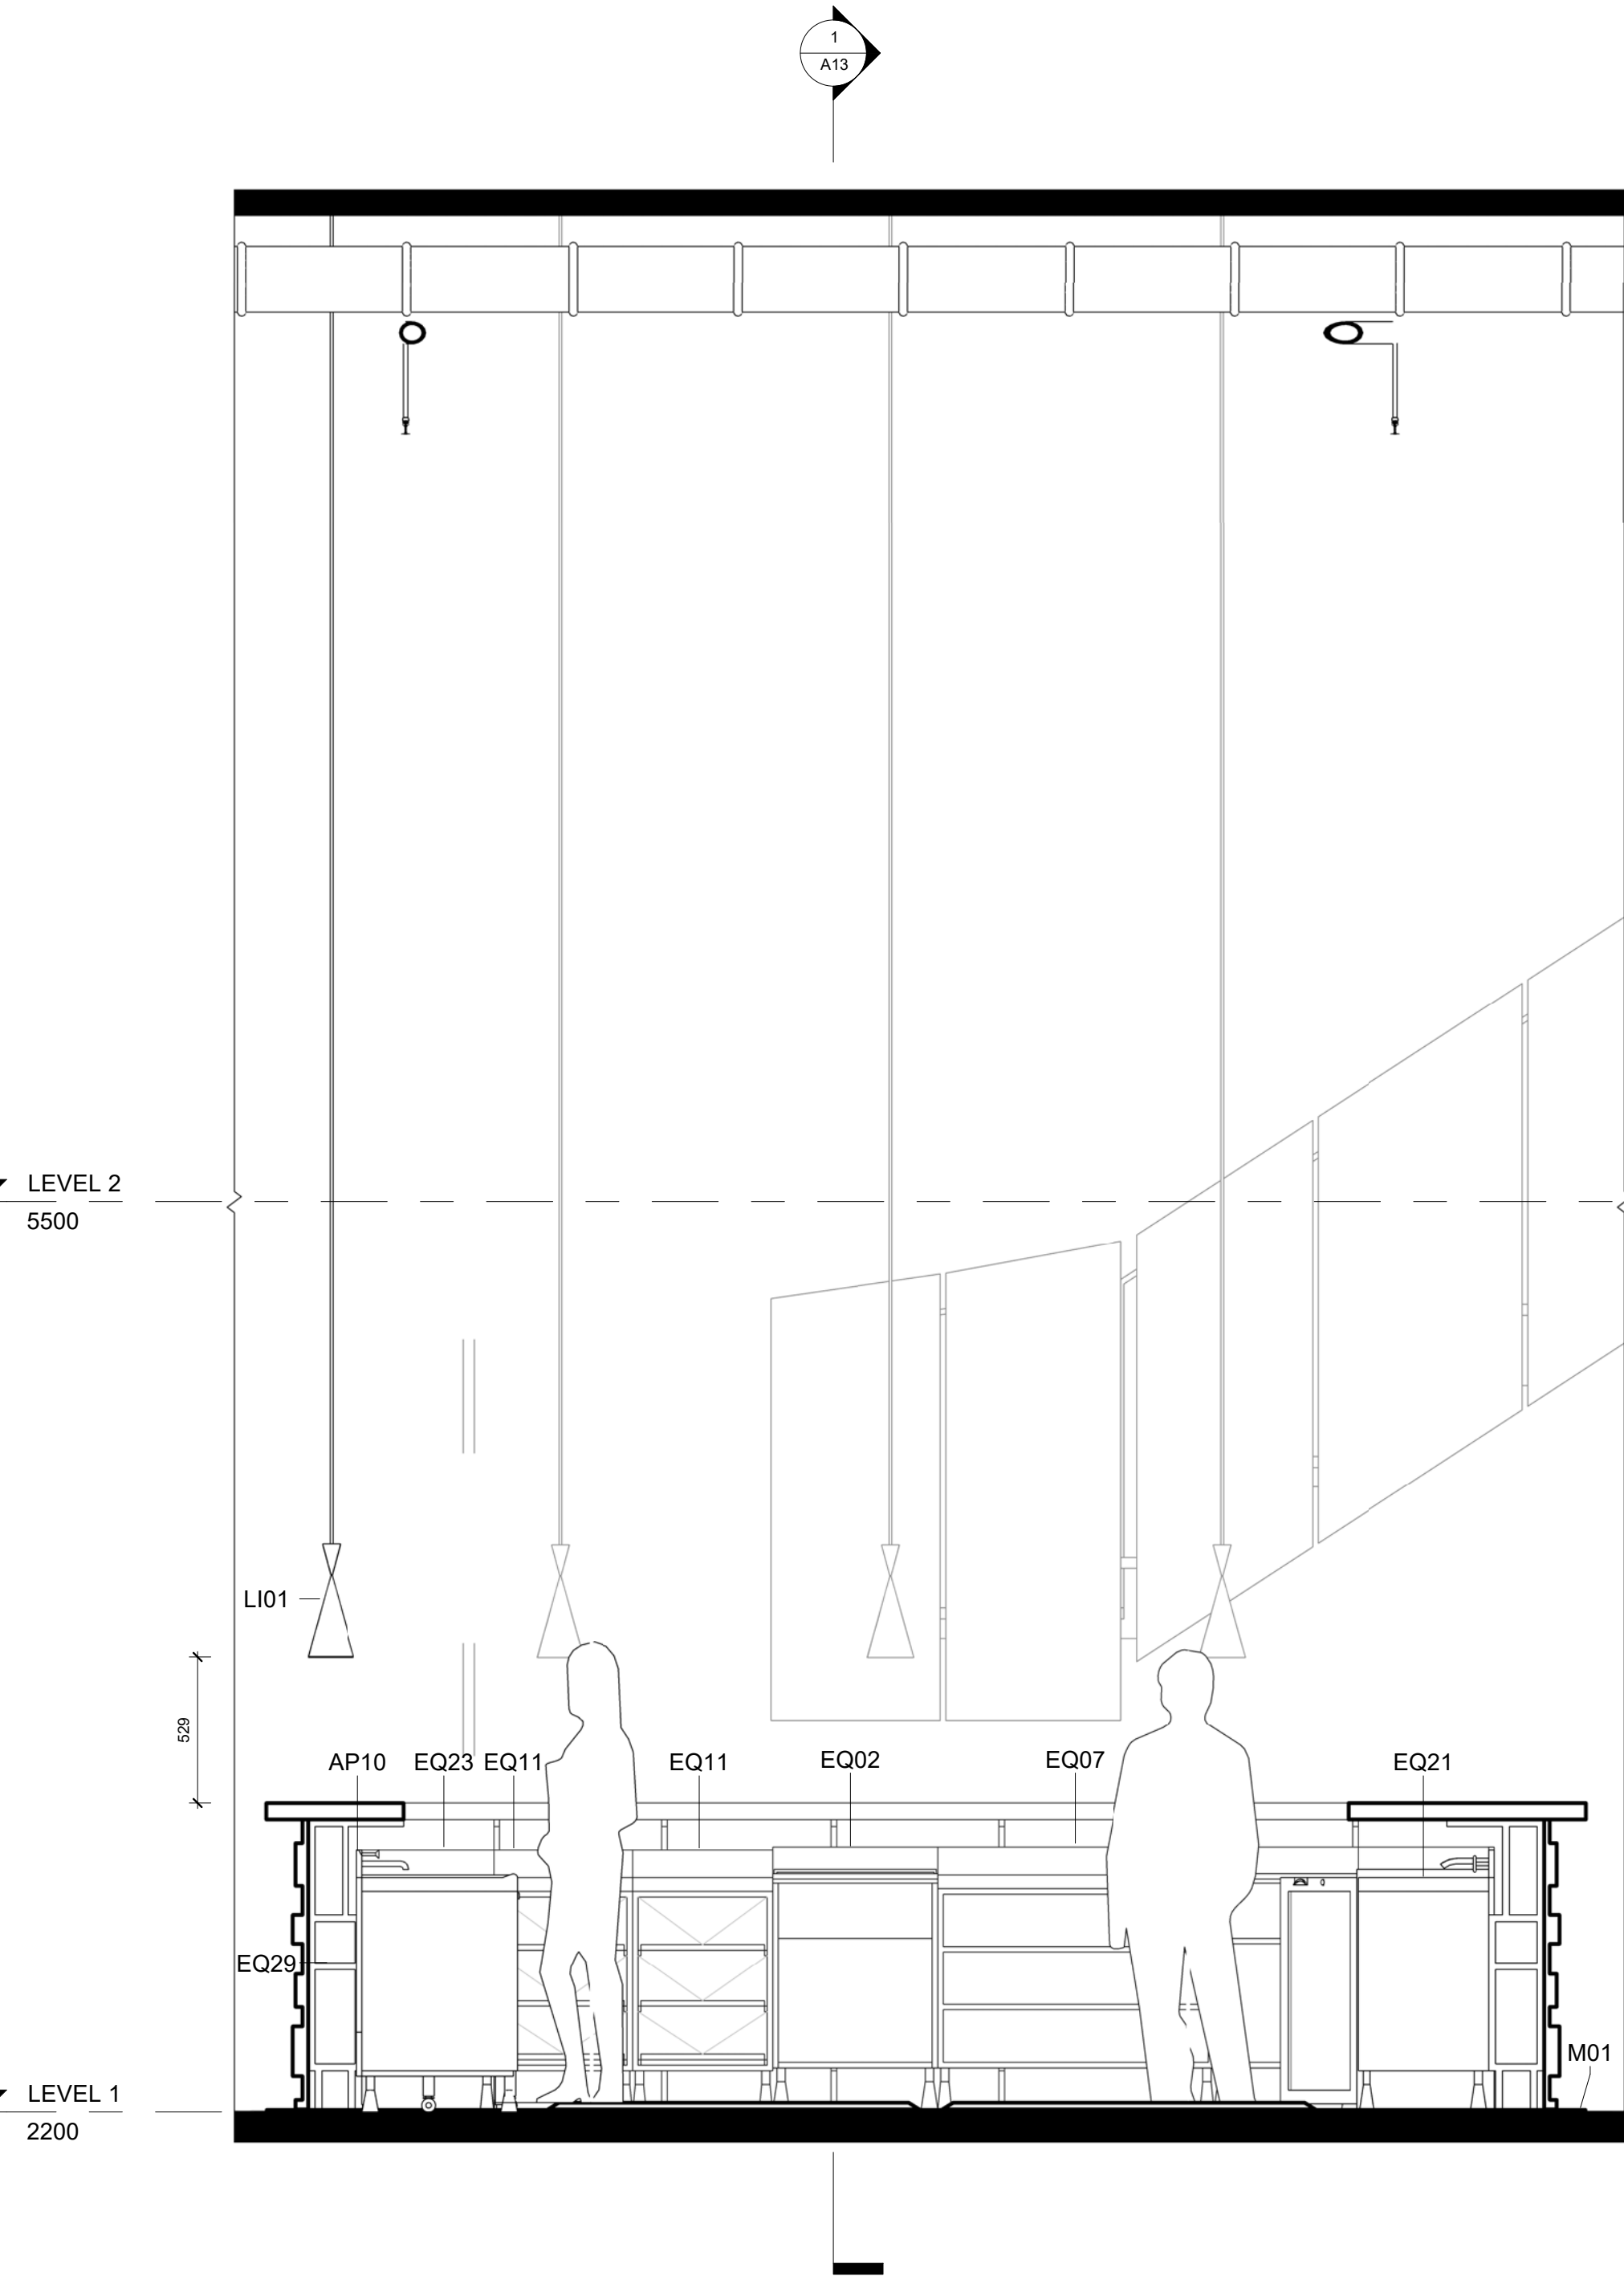

1 BAR Elevation 4
1 : 20

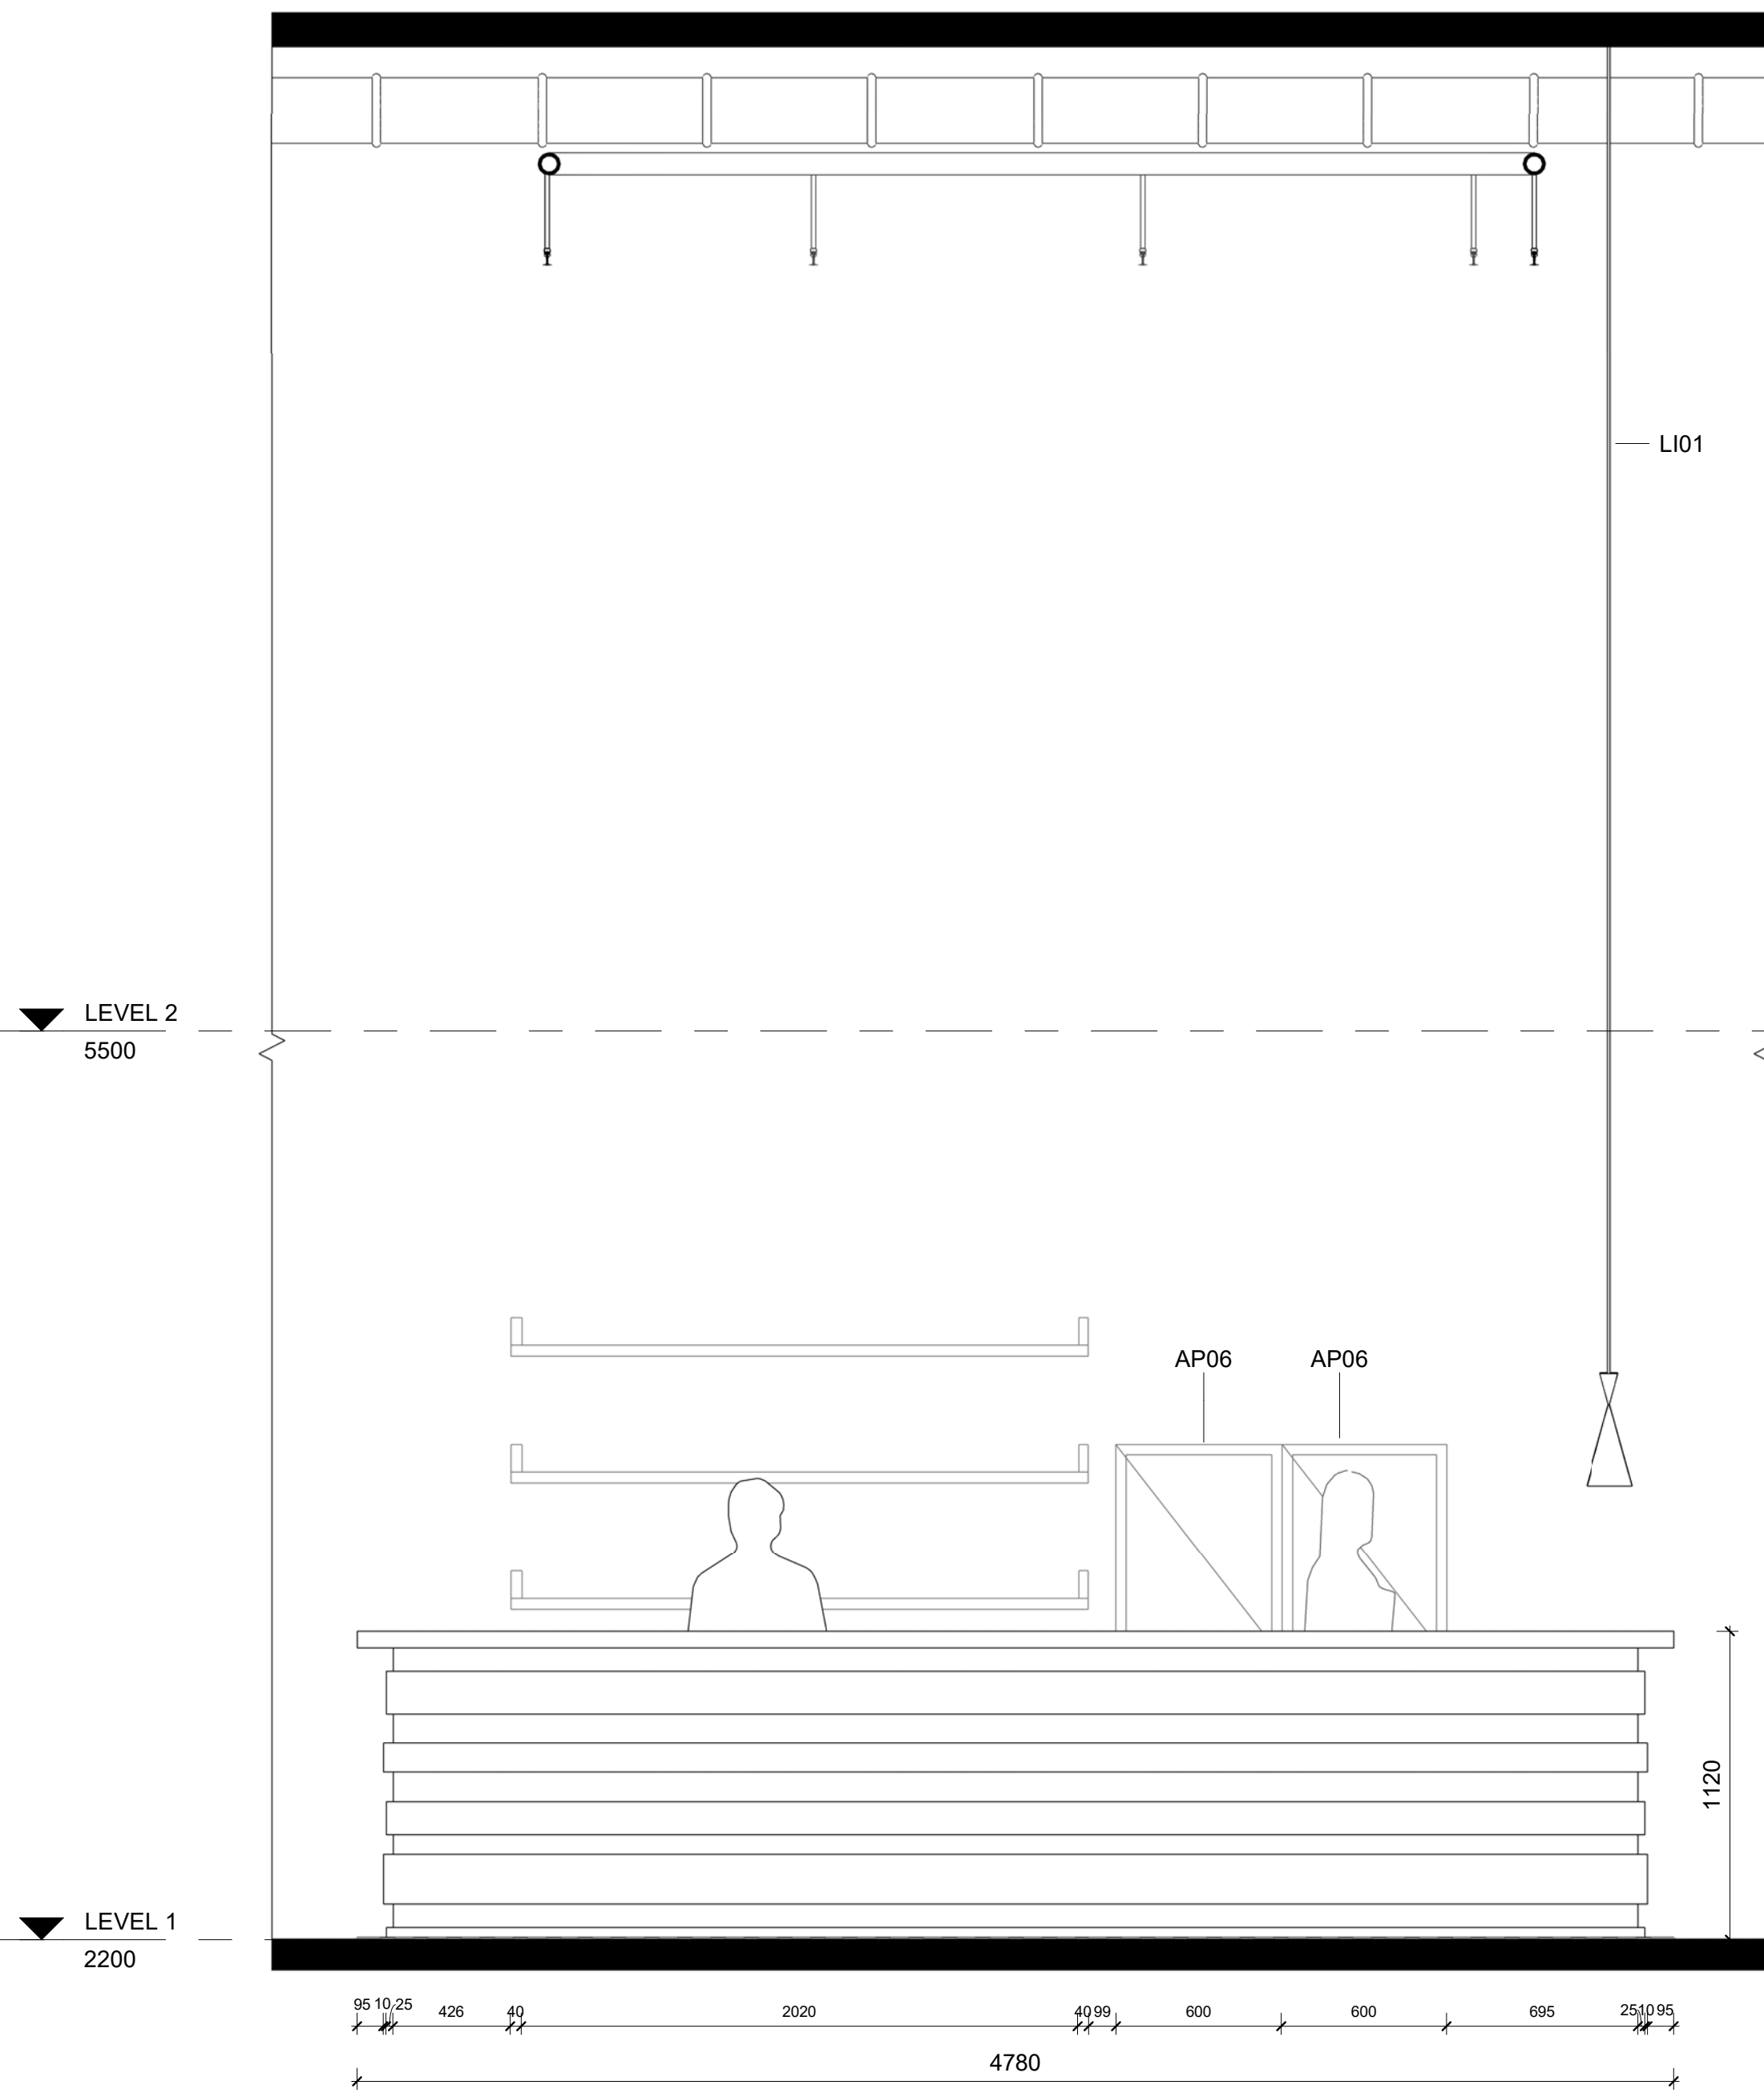

2 BAR Elevation 5
1 : 20

LEGEND

CUT PATTERN LEGEND

EXISTING	INSULATION
CONCRETE	EARTH
MDF	TILE
TIMBER	STEEL
ALUMINUM	

ABBREVIATIONS

FFL	Finished Floor Level	EQ	Specialty Equipment
FCL	Finished Ceiling Level	AP	Electrical Equipment
SE	Services	SA	Plumbing Fixture
MA	Material	LI	Lighting Fixture
FU	Furniture	WC	Water Closet

WALL TYPES

STW1	116mm Dry-Dry Wall 13mm Plaster Board, 90mm Timber Stud Frame13mm Plaster Board
STW2	116mm Wet-Dry Wall 13mm Plaster Board, 90mm Timber Stud Frame13mm Plaster Board, 2mm Glue, 10mm Tile
STW3	116mm Wet-Wet Wall 10mm Tile, 2mm Glue, 13mm Plaster Board, 90mm Timber Stud Frame13mm Plaster Board, 2mm Glue, 10mm Tile

DOOR AND WINDOW TAGS

D1	Door Tag	W1	Window Tag
----	----------	----	------------

Keynote Legend

AP06	Mirage Tall single hinged door TC60 by IMC
AP10	Benchtops 900mm BT8900-LS by Waldorf
EQ02	Ice Chest with covers BZ54/060 by IMC
EQ07	Perforated Workshop BZ69/100 by IMC
EQ11	Basket Rack with telescopic Slides BZ23/055 by IMC
EQ21	Leg Frame BB02/208 by IMC
EQ23	Corner Top BZ17/051 by IMC
EQ29	Painted Steel Bar support BB70/001 by IMC
LI01	Beat flat tall pendant by Tom Dixon
M01	

NOTES

0 0.05 0.1 0.25m

Revisions		
No	Date	Description
01	17.05.2019	PRESENTATION DRAWINGS

Do not scale drawings. Use figured dimensions only. Check and verify levels and dimensions on site prior to commencement of any work, the preparation of drawings or the fabrication of components.
This drawing is copyright and can not be reproduced without written consent.

Client
Sue & Andy Baker

Le Velo

True North

Billy Blue College of Design
46-52 Mountain Street, Ultimo, NSW 2007, Australia
+61 (0)2 9999 9999


BILLY BLUE COLLEGE OF DESIGN
TORRENS UNIVERSITY AUSTRALIA
LAUREATE INTERNATIONAL UNIVERSITIES

Project
IDC302A Assessment Brief 2
46 Baywater Drive, Wentworth Point, NSW, 2127
Project number
Year. 2019


Drawing Title
BAR ELEVATIONS 4 & 5
Drawing Status
PRESENTATION DRAWINGS
NOT FOR CONSTRUCTION

Scale
1:20
Date
17.05.2019
Drawing No
A11
Issue
01
Drawn by
PRM

10/05/2019 8:07:14 AM

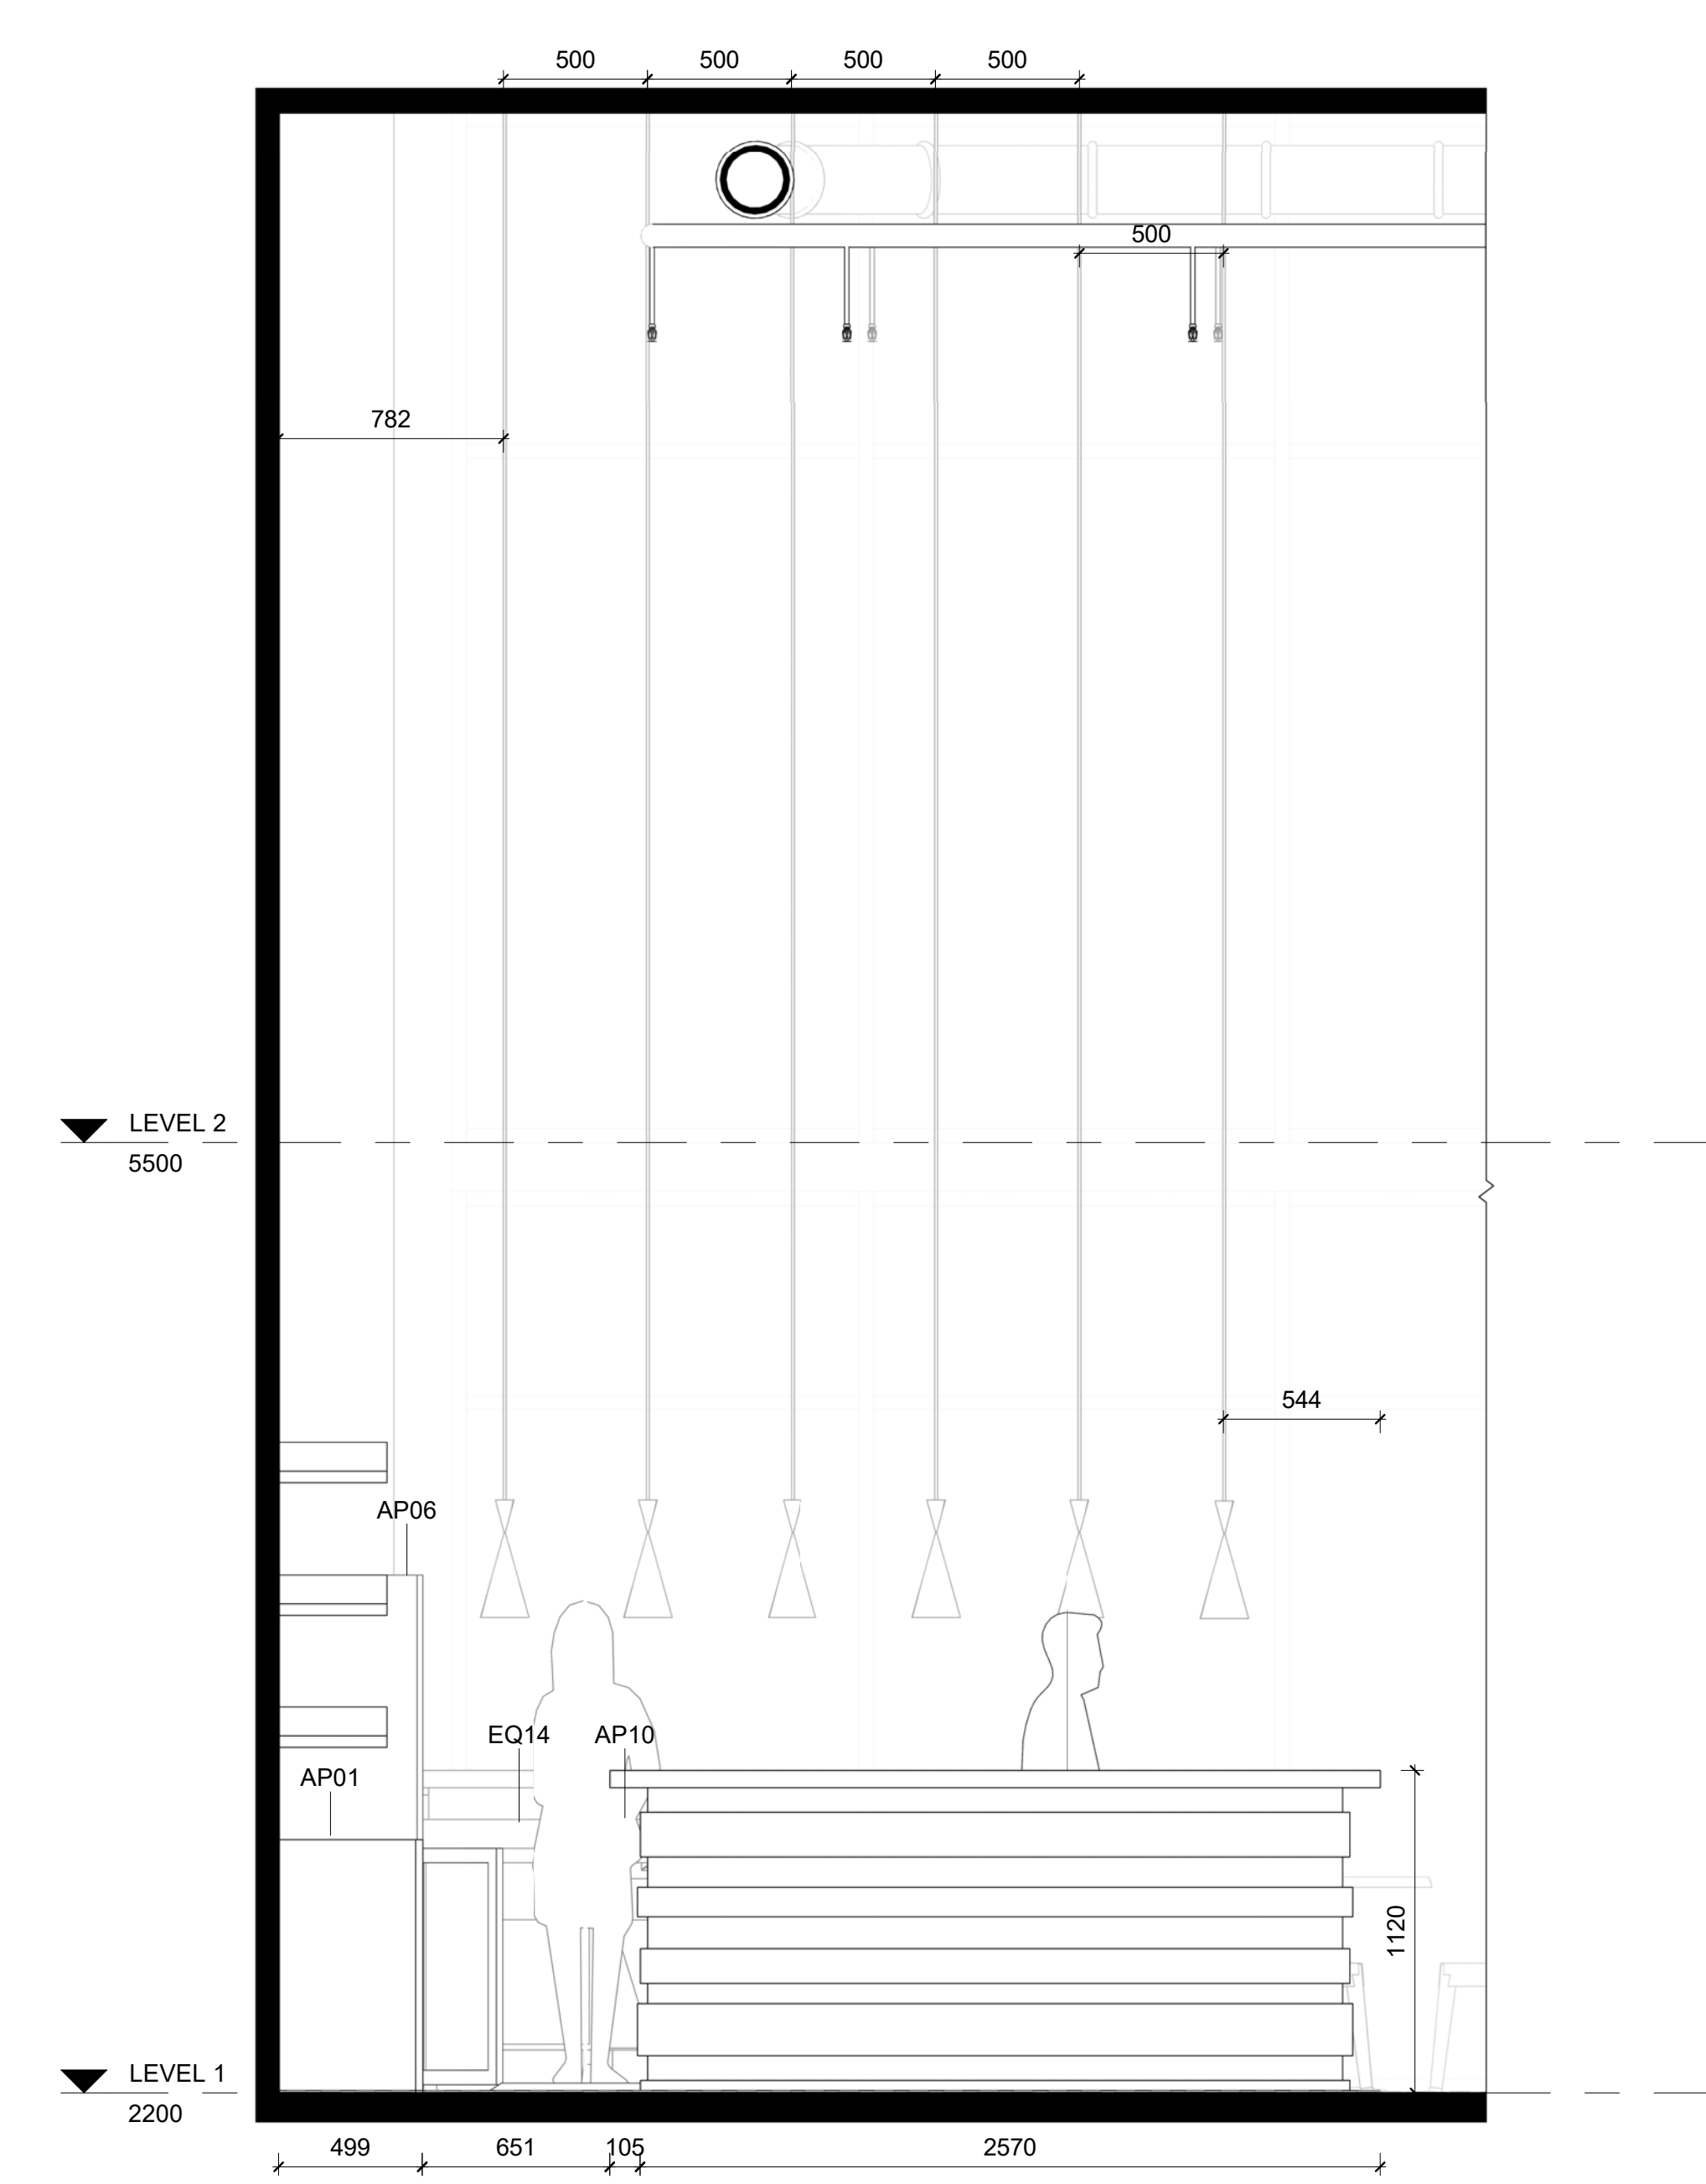

1 BAR Elevation 6
1 : 20

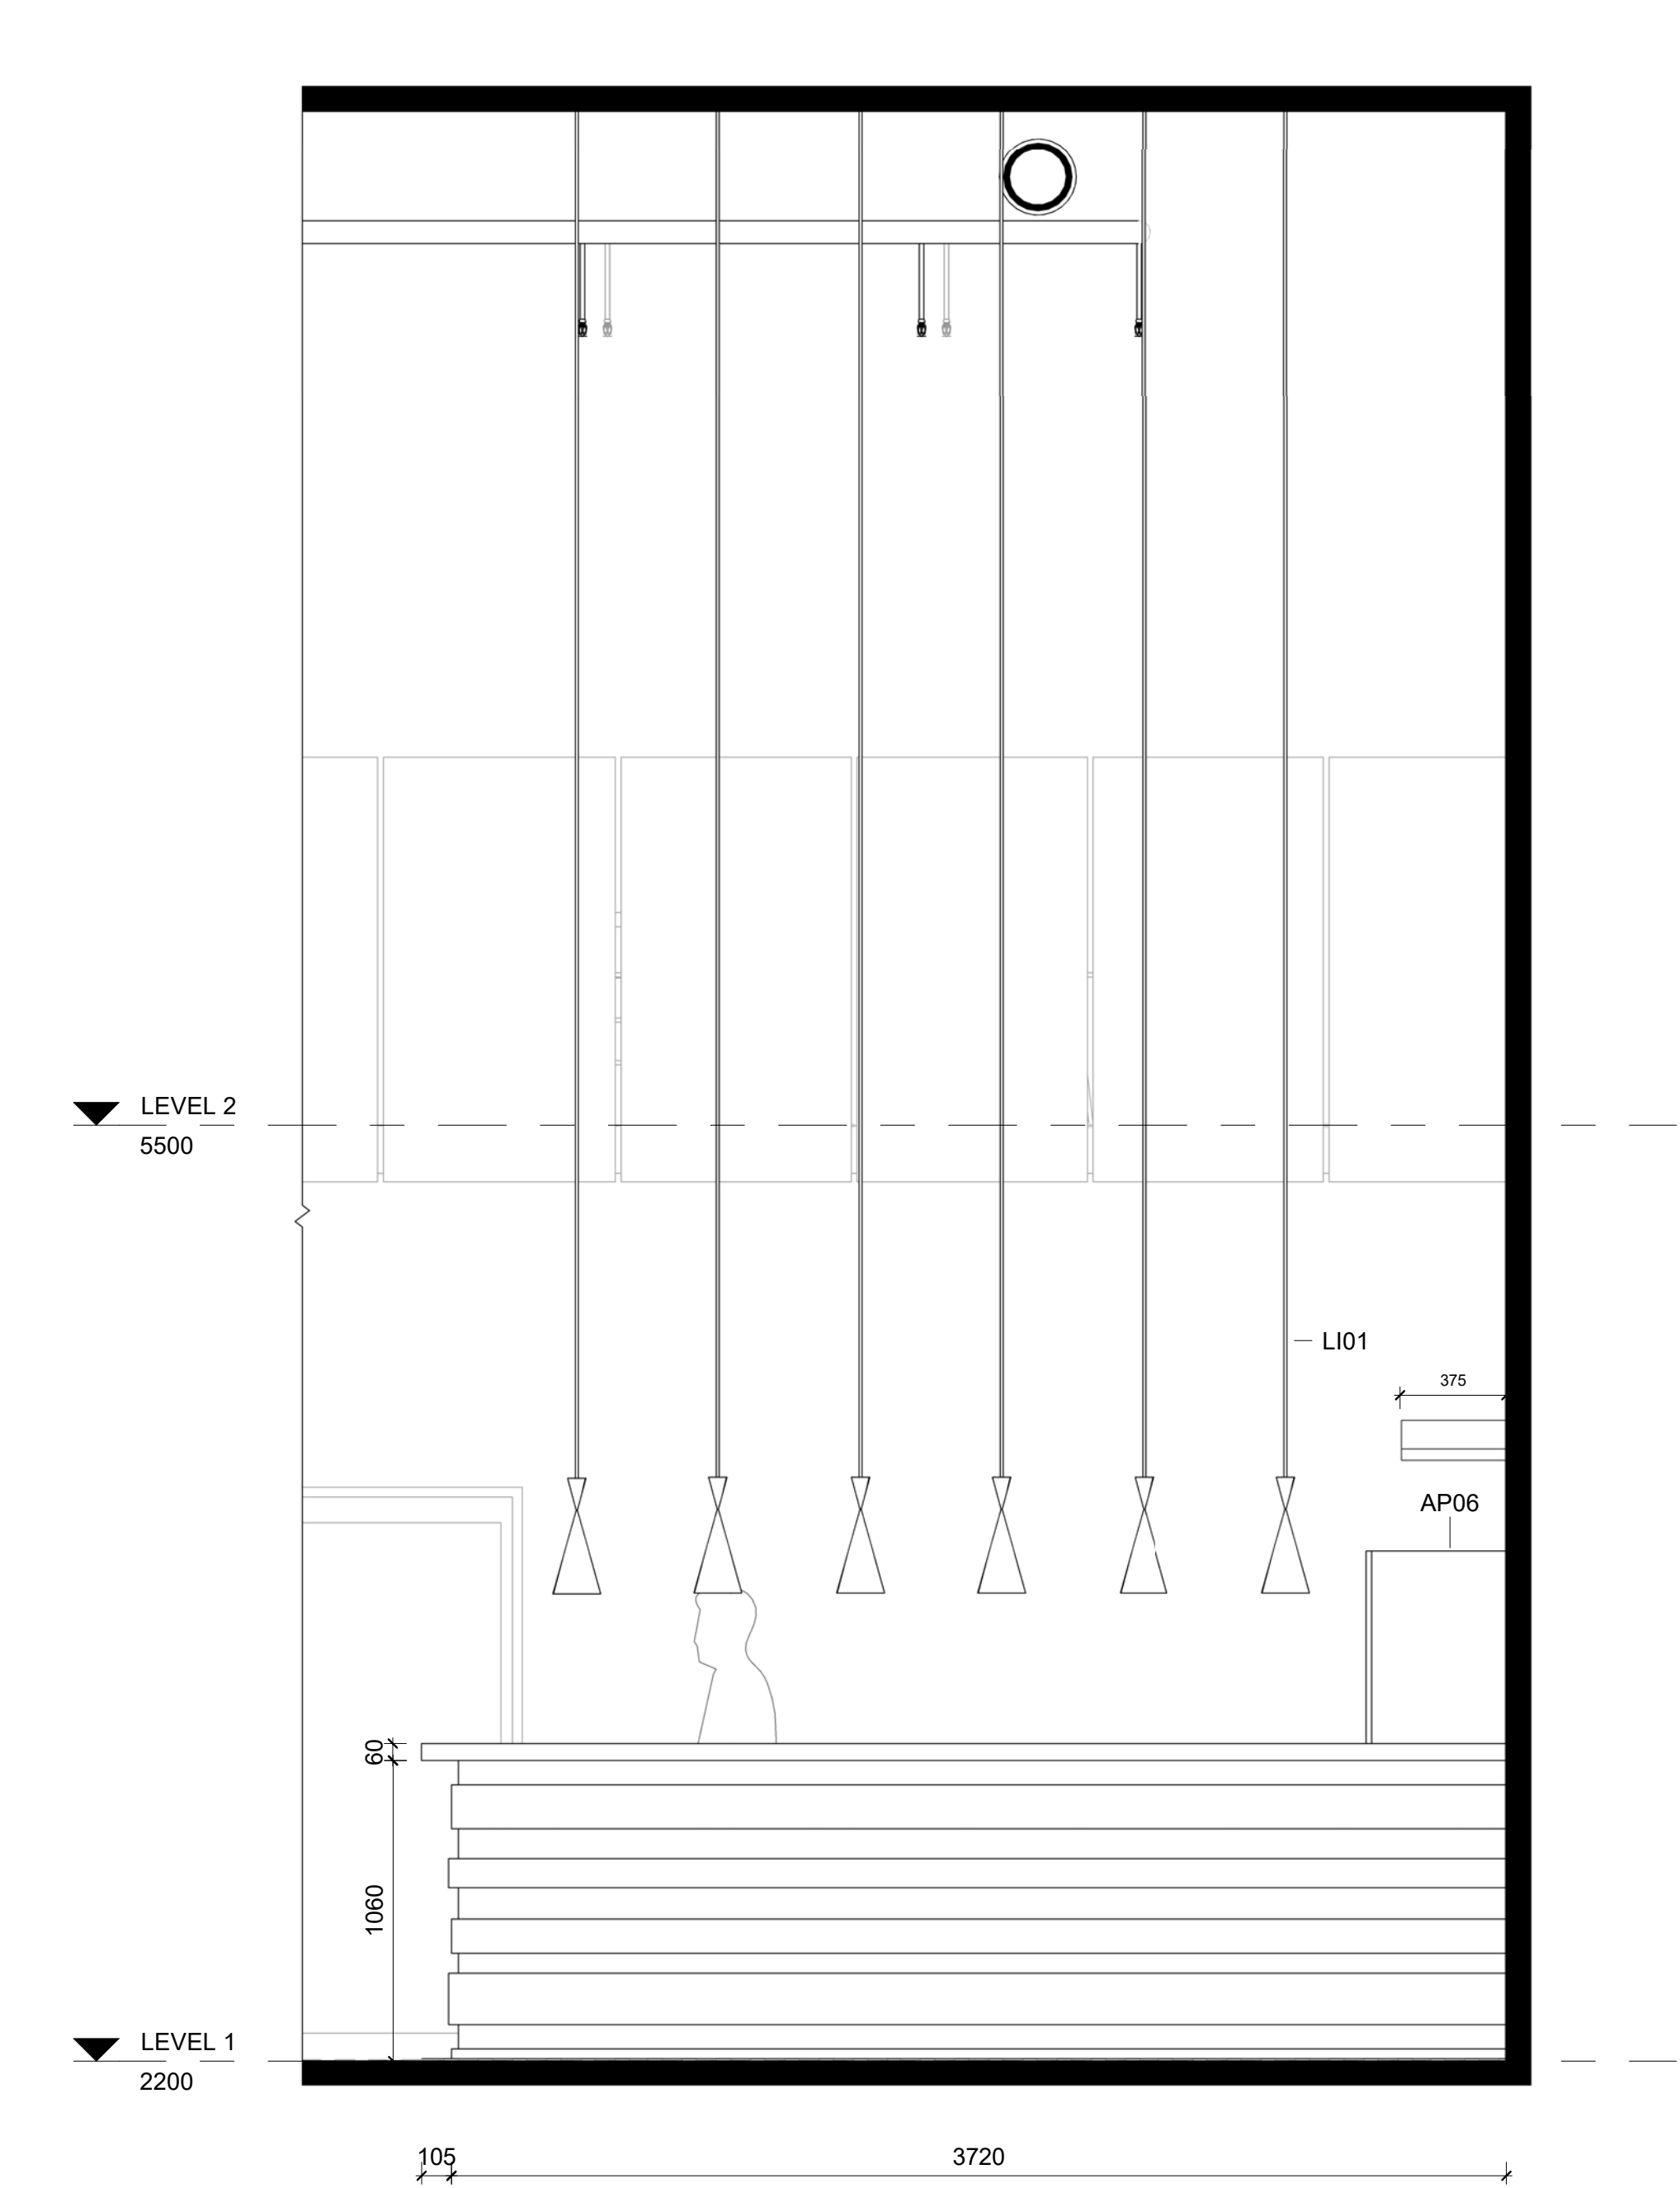

2 BAR Elevation 7
1 : 20

LEGEND

CUT PATTERN LEGEND

EXISTING		INSULATION	
CONCRETE		EARTH	
MDF		TILE	
TIMBER		STEEL	
ALUMINUM			

ABBREVIATIONS

FFL	Finished Floor Level	EQ	Specialty Equipment
FCL	Finished Ceiling Level	AP	Electrical Equipment
SE	Services	SA	Plumbing Fixture
MA	Material	LI	Lighting Fixture
FU	Furniture	WC	Water Closet

WALL TYPES

STW1 116mm Dry-Dry Wall
13mm Plaster Board, 90mm Timber Stud Frame13mm Plaster Board

STW2 116mm Wet-Dry Wall
13mm Plaster Board, 90mm Timber Stud Frame13mm Plaster Board, 2mm Glue, 10mm Tile

STW3 116mm Wet-Wet Wall
10mm Tile, 2mm Glue, 13mm Plaster Board, 90mm Timber Stud Frame13mm Plaster Board, 2mm Glue, 10mm Tile

DOOR AND WINDOW TAGS

D1 Door Tag W1 Window Tag

Keynote Legend


AP01 Refrigeration module B16/704S by IMC
AP06 Mirage Tall single hinged door TC60 by IMC
AP10 Benchtops 900mm BT3900-LS by Waldorf
EQ14 Worktop Unit BZ50/060 by IMC
LI01 Beat flat tall pendant by Tom Dixon

NOTES


Revisions			Do not scale drawings. Use figured dimensions only. Check and verify levels and dimensions on site prior to commencement of any work, the preparation of drawings or the fabrication of components. This drawing is copyright and can not be reproduced without written consent.	Client Sue & Andy Baker Le Velo	True North	Billy Blue College of Design 46-52 Mountain Street, Ultimo, NSW 2007, Australia +61 (0)2 9999 9999 BILLY BLUE COLLEGE OF DESIGN T TORRENS UNIVERSITY AUSTRALIA LAUREATE INTERNATIONAL UNIVERSITIES <th rowspan="3">Project IDC302A Assessment Brief 2 46 Baywater Drive, Wentworth Point, NSW, 2127 Project number Year. 2019</th> <th rowspan="3">Drawing Title BAR ELEVATIONS 6 & 7 Drawing Status PRESENTATION DRAWINGS NOT FOR CONSTRUCTION</th> <th>Scale</th> <th>Drawing No</th> <th>Issue</th>	Project IDC302A Assessment Brief 2 46 Baywater Drive, Wentworth Point, NSW, 2127 Project number Year. 2019	Drawing Title BAR ELEVATIONS 6 & 7 Drawing Status PRESENTATION DRAWINGS NOT FOR CONSTRUCTION	Scale	Drawing No	Issue	
No	Date	Description							Ver. App'd	1:20	A12	01
01	17.05.2019	PRESENTATION DRAWINGS							Approver	Date	17.05.2019	
								Drawn by	PRM			

10/05/2019 8:07:27 AM

A1

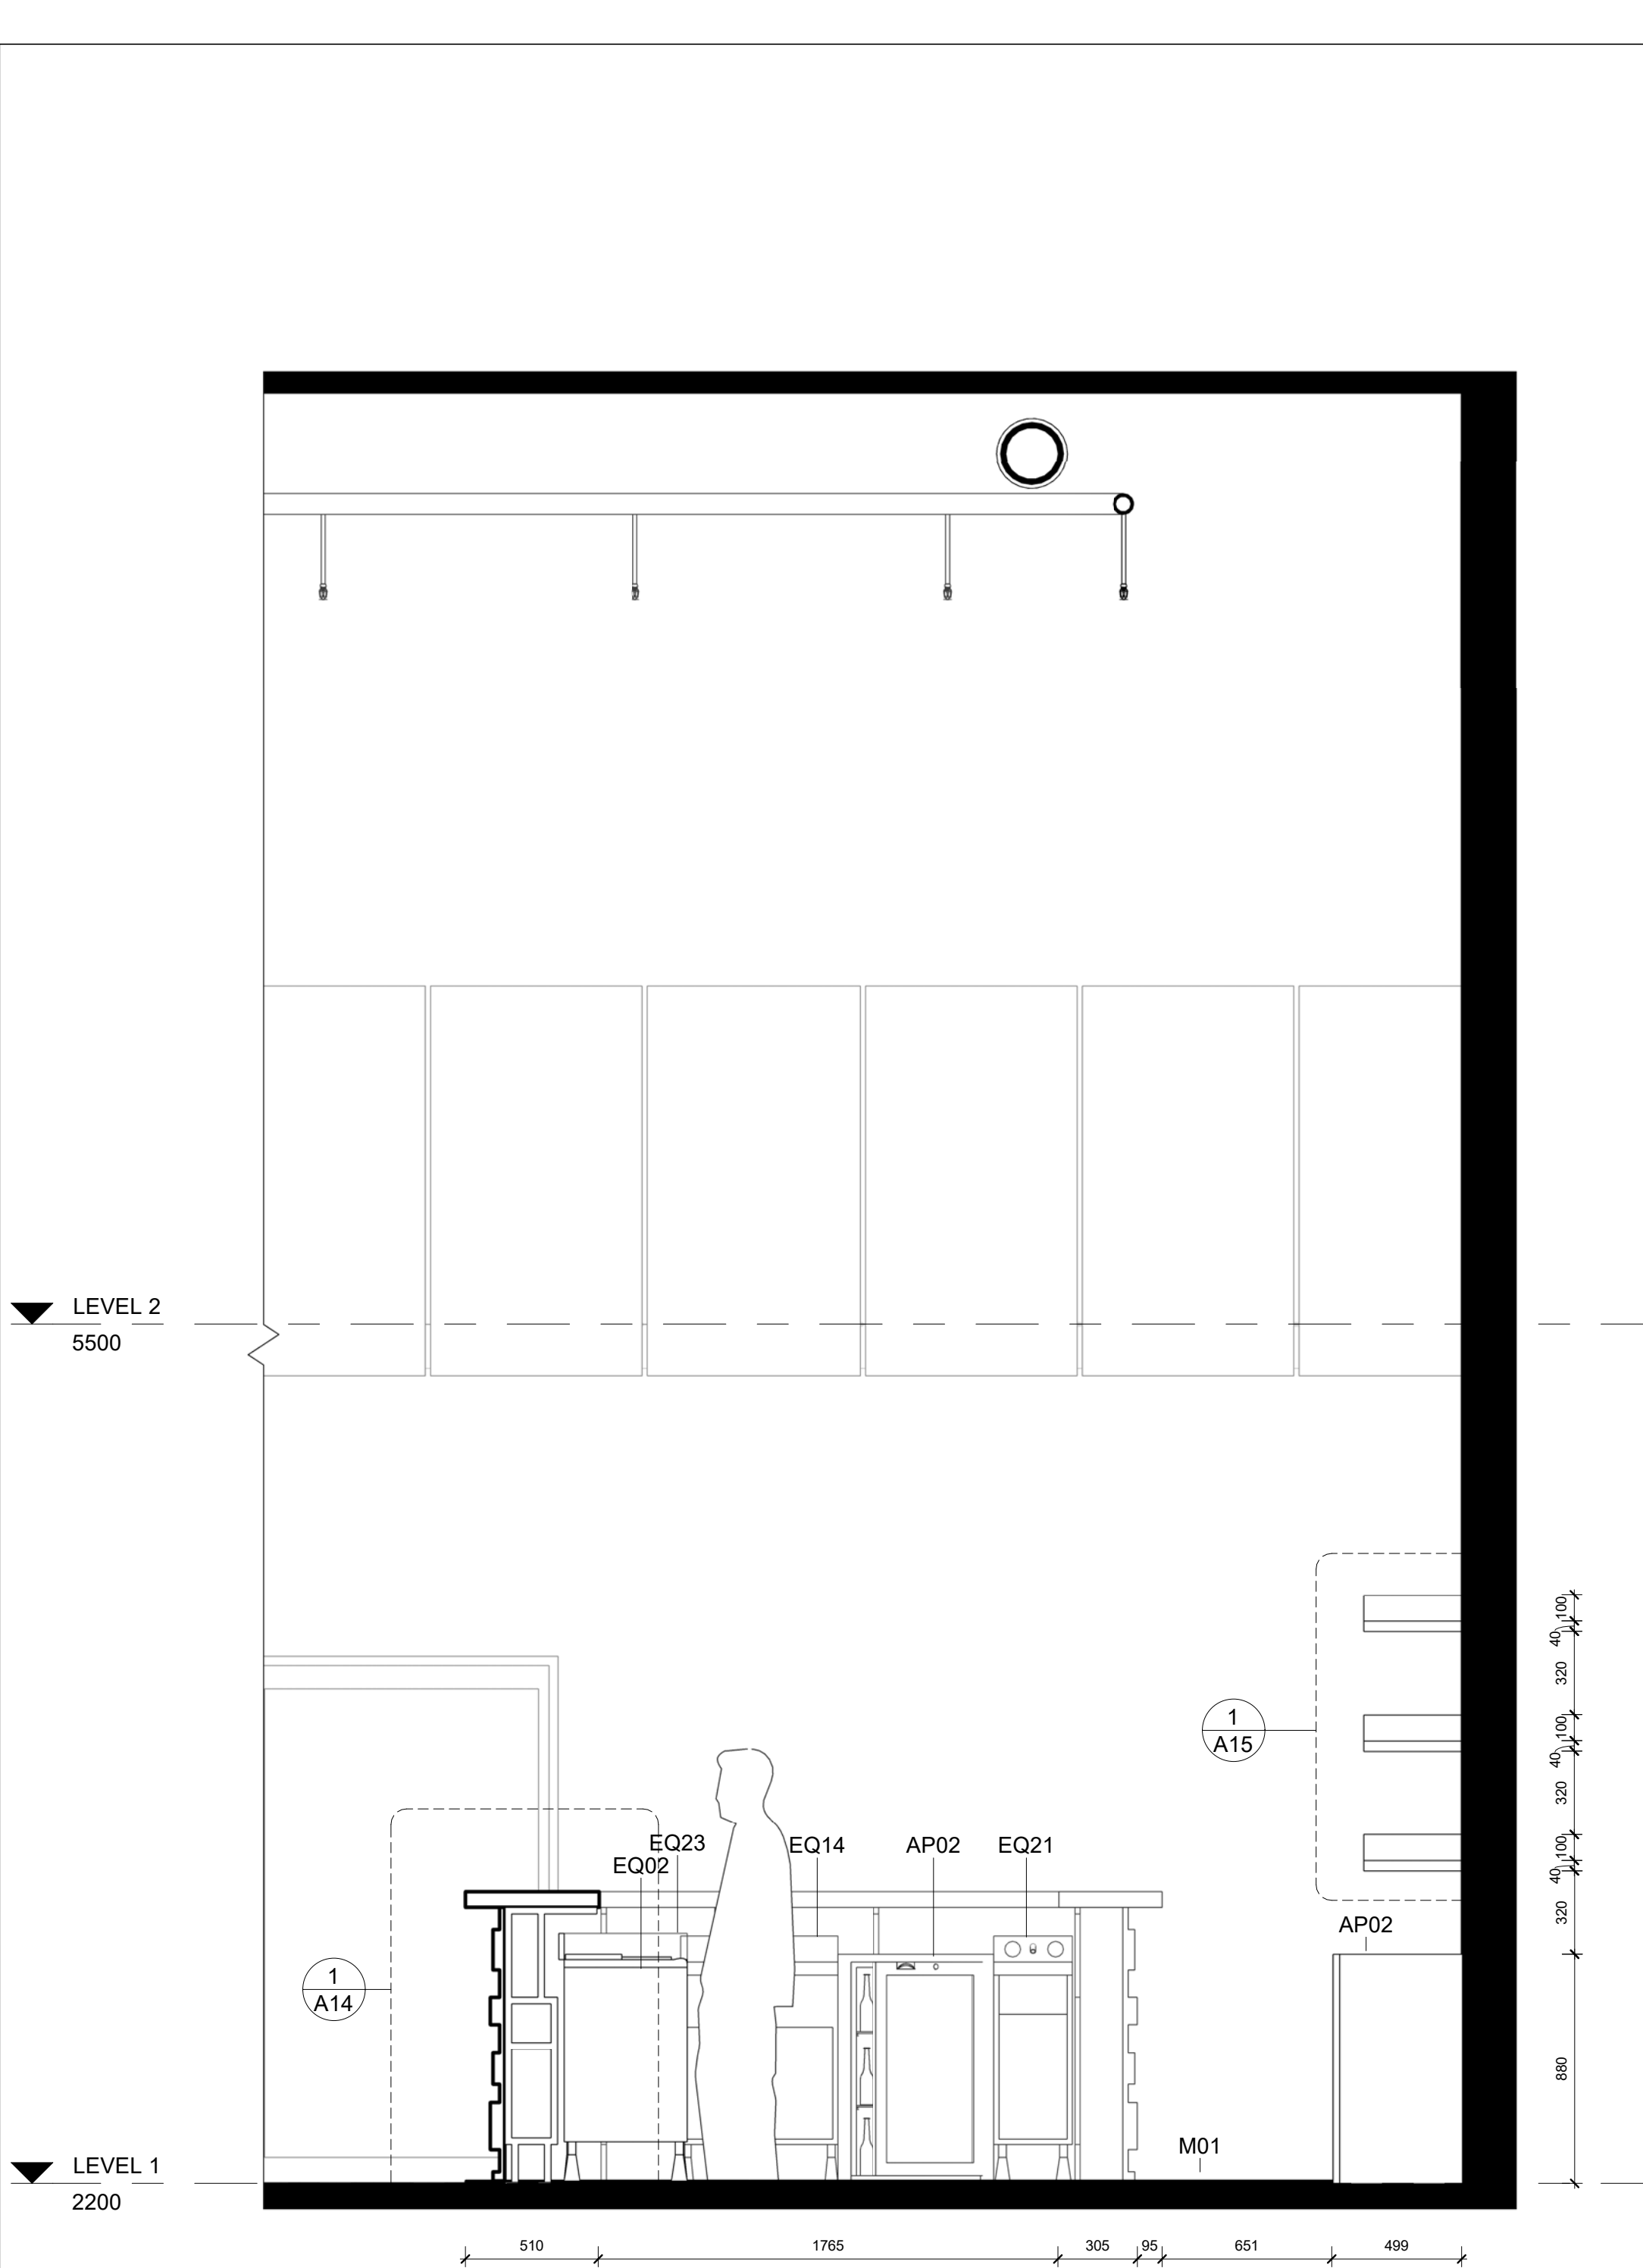

1 BAR Section
1 : 20

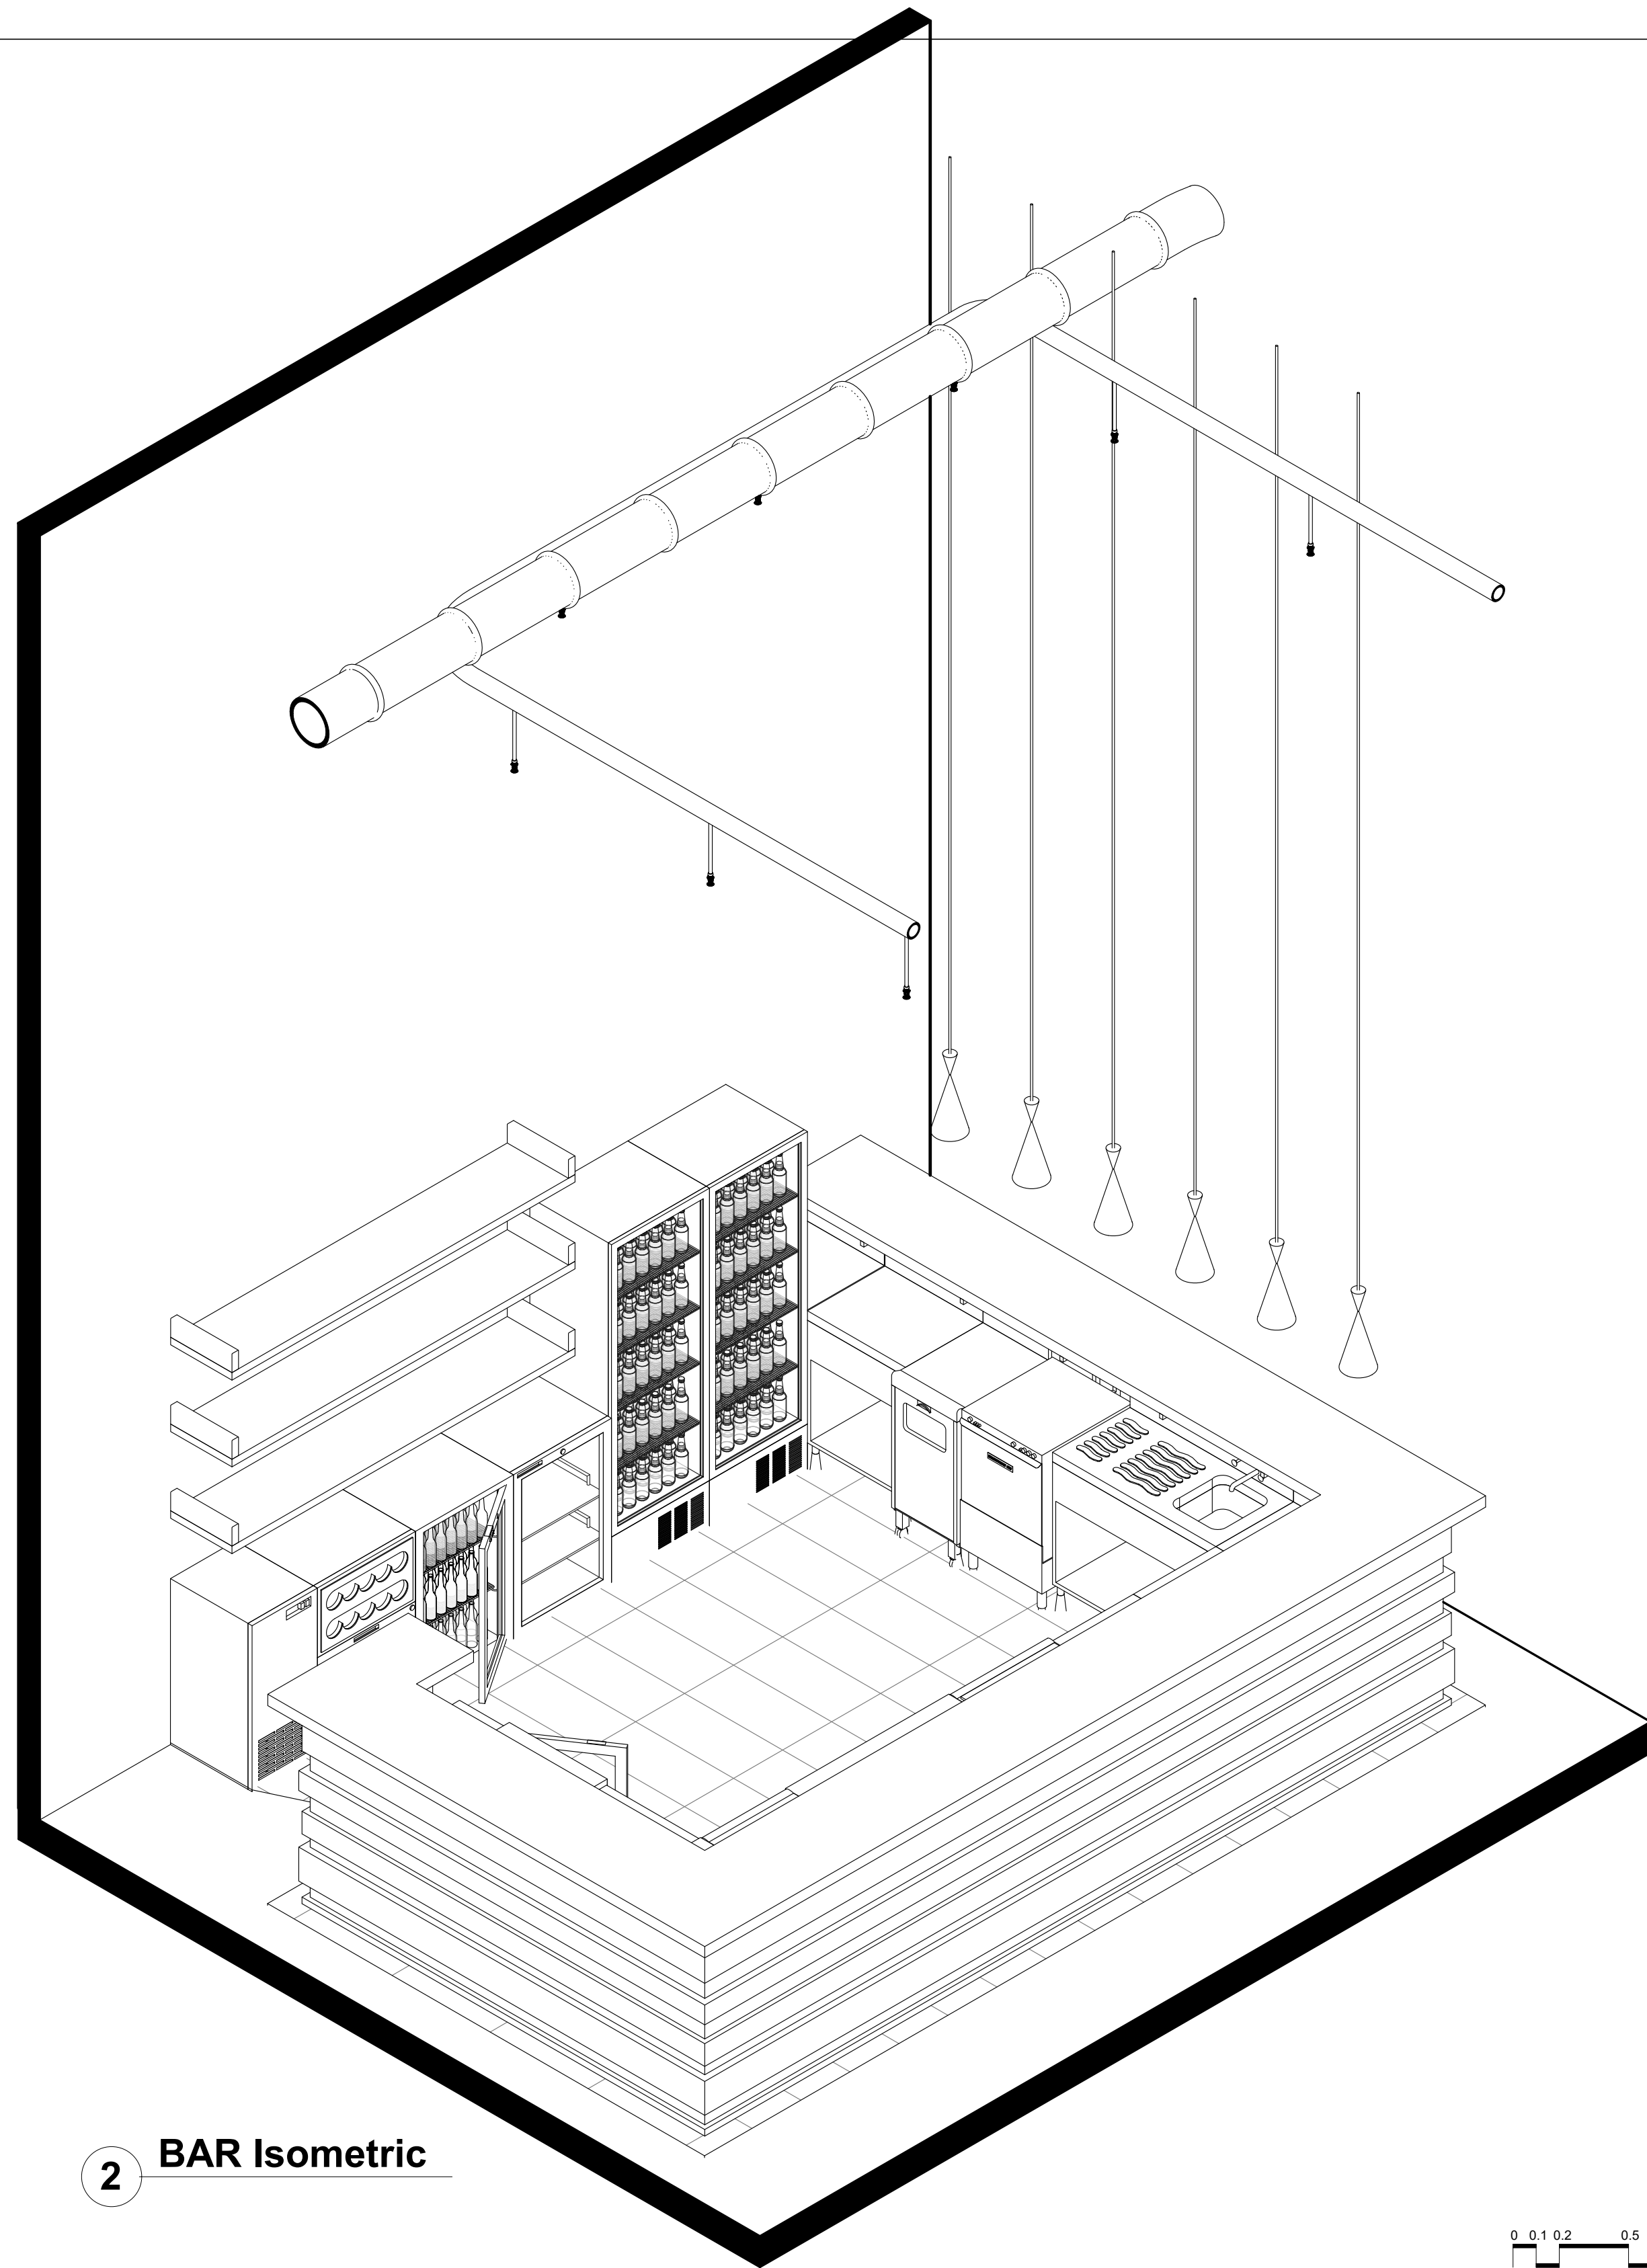

2 BAR Isometric

LEGEND

CUT PATTERN LEGEND

EXISTING	INSULATION
CONCRETE	EARTH
MDF	TILE
TIMBER	STEEL
ALUMINUM	

ABBREVIATIONS

FFL	Finished Floor Level	EQ	Specialty Equipment
FCL	Finished Ceiling Level	AP	Electrical Equipment
SE	Services	SA	Plumbing Fixture
MA	Material	LI	Lighting Fixture
FU	Furniture	WC	Water Closet

WALL TYPES

STW1	116mm Dry-Dry Wall 13mm Plaster Board, 90mm Timber Stud Frame 13mm Plaster Board
STW2	116mm Wet-Dry Wall 13mm Plaster Board, 90mm Timber Stud Frame 13mm Plaster Board, 2mm Glue, 10mm Tile
STW3	116mm Wet-Wet Wall 10mm Tile, 2mm Glue, 13mm Plaster Board, 90mm Timber Stud Frame 13mm Plaster Board, 2mm Glue, 10mm Tile

DOOR AND WINDOW TAGS

D1	Door Tag	W1	Window Tag
----	----------	----	------------

Keynote Legend

AP02 1x Glass Door add-on module B16/700S by IMC
EQ02 Ice Chest with covers BZ54/060 by IMC
EQ14 Worktop Unit BZ50/060 by IMC
EQ21 Leg Frame BB02/208 by IMC
EQ23 Corner Top BZ17/051 by IMC
M01

NOTES



No	Date	Description	Ver.	App'd
01	17.05.2019	PRESENTATION DRAWINGS		Approver

Do not scale drawings. Use figured dimensions only. Check and verify levels and dimensions on site prior to commencement of any work, the preparation of drawings or the fabrication of components.
This drawing is copyright and can not be reproduced without written consent.

Client
Sue & Andy Baker

Le Velo

True North

Billy Blue College of Design
46-52 Mountain Street, Ultimo, NSW 2007, Australia
+61 (0)2 9999 9999




Project
IDC302A Assessment Brief 2
46 Baywater Drive, Wentworth Point, NSW, 2127
Project number
Year. 2019

Drawing Title
BAR SECTION 1 & ISOMETRIC VIEW
Drawing Status
PRESENTATION DRAWINGS
NOT FOR CONSTRUCTION

Scale
1:20
Date
17.05.2019
Drawing No
A13
Issue
01
Drawn by
PRM

10/05/2019 8:07:51 AM

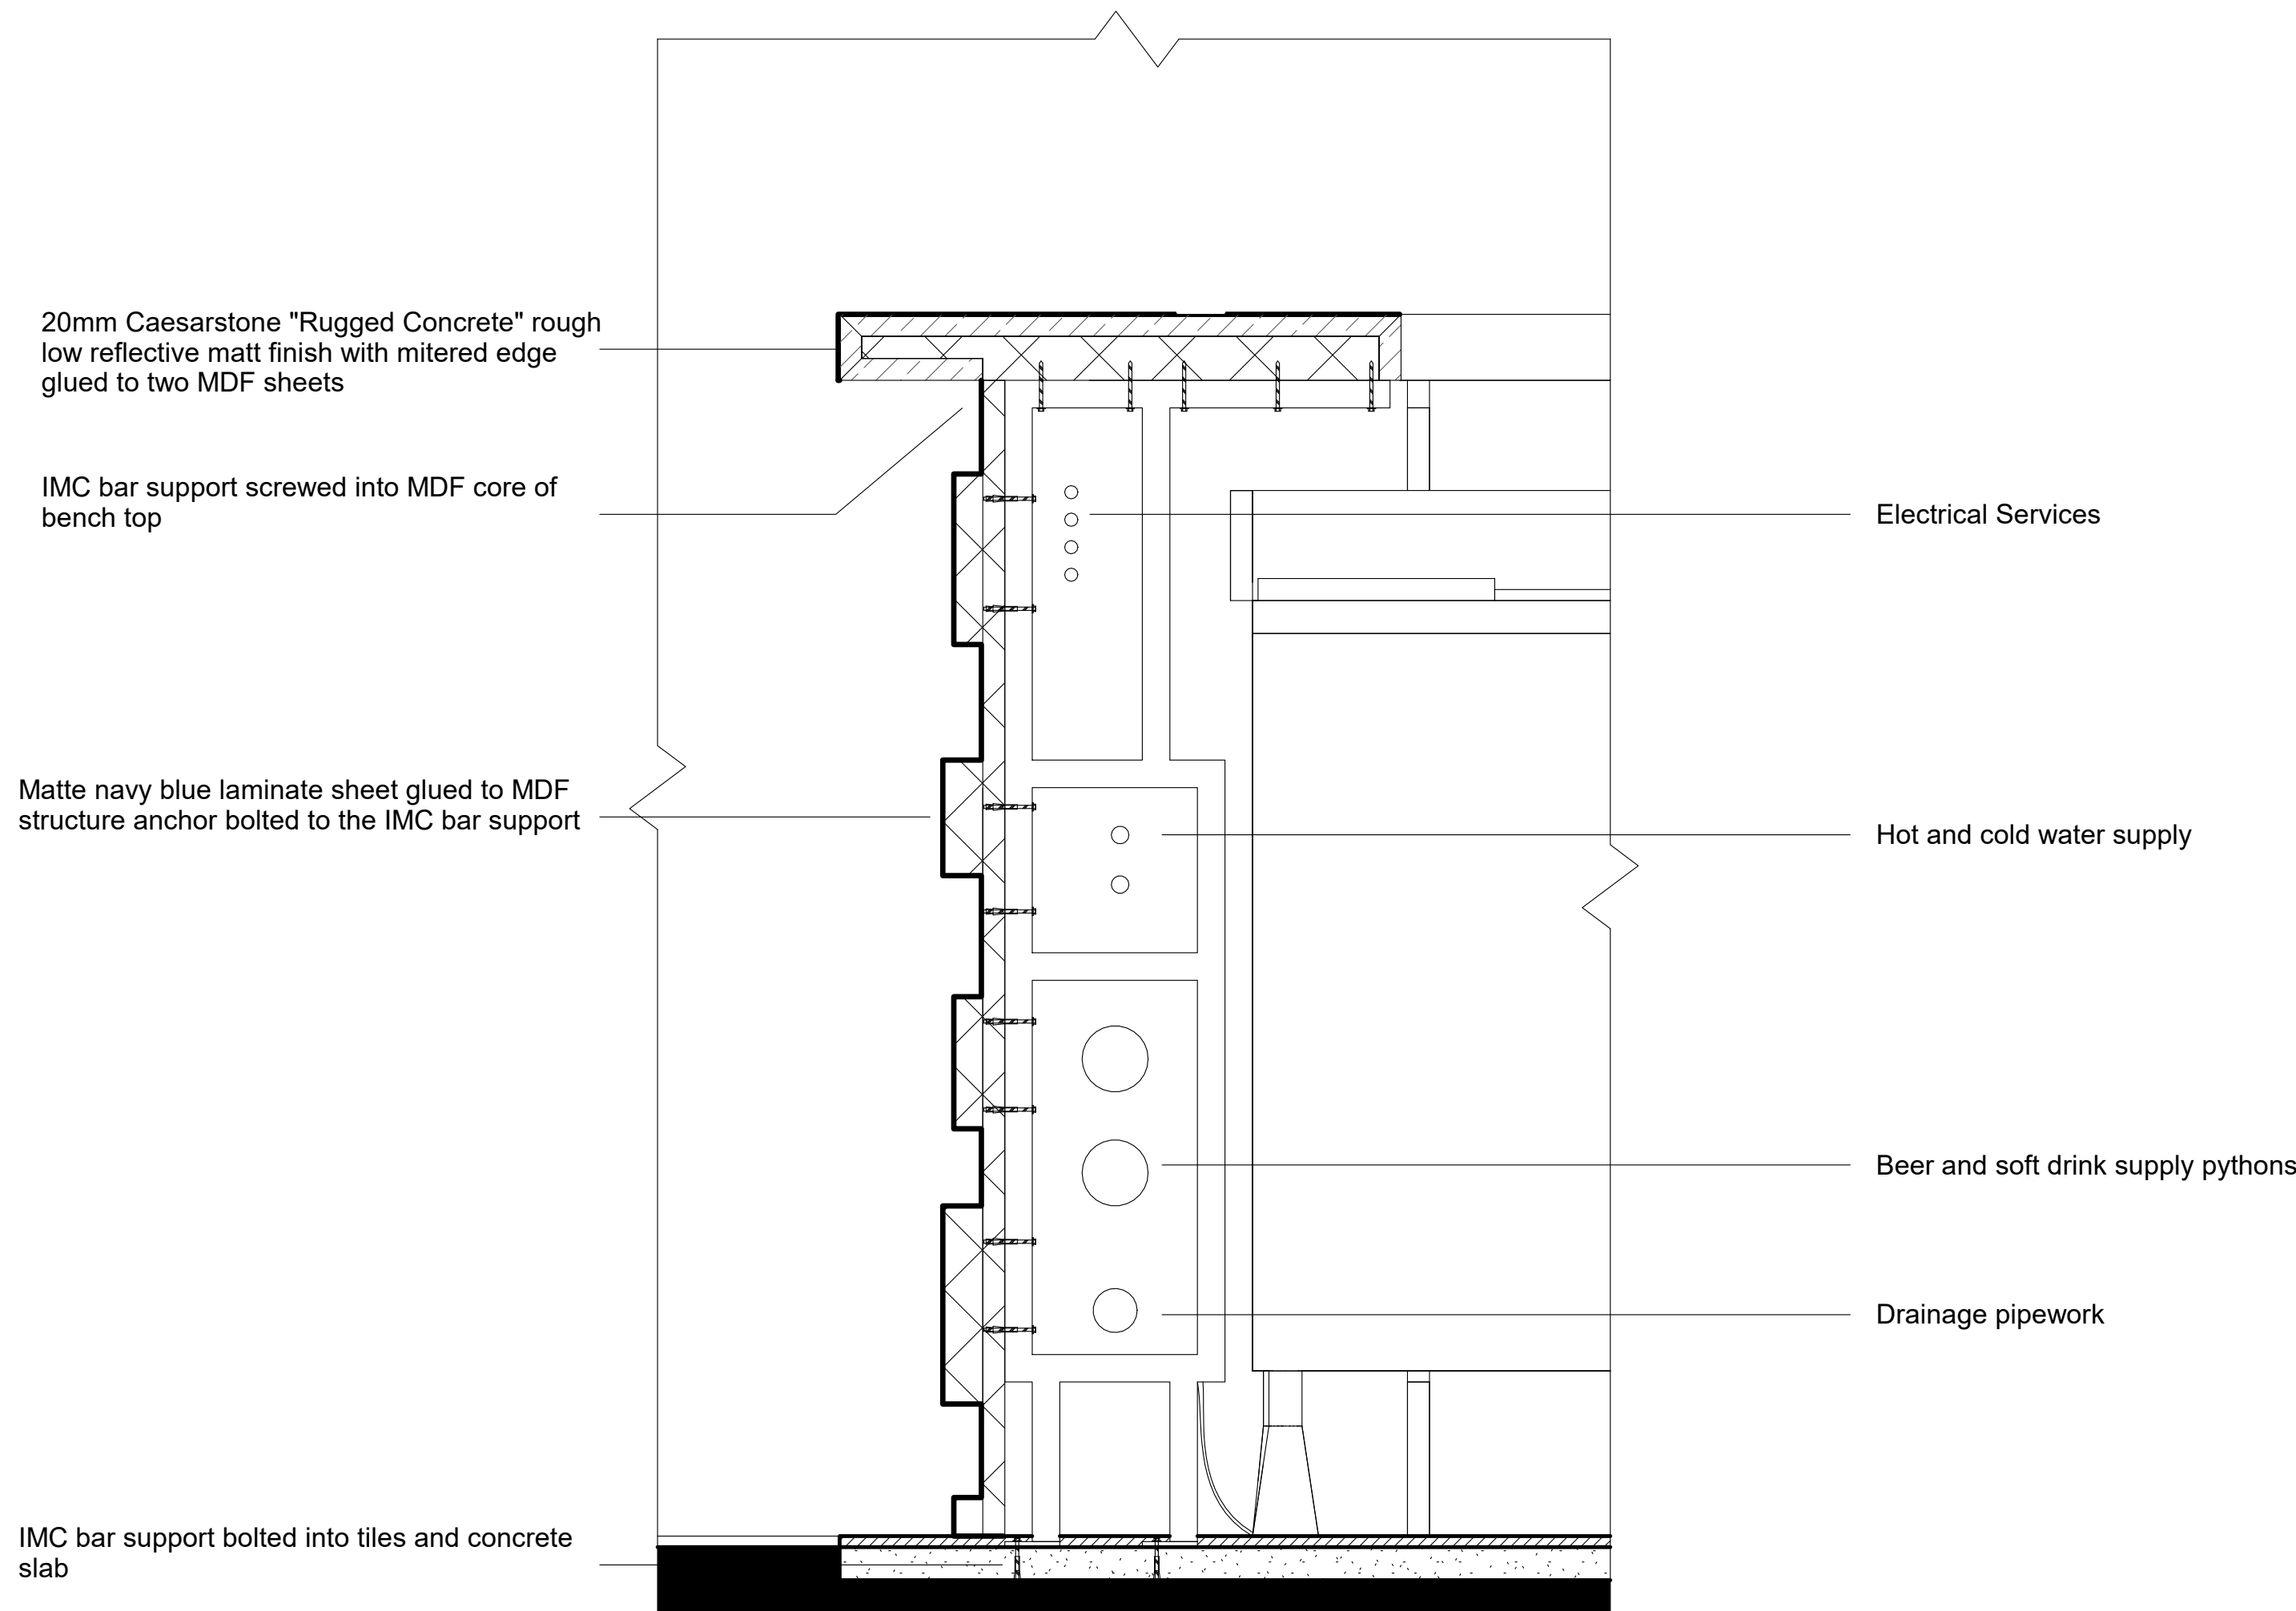

1 BAR Section - Bar
1 : 5

LEGEND

CUT PATTERN LEGEND

EXISTING		INSULATION	
CONCRETE		EARTH	
MDF		TILE	
TIMBER		STEEL	
ALUMINUM			

ABBREVIATIONS

FFL	Finished Floor Level	EQ	Specialty Equipment
FCL	Finished Ceiling Level	AP	Electrical Equipment
SE	Services	SA	Plumbing Fixture
MA	Material	LI	Lighting Fixture
FU	Furniture	WC	Water Closet

WALL TYPES


STW1	116mm Dry-Dry Wall 13mm Plaster Board, 90mm Timber Stud Frame 13mm Plaster Board
STW2	116mm Wet-Dry Wall 13mm Plaster Board, 90mm Timber Stud Frame 13mm Plaster Board, 2mm Glue, 10mm Tile
STW3	116mm Wet-Wet Wall 10mm Tile, 2mm Glue, 13mm Plaster Board, 90mm Timber Stud Frame 13mm Plaster Board, 2mm Glue, 10mm Tile

DOOR AND WINDOW TAGS



D1	Door Tag	W1	Window Tag
----	----------	----	------------

Keynote Legend

 NOTES



Revisions			Do not scale drawings. Use figured dimensions only. Check and verify levels and dimensions on site prior to commencement of any work, the preparation of drawings or the fabrication of components. This drawing is copyright and can not be reproduced without written consent.	Client Sue & Andy Baker 	True North	Billy Blue College of Design 46-52 Mountain Street, Ultimo, NSW 2007, Australia +61 (0)2 9999 9999 	Project IDC302A Assessment Brief 2 46 Baywater Drive, Wentworth Point, NSW, 2127 Project number Year. 2019	Drawing Title BAR DETAIL SECTION Drawing Status PRESENTATION DRAWINGS NOT FOR CONSTRUCTION	Scale 1:5 Date 17.05.2019 Drawn by PRM	Drawing No A14 Issue 01
No	Date	Description	Ver. App'd							
01	17.05.2019	PRESENTATION DRAWINGS	Approver							

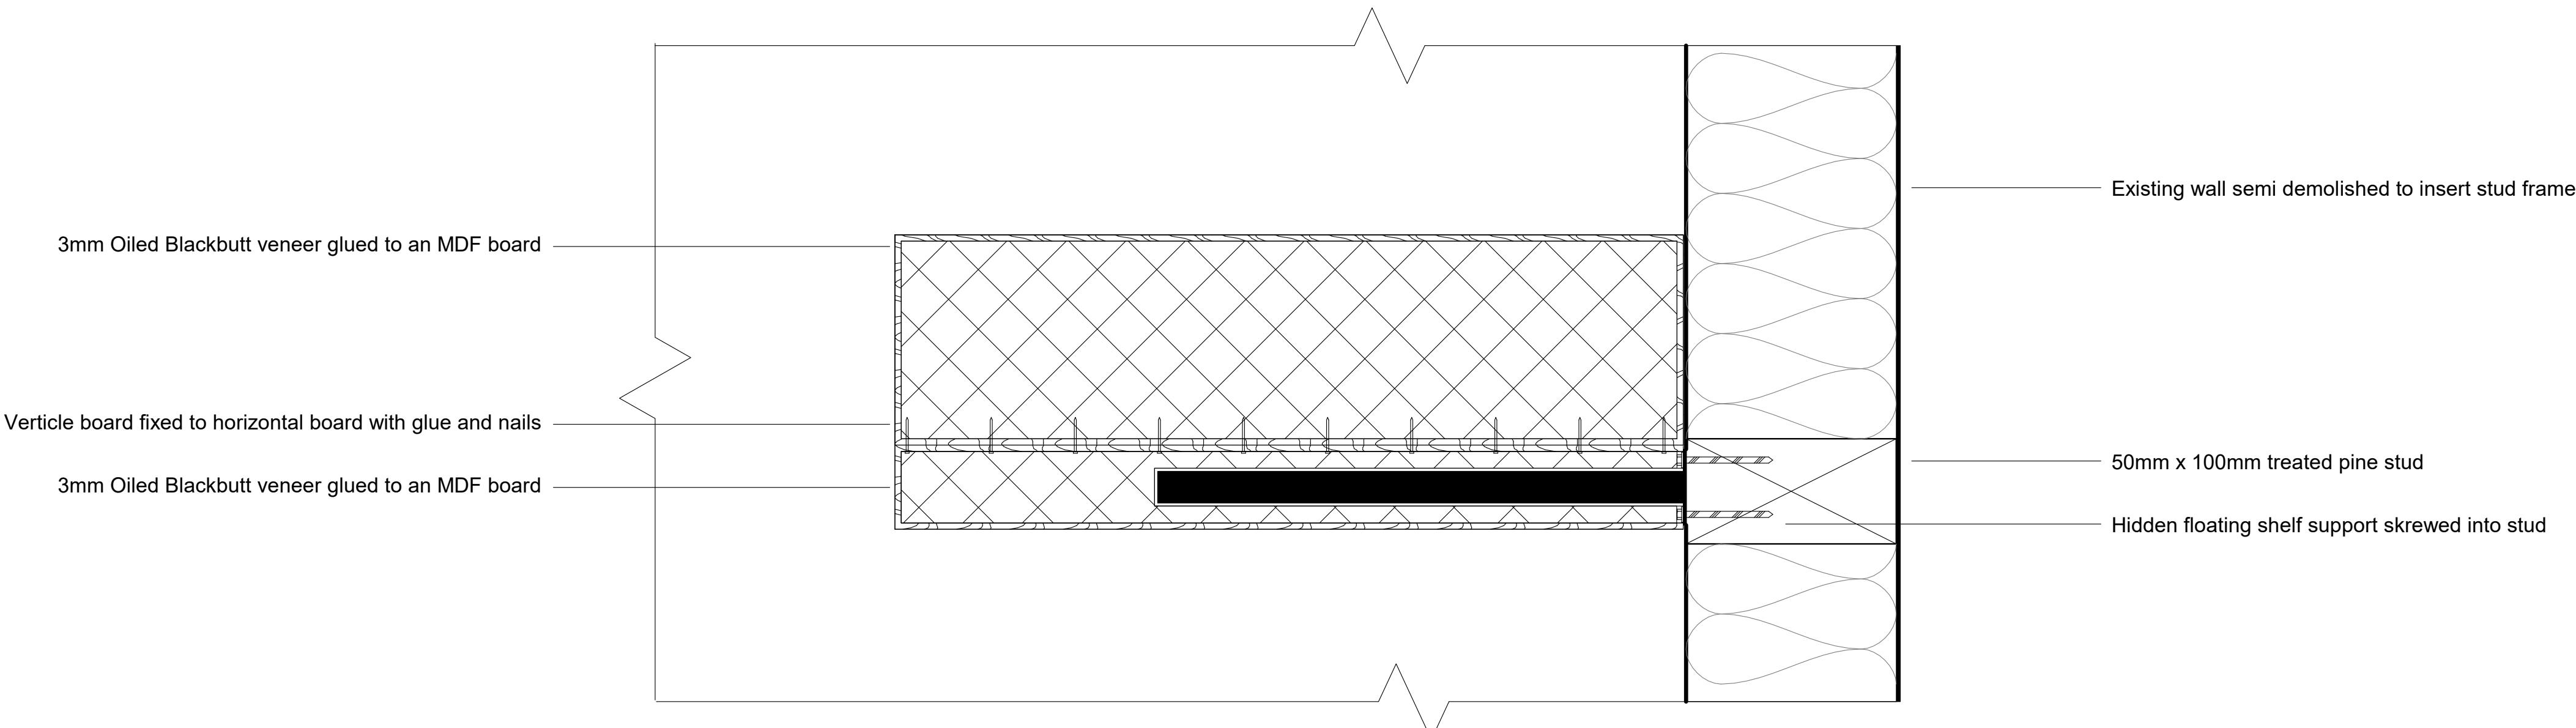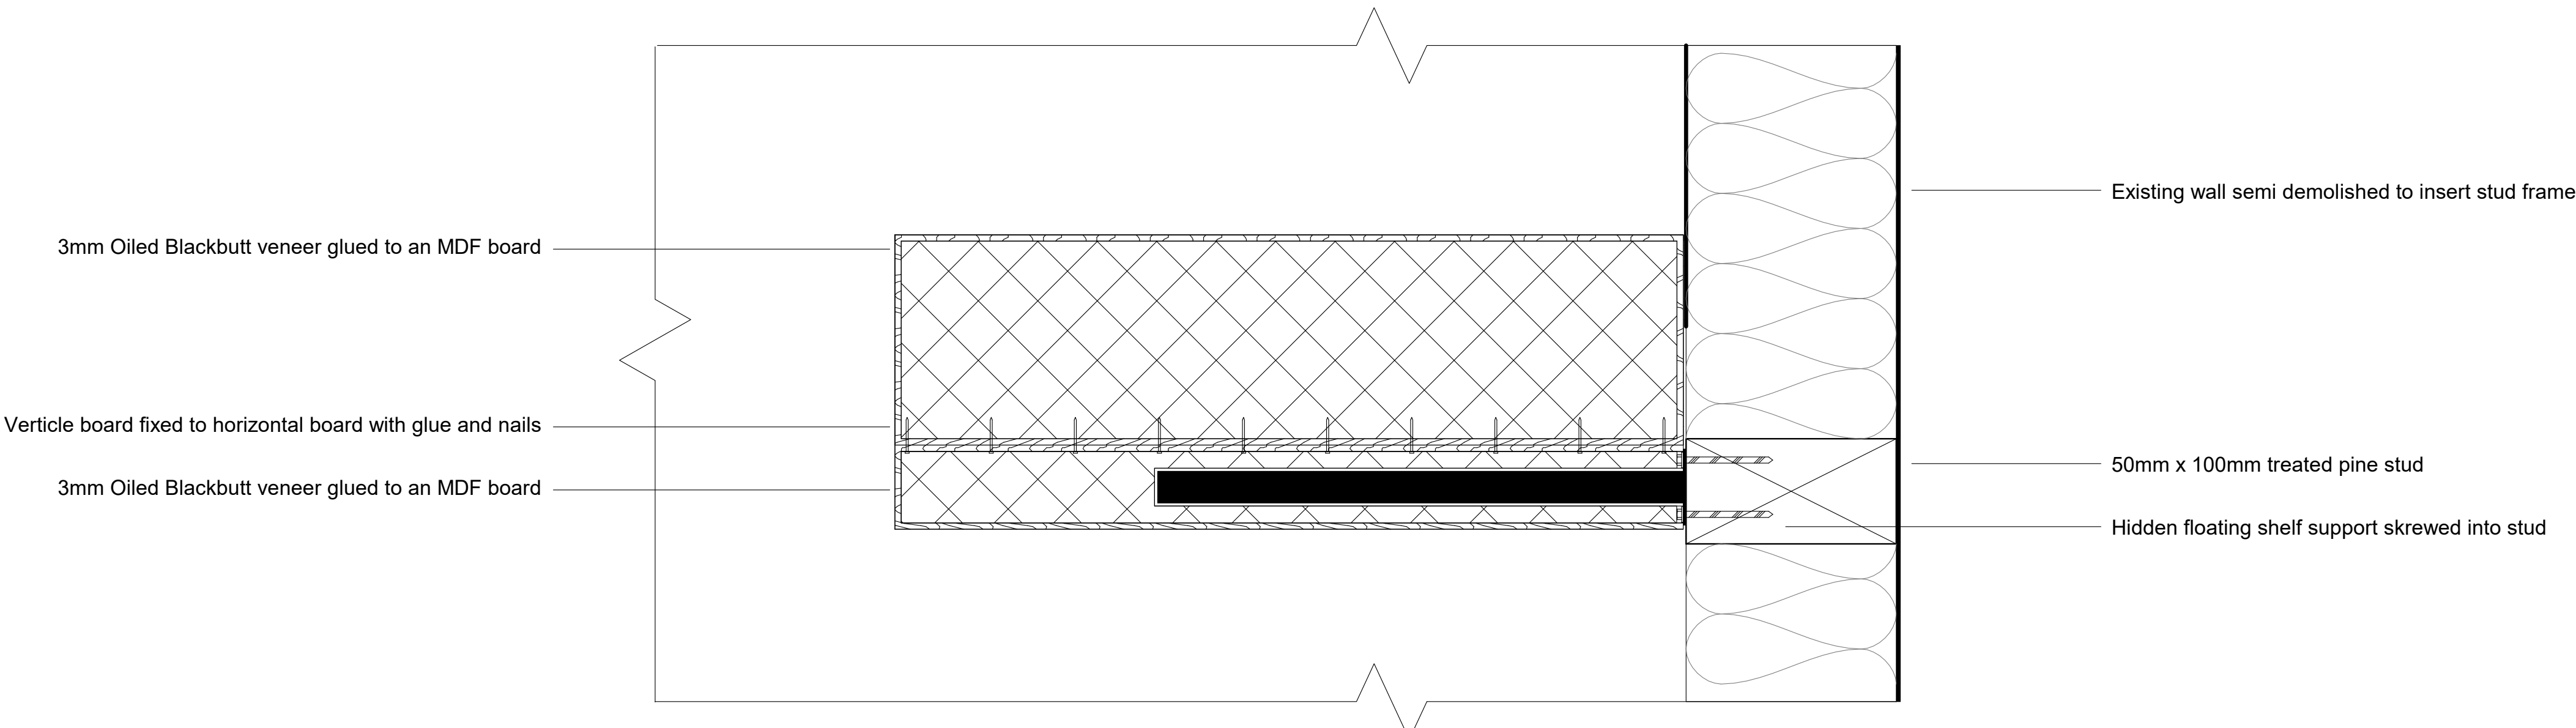

LEGEND

CUT PATTERN LEGEND

EXISTING		INSULATION	
CONCRETE		EARTH	
MDF		TILE	
TIMBER		STEEL	
ALUMINUM			

ABBREVIATIONS

FFL	Finished Floor Level	EQ	Specialty Equipment
FCL	Finished Ceiling Level	AP	Electrical Equipment
SE	Services	SA	Plumbing Fixture
MA	Material	LI	Lighting Fixture
FU	Furniture	WC	Water Closet

WALL TYPES

STW1 116mm Dry-Dry Wall
13mm Plaster Board, 90mm Timber Stud Frame13mm Plaster Board

STW2 116mm Wet-Dry Wall
13mm Plaster Board, 90mm Timber Stud Frame13mm Plaster Board, 2mm Glue, 10mm Tile

STW3 116mm Wet-Wet Wall
10mm Tile, 2mm Glue, 13mm Plaster Board, 90mm Timber Stud Frame13mm Plaster Board, 2mm Glue, 10mm Tile

DOOR AND WINDOW TAGS

D1 Door Tag

W1 Window Tag

1

BAR Section - Shelves


1 : 2




NOTES		

Revisions			Do not scale drawings. Use figured dimensions only. Check and verify levels and dimensions on site prior to commencement of any work, the preparation of drawings or the fabrication of components. This drawing is copyright and can not be reproduced without written consent.	Client Sue & Andy Baker 	True North	 BILLY BLUE COLLEGE OF DESIGN  TORRENS UNIVERSITY AUSTRALIA  LAUREATE INTERNATIONAL UNIVERSITIES	Project IDC302A Assessment Brief 2 46 Baywater Drive, Wentworth Point, NSW, 2127 Project number Year. 2019	Drawing Title SHELVING SYSTEM DEATIL SECTION Drawing Status PRESENTATION DRAWINGS NOT FOR CONSTRUCTION	Scale	Drawing No	Issue	
No	Date	Description							Ver. App'd	1:2	A15	01
01	17.05.2019	PRESENTATION DRAWINGS							Approver	Date	17.05.2019	
										Drawn by	PRM	

10/05/2019 8:07:54 AM

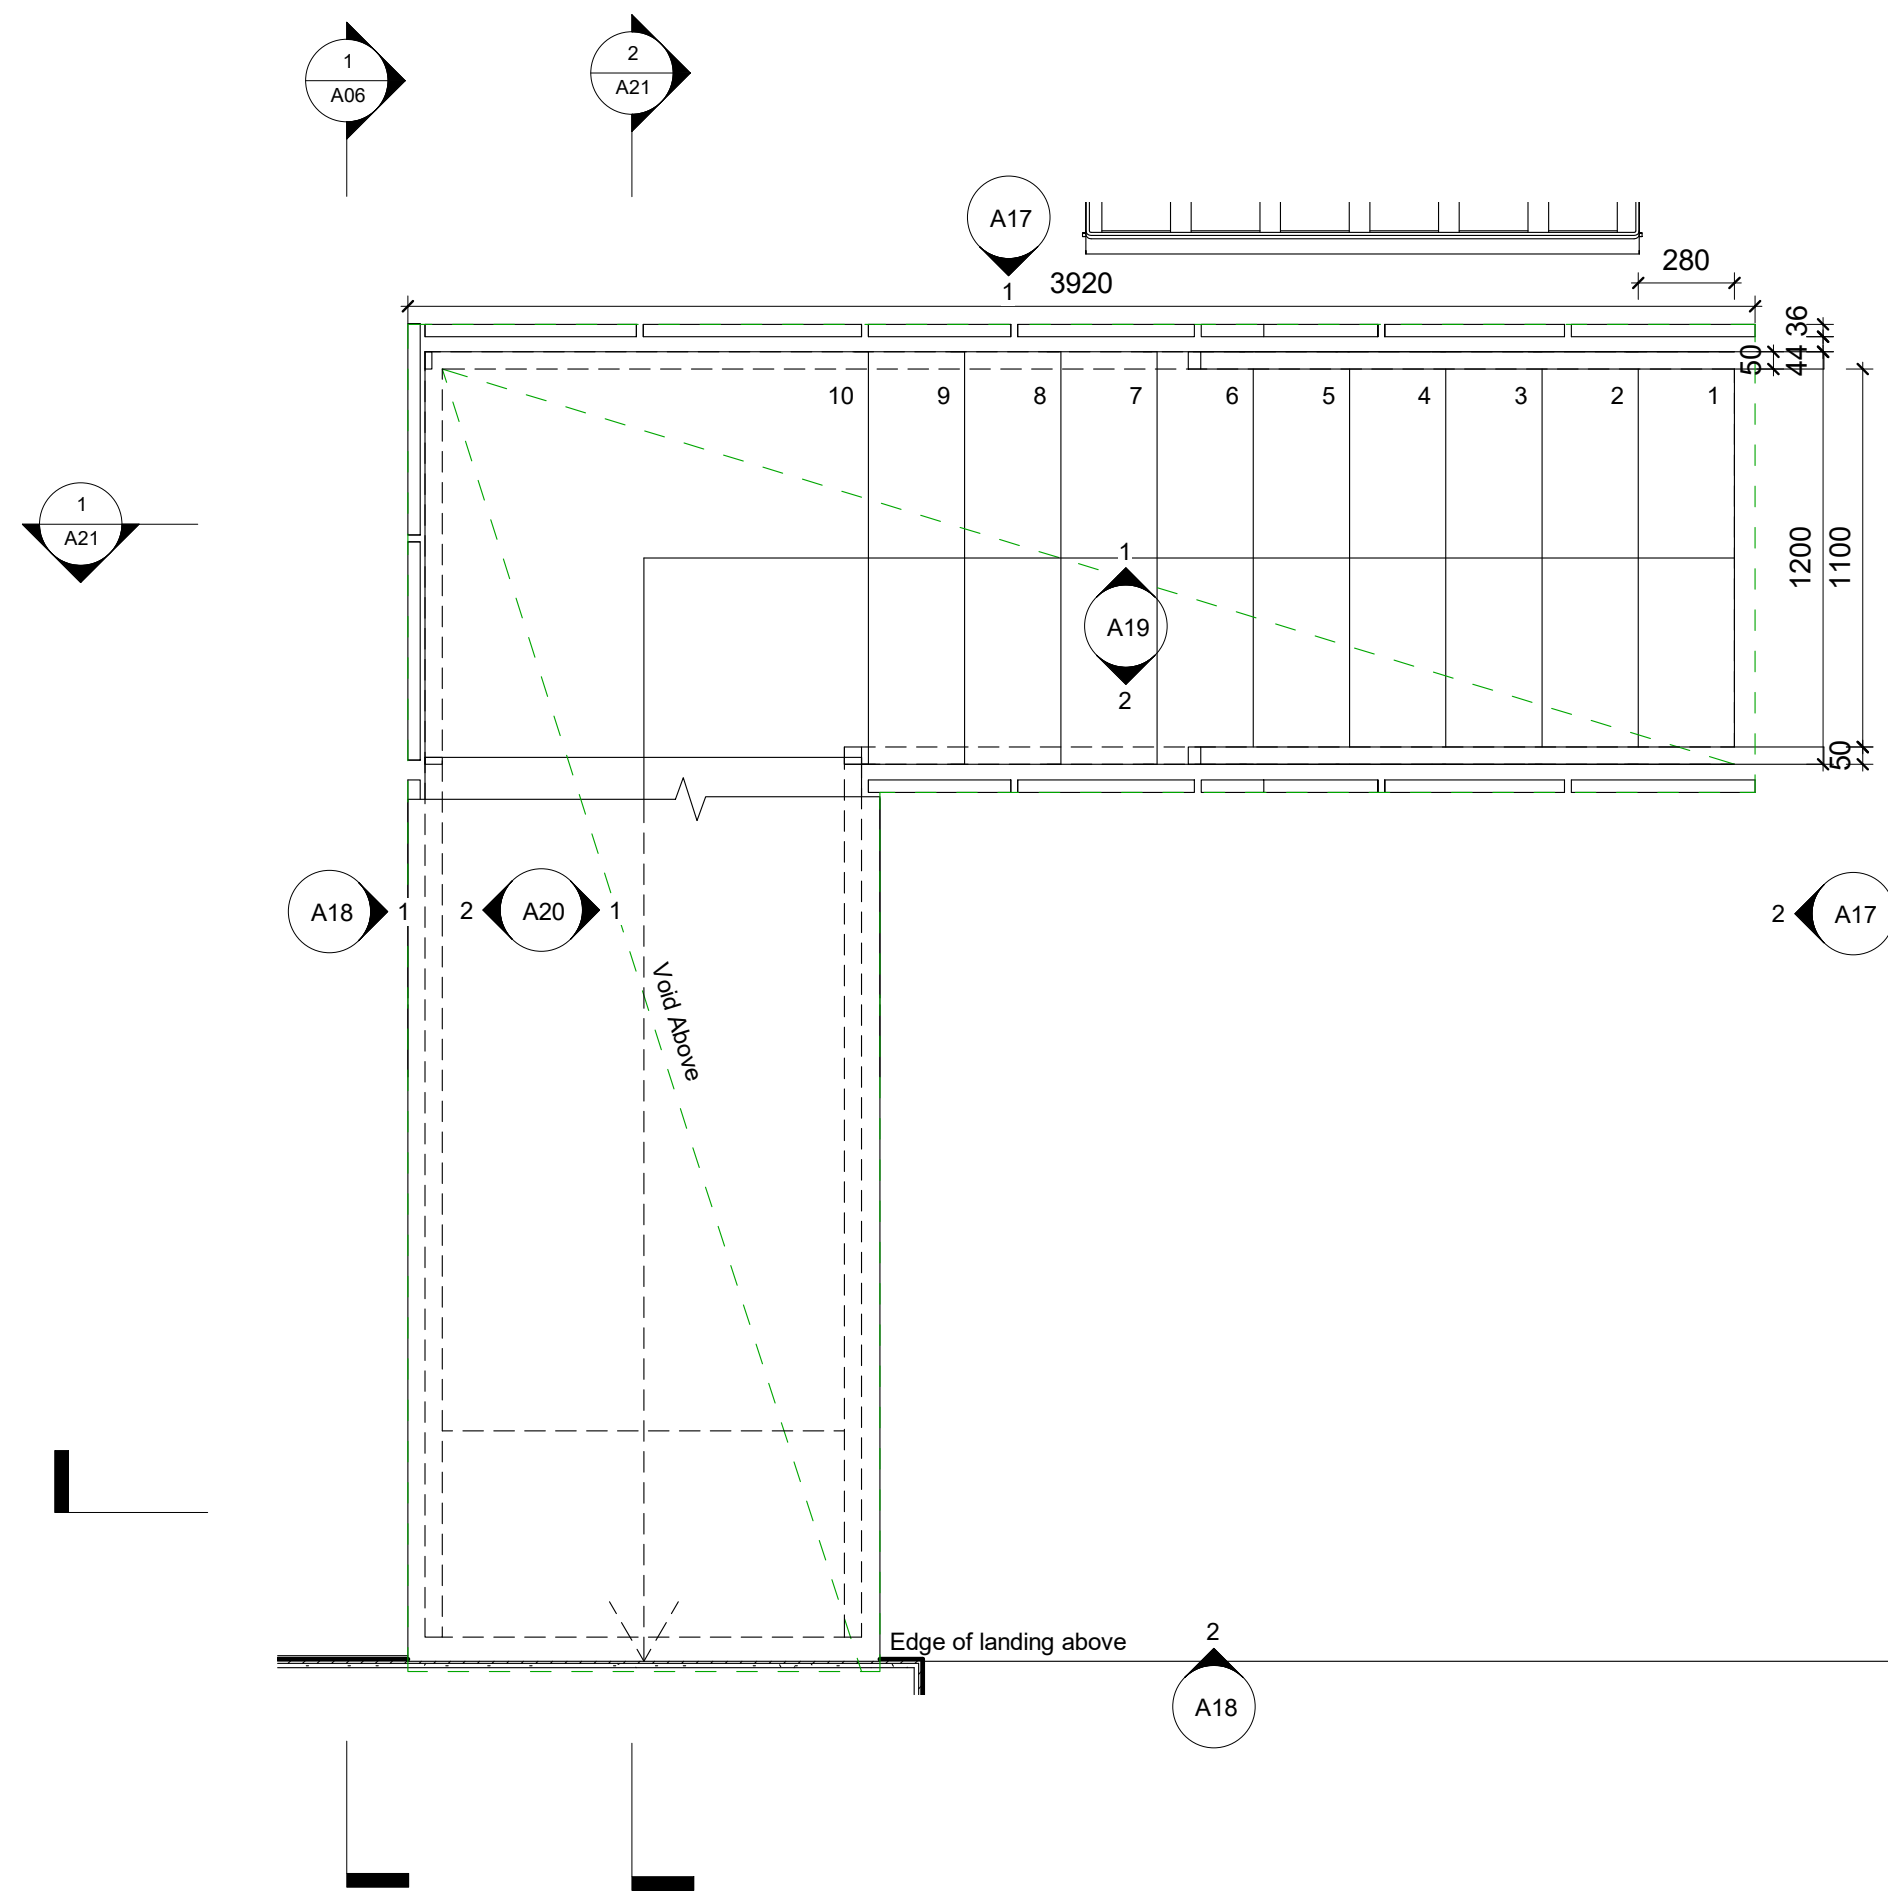

1 STAIR Detail Plan Lower
1 : 20

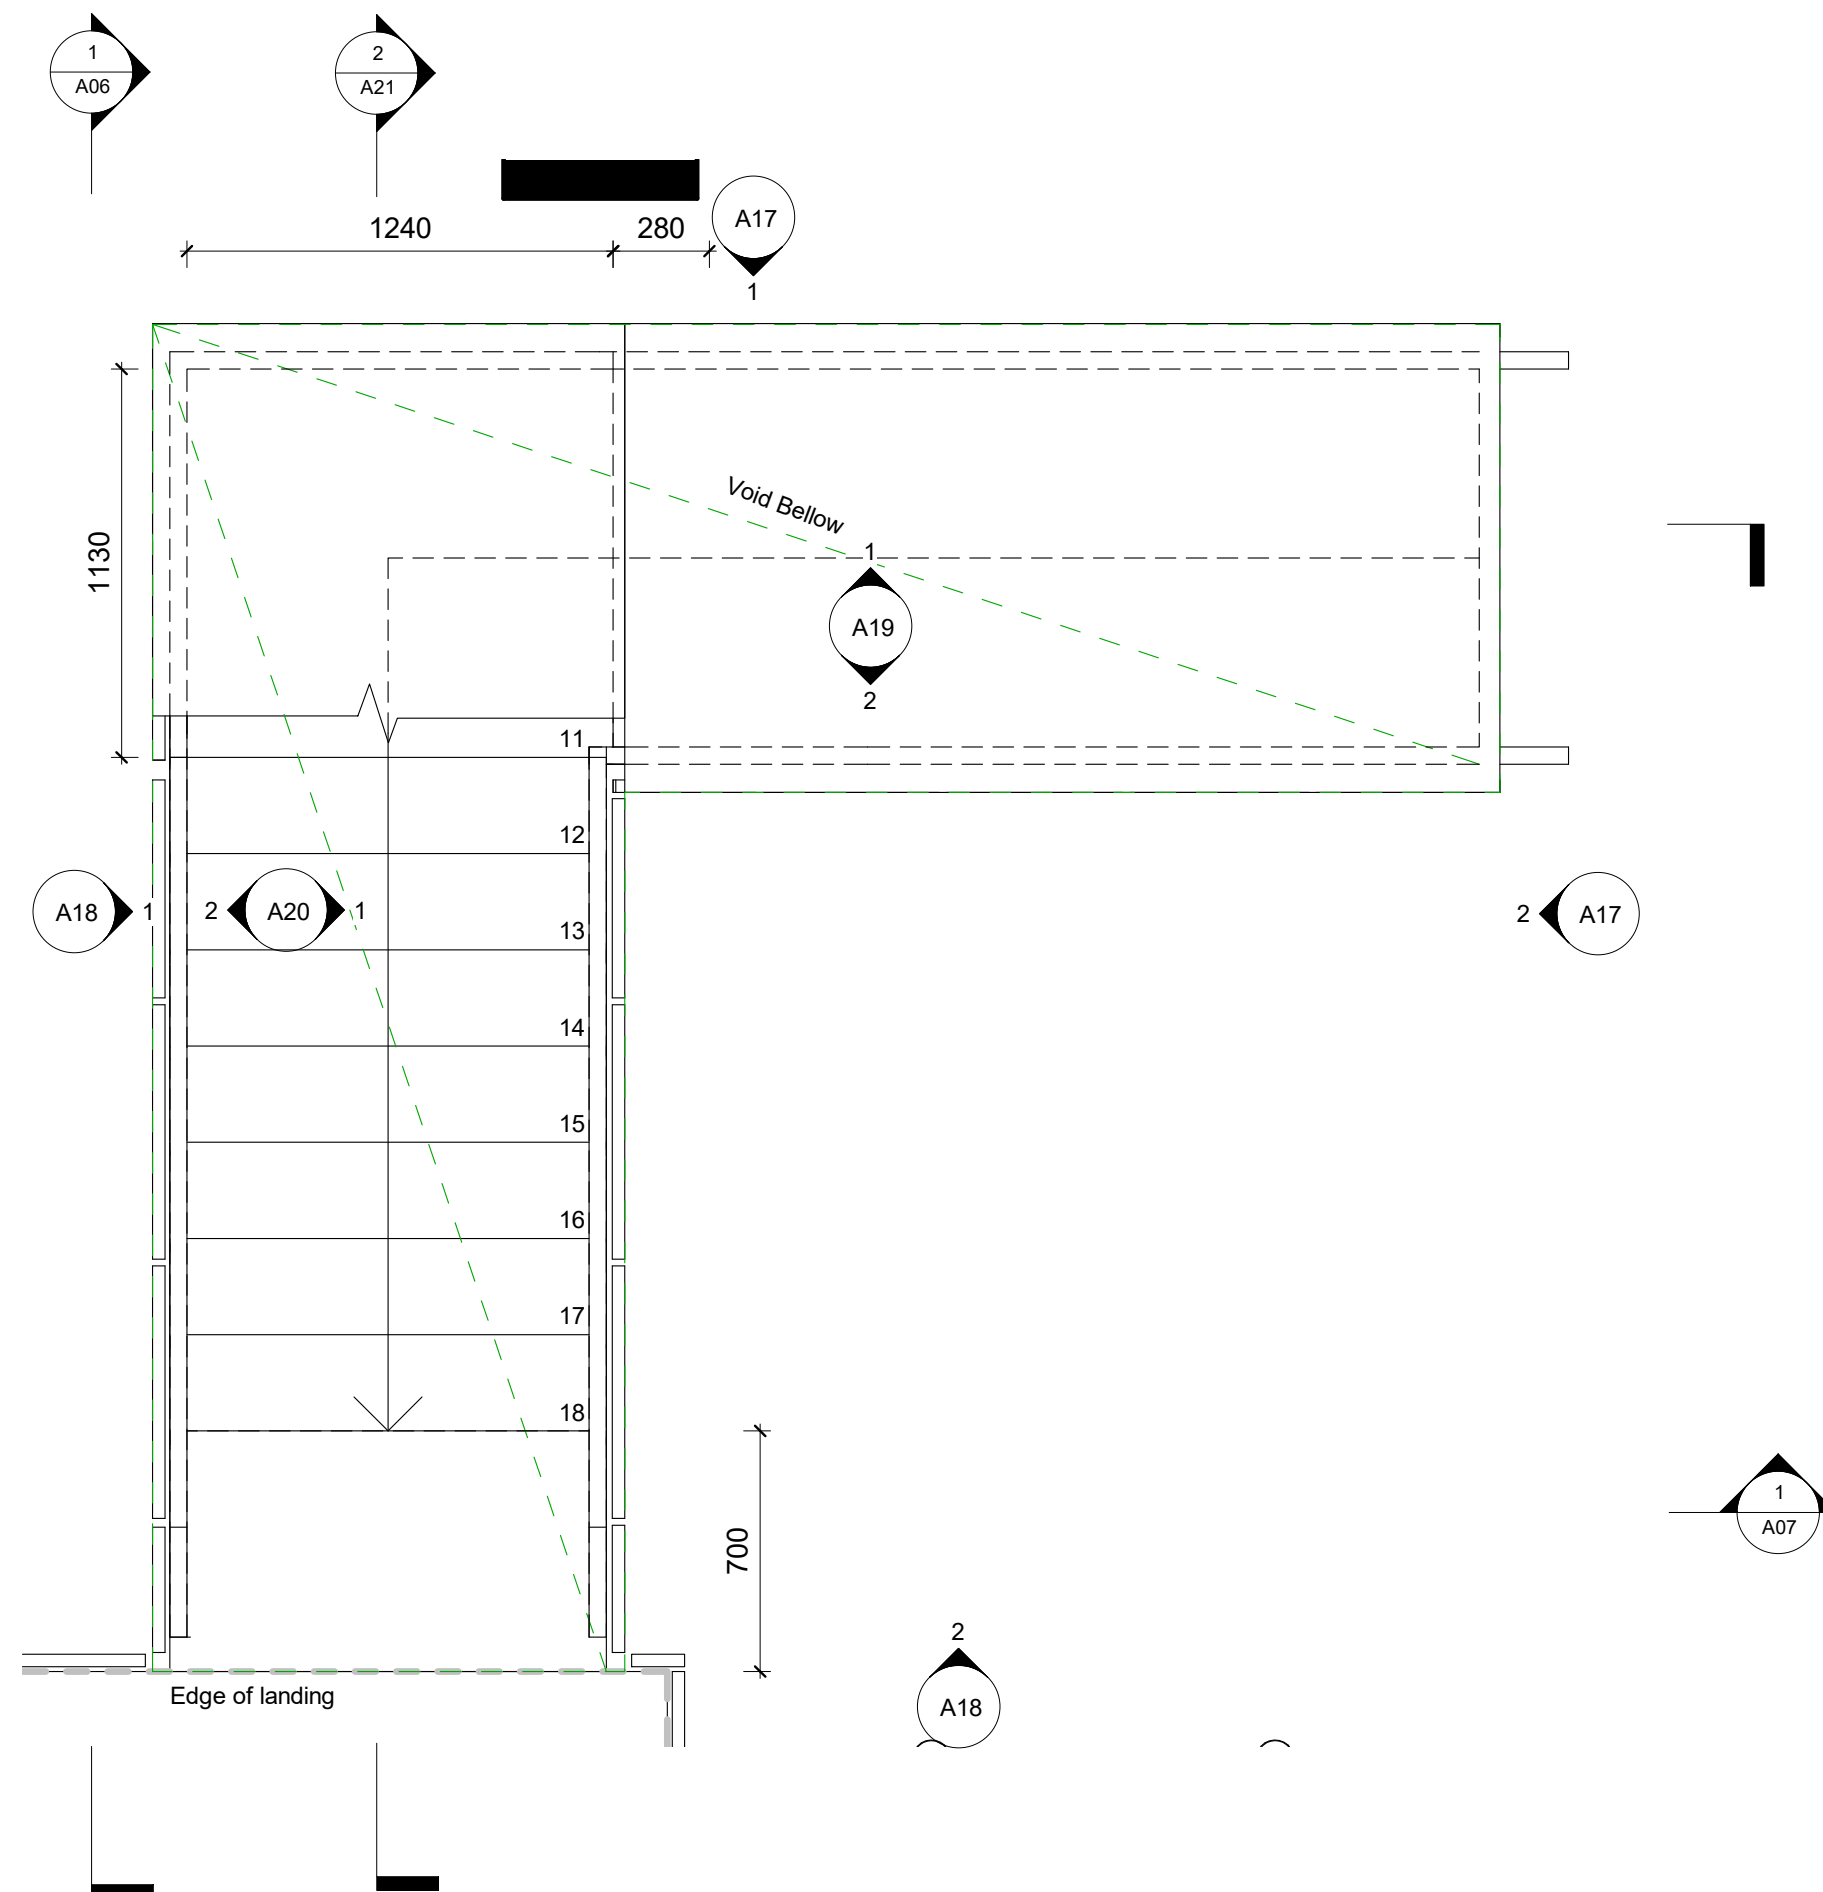

2 STAIR Detail Plan Upper
1 : 20

LEGEND

CUT PATTERN LEGEND

EXISTING	INSULATION
CONCRETE	EARTH
MDF	TILE
TIMBER	STEEL
ALUMINUM	

ABBREVIATIONS

FFL	Finished Floor Level	EQ	Specialty Equipment
FCL	Finished Ceiling Level	AP	Electrical Equipment
SE	Services	SA	Plumbing Fixture
MA	Material	LI	Lighting Fixture
FU	Furniture	WC	Water Closet

WALL TYPES


STW1	116mm Dry-Dry Wall 13mm Plaster Board, 90mm Timber Stud Frame13mm Plaster Board
STW2	116mm Wet-Dry Wall 13mm Plaster Board, 90mm Timber Stud Frame13mm Plaster Board, 2mm Glue, 10mm Tile
STW3	116mm Wet-Wet Wall 10mm Tile, 2mm Glue, 13mm Plaster Board, 90mm Timber Stud Frame13mm Plaster Board, 2mm Glue, 10mm Tile

DOOR AND WINDOW TAGS

D1	Door Tag	W1	Window Tag
----	----------	----	------------

Keynote Legend

 NOTES



No	Date	Description	Ver.	App'd
01	17.05.2019	PRESENTATION DRAWINGS		Approver

Do not scale drawings. Use figured dimensions only. Check and verify levels and dimensions on site prior to commencement of any work, the preparation of drawings or the fabrication of components.
This drawing is copyright and can not be reproduced without written consent.

Client
Sue & Andy Baker

Le Velo

True North




Billy Blue College of Design
46-52 Mountain Street, Ultimo, NSW 2007, Australia
+61 (0)2 9999 9999



Project
IDC302A Assessment Brief 2
46 Baywater Drive, Wentworth Point, NSW, 2127
Project number
Year. 2019

Drawing Title
STAIR LOWER & UPPER PLANS
Drawing Status
PRESENTATION DRAWINGS
NOT FOR CONSTRUCTION

Scale
1:20
Date
17.05.2019
Drawing No
A16
Issue
01
Drawn by
PMR

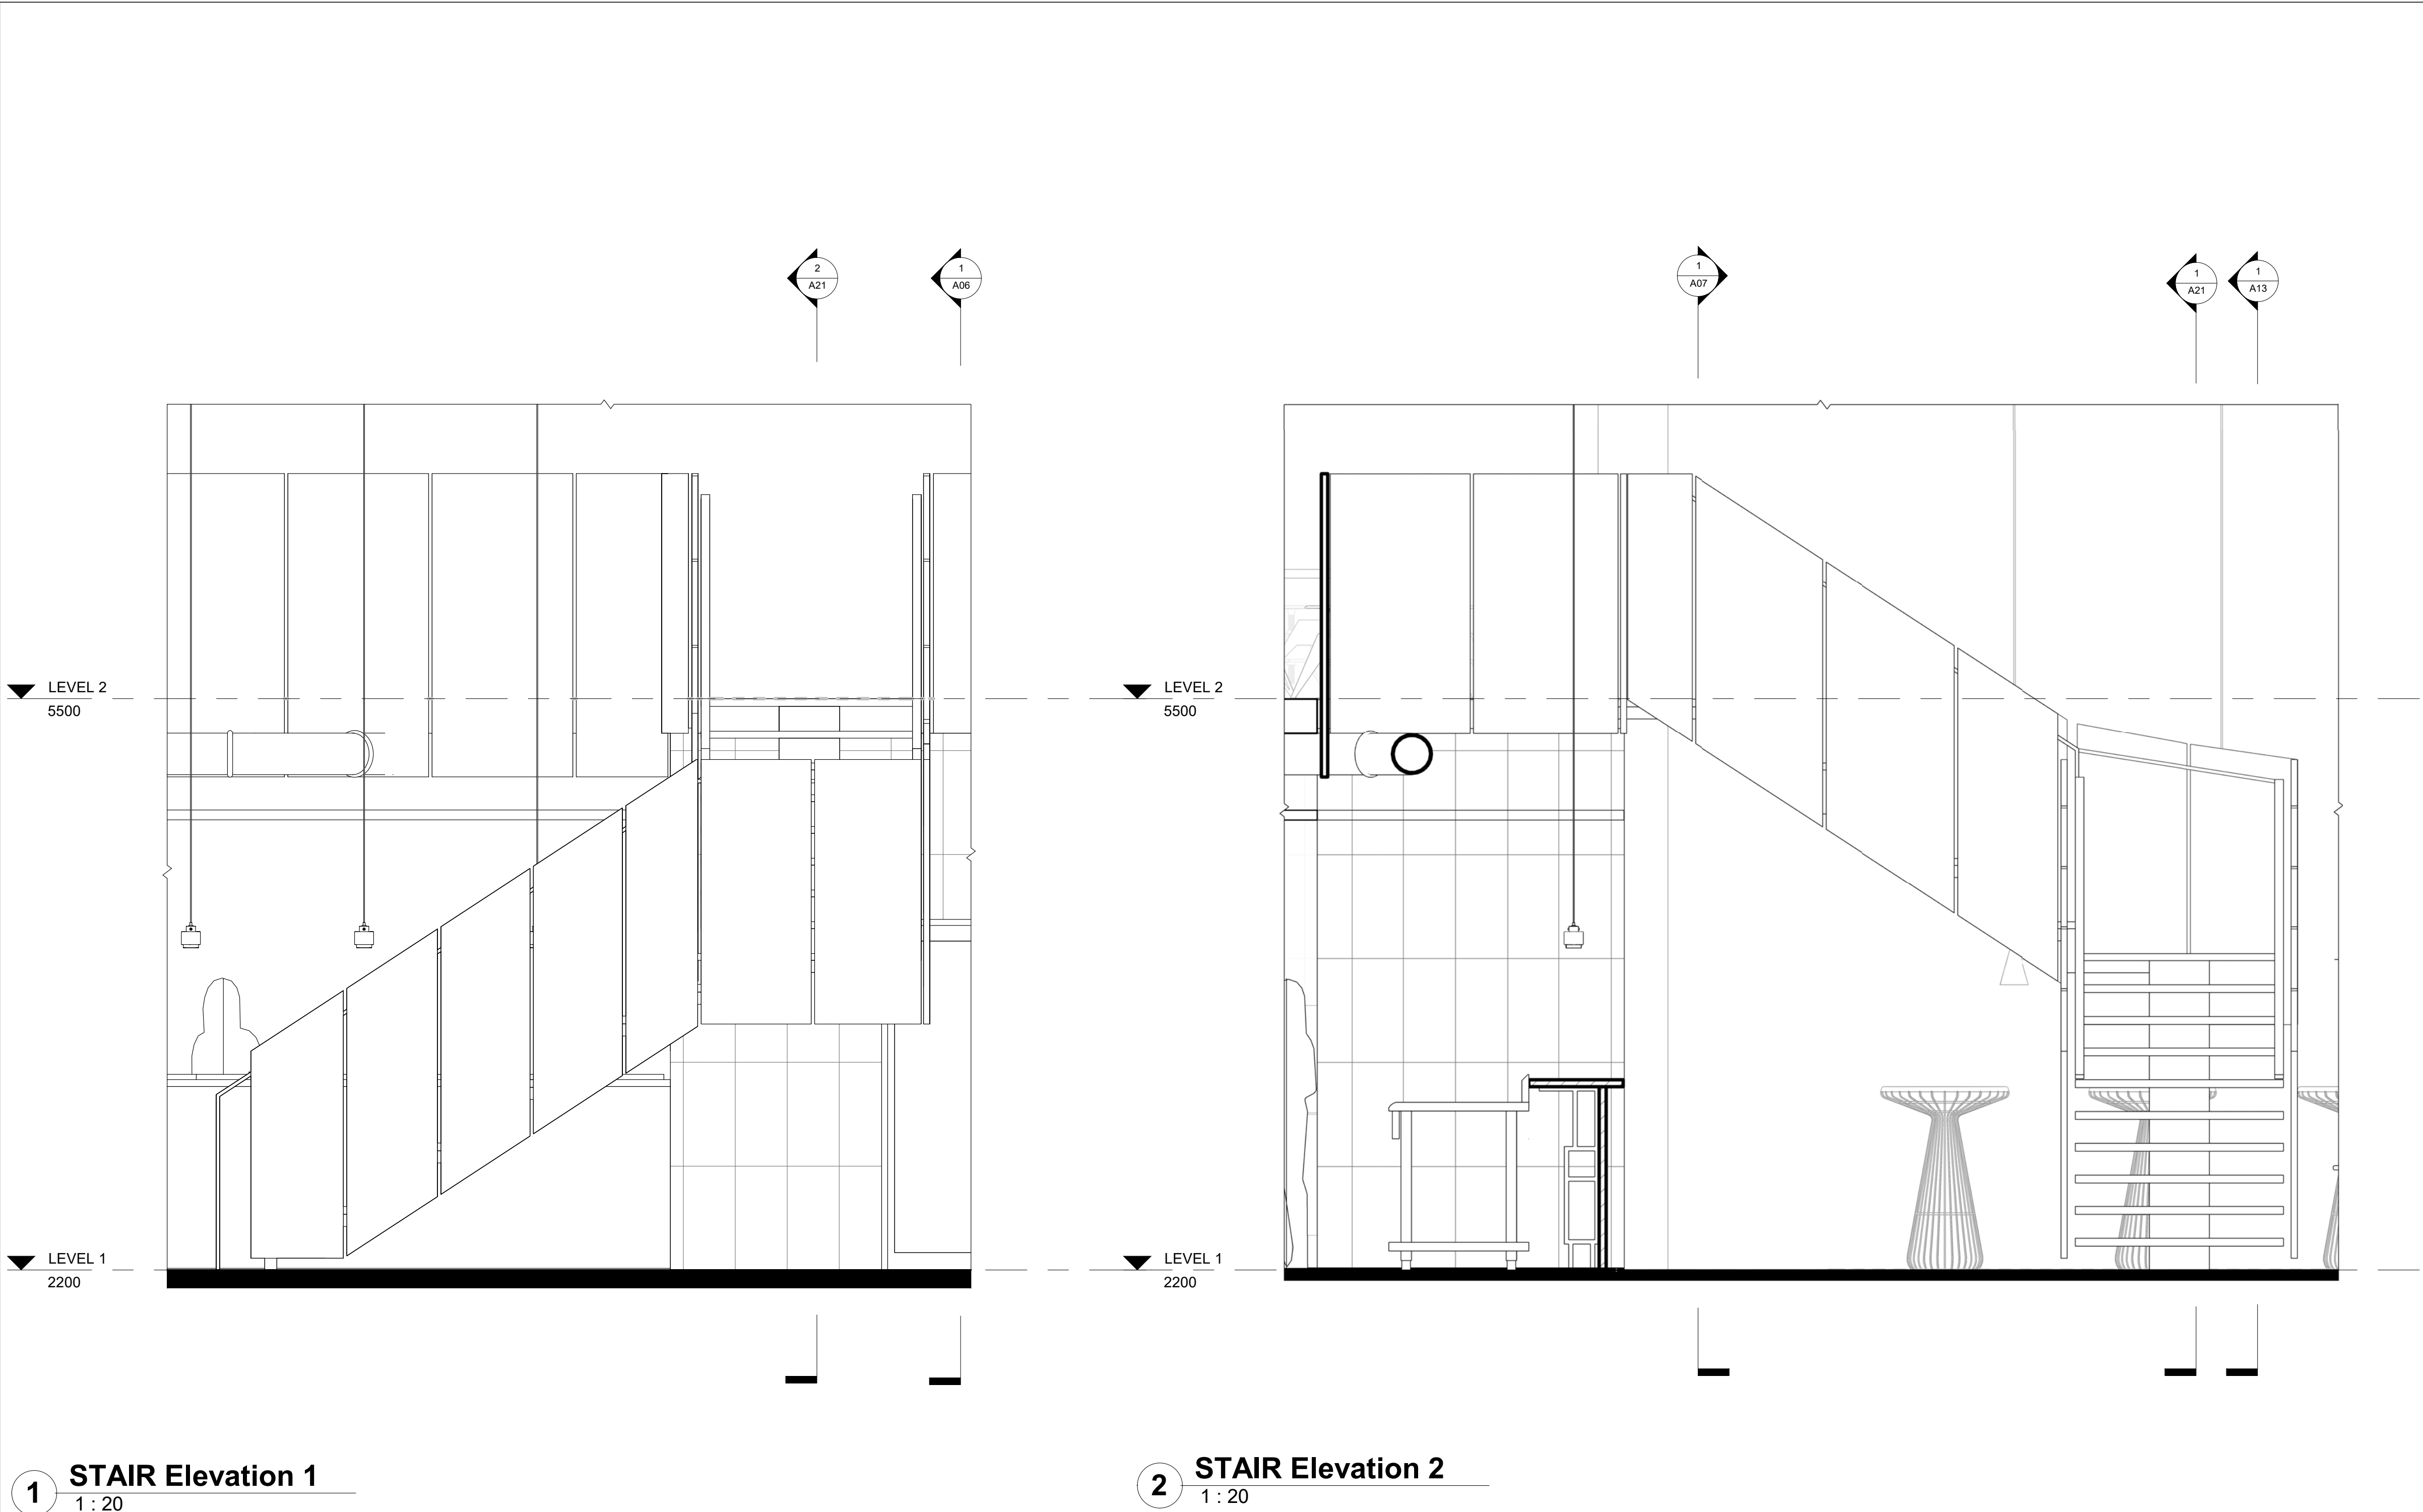

LEGEND

CUT PATTERN LEGEND

EXISTING		INSULATION	
CONCRETE		EARTH	
MDF		TILE	
TIMBER		STEEL	
ALUMINUM			

ABBREVIATIONS

FFL	Finished Floor Level	EQ	Specialty Equipment
FCL	Finished Ceiling Level	AP	Electrical Equipment
SE	Services	SA	Plumbing Fixture
MA	Material	LI	Lighting Fixture
FU	Furniture	WC	Water Closet

WALL TYPES

116mm Dry-Dry Wall
13mm Plaster Board, 90mm Timber Stud Frame13mm Plaster Board

116mm Wet-Dry Wall
13mm Plaster Board, 90mm Timber Stud Frame13mm Plaster Board, 2mm Glue, 10mm Tile

116mm Wet-Wet Wall
10mm Tile, 2mm Glue, 13mm Plaster Board, 90mm Timber Stud Frame13mm Plaster Board, 2mm Glue, 10mm Tile

DOOR AND WINDOW TAGS

 
D1 Door Tag

W1 Window Tag

Keynote Legend

1 STAIR Elevation 1
1 : 20

2 STAIR Elevation 2
1 : 20



Revisions		
No	Date	Description
01	17.05.2019	PRESENTATION DRAWINGS

Do not scale drawings. Use figured dimensions only. Check and verify levels and dimensions on site prior to commencement of any work, the preparation of drawings or the fabrication of components.
This drawing is copyright and can not be reproduced without written consent.

Client
Sue & Andy Baker


True North

Billy Blue College of Design
46-52 Mountain Street, Ultimo, NSW 2007, Australia
+61 (0)2 9999 9999


Project
IDC302A Assessment Brief 2
46 Baywater Drive, Wentworth Point, NSW, 2127
Project number
Year. 2019

Drawing Title
STAIR ELEVATIONS 1 & 2
Drawing Status
PRESENTATION DRAWINGS
NOT FOR CONSTRUCTION

Scale	Drawing No	Issue
1:20	A17	01
Date	17.05.2019	
Drawn by	PRM	

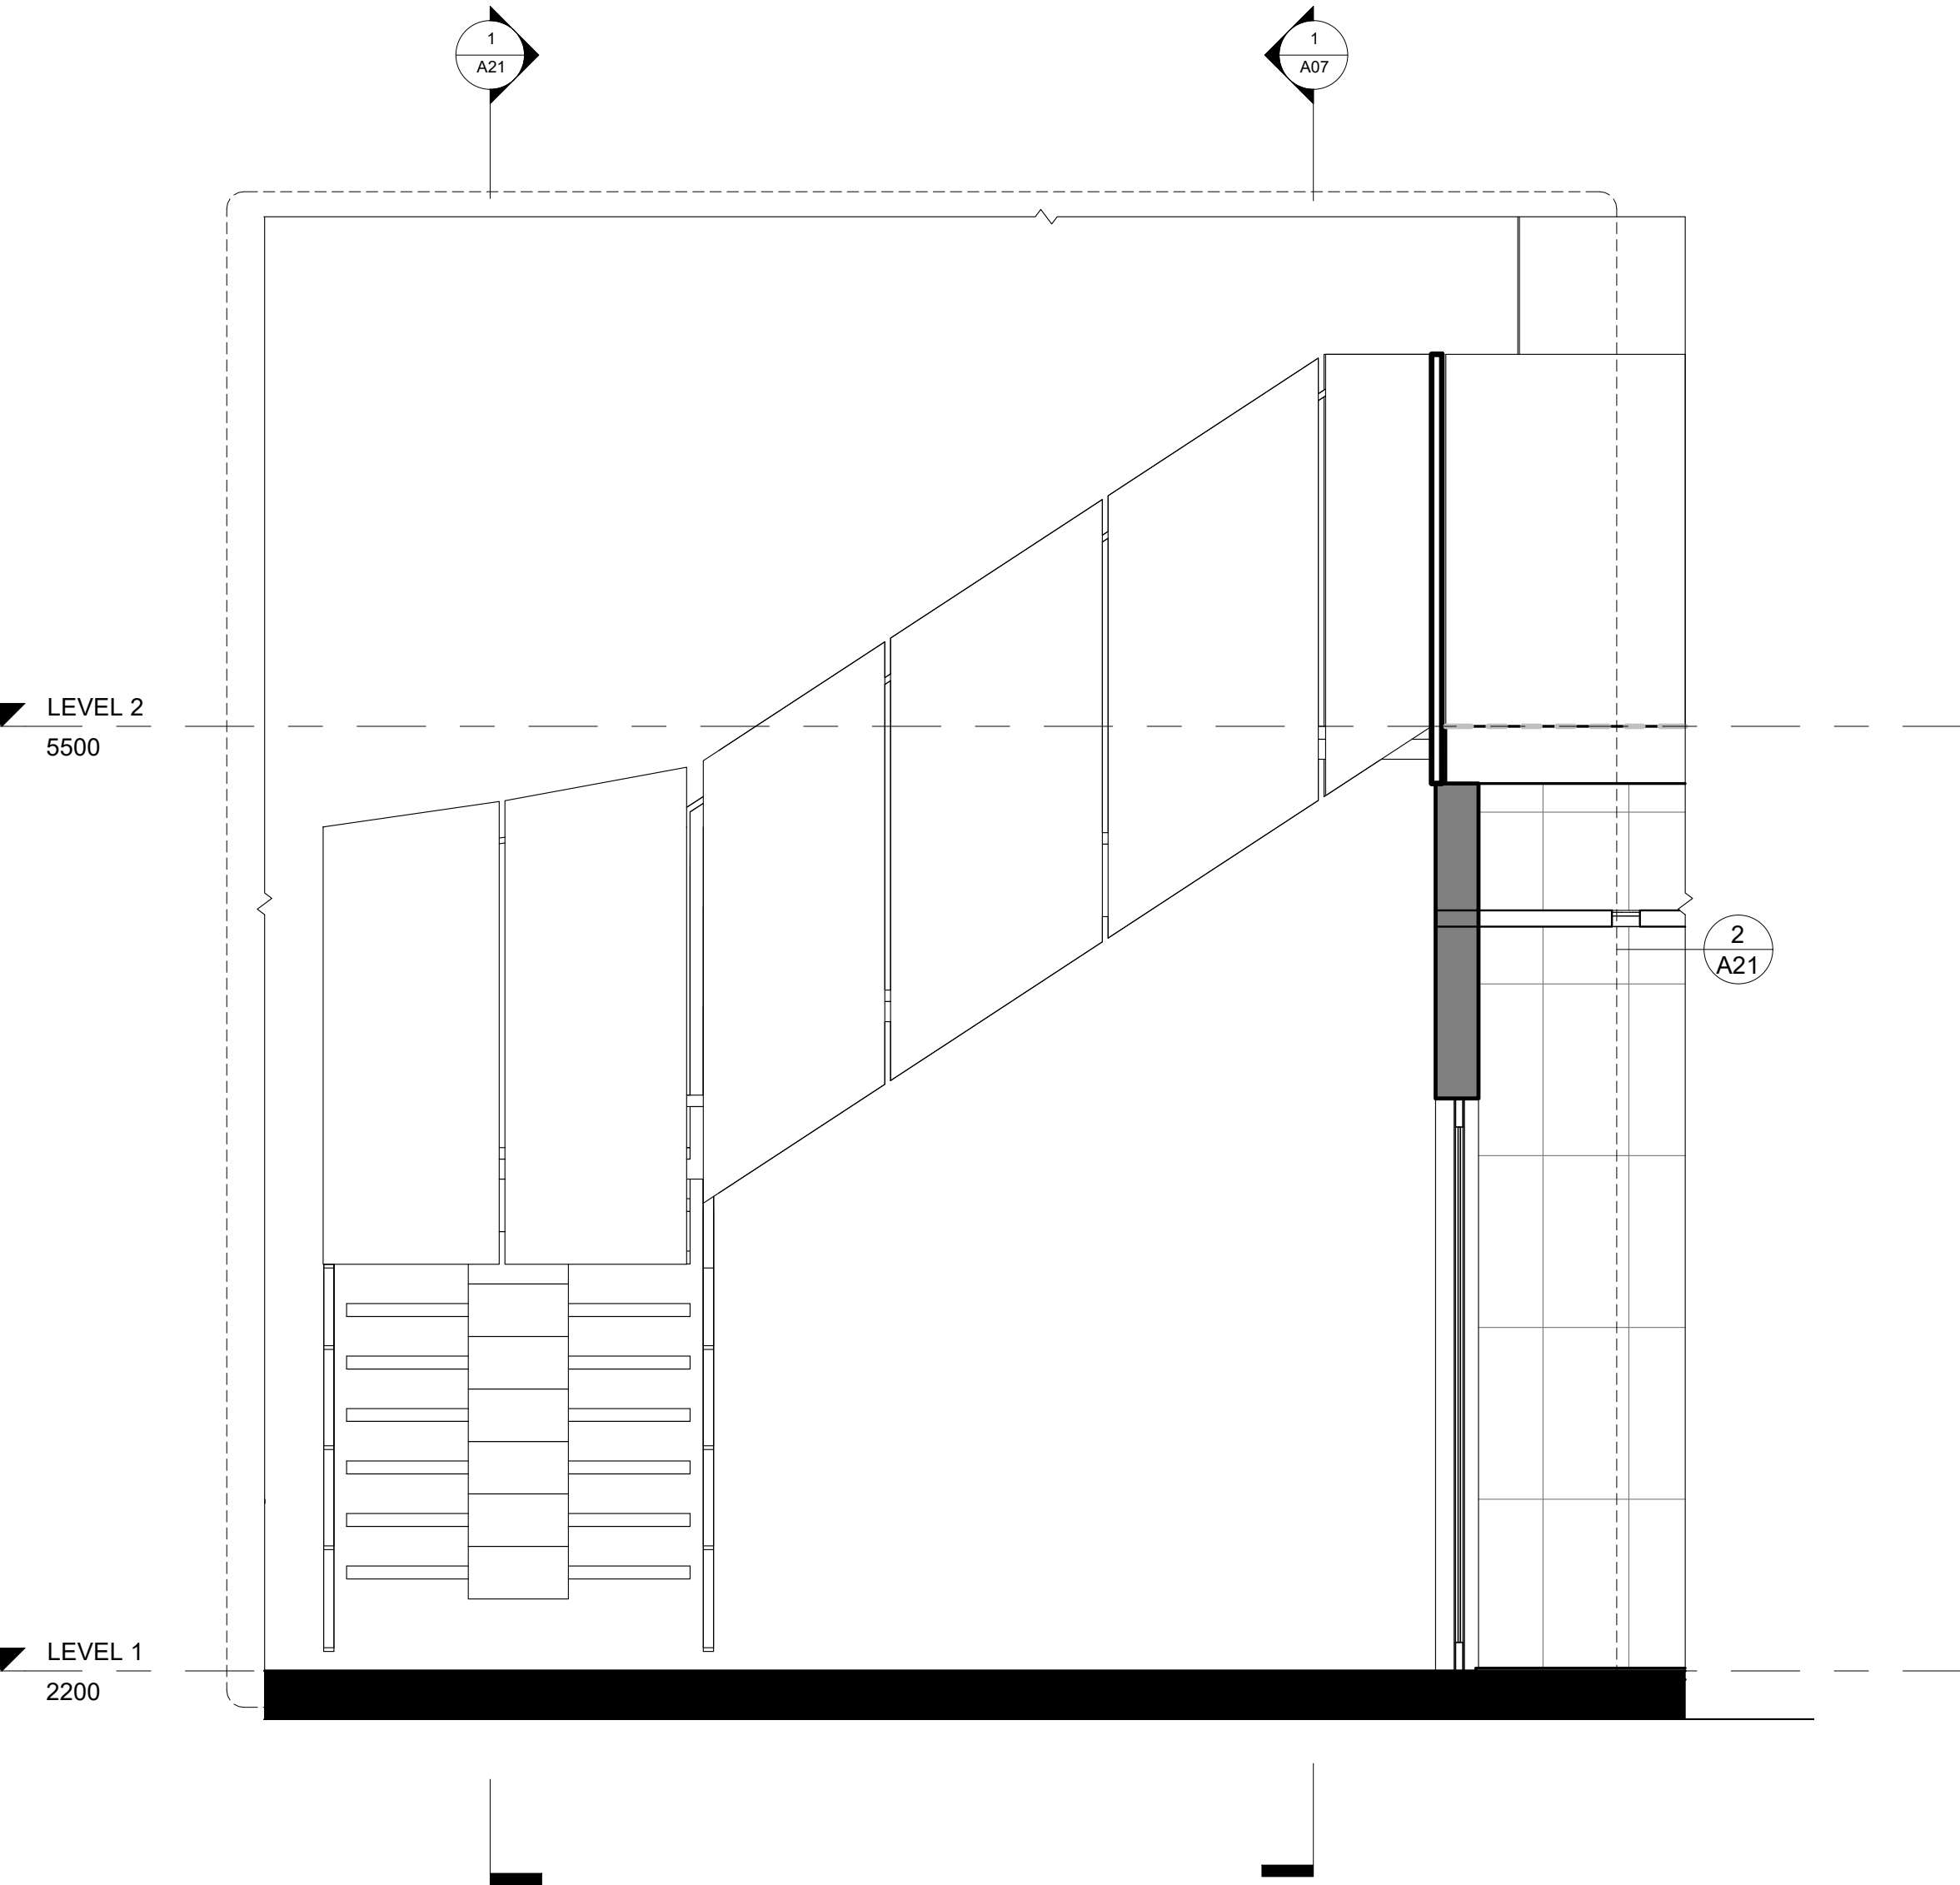

1 STAIR Elevation 3
1 : 20

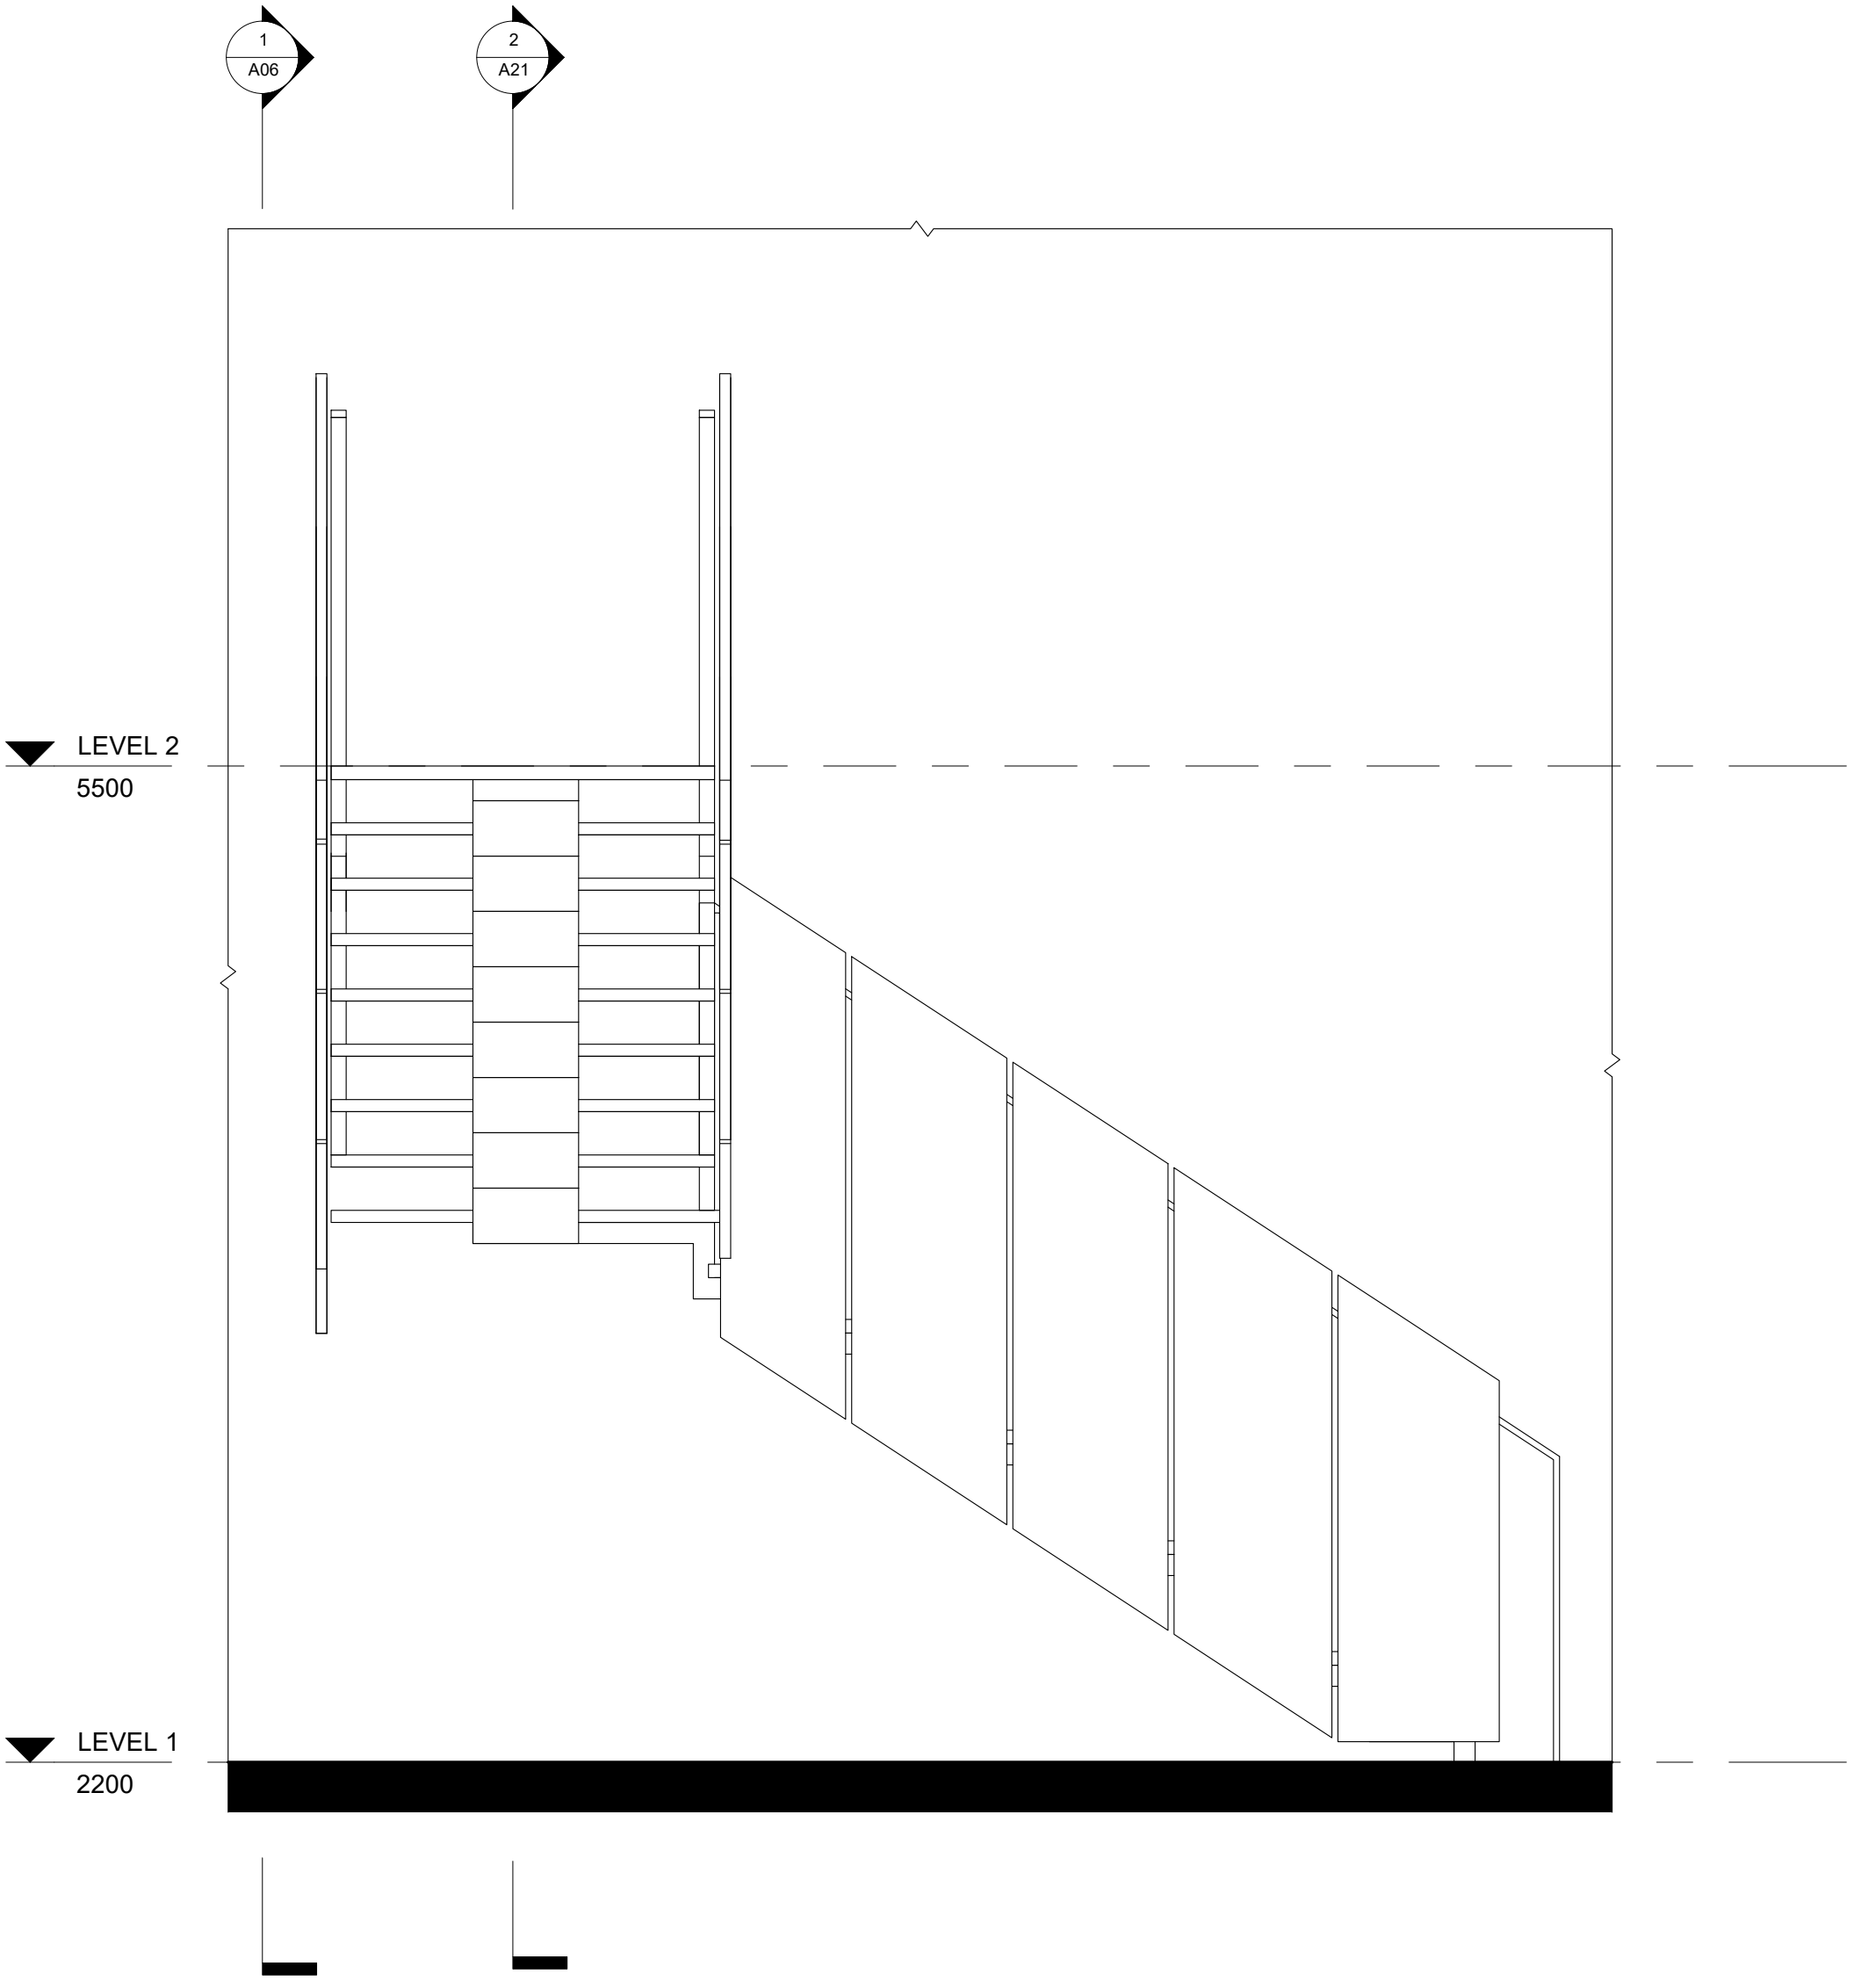

2 STAIR Elevation 4
1 : 20

LEGEND

CUT PATTERN LEGEND

EXISTING	INSULATION
CONCRETE	EARTH
MDF	TILE
TIMBER	STEEL
ALUMINUM	

ABBREVIATIONS

FFL	Finished Floor Level	EQ	Specialty Equipment
FCL	Finished Ceiling Level	AP	Electrical Equipment
SE	Services	SA	Plumbing Fixture
MA	Material	LI	Lighting Fixture
FU	Furniture	WC	Water Closet

WALL TYPES

STW1

116mm Dry-Dry Wall
13mm Plaster Board, 90mm Timber Stud
Frame 13mm Plaster Board

STW2

116mm Wet-Dry Wall
13mm Plaster Board, 90mm Timber Stud
Frame 13mm Plaster Board, 2mm Glue,
10mm Tile

STW3

116mm Wet-Wet Wall
10mm Tile, 2mm Glue, 13mm Plaster
Board, 90mm Timber Stud Frame 13mm
Plaster Board, 2mm Glue, 10mm Tile

DOOR AND WINDOW TAGS

D1

 
Door Tag

W1


Window Tag

Keynote Legend

NOTES



Revisions			Do not scale drawings. Use figured dimensions only. Check and verify levels and dimensions on site prior to commencement of any work, the preparation of drawings or the fabrication of components. This drawing is copyright and can not be reproduced without written consent.	Client Sue & Andy Baker	True North	Billy Blue College of Design 46-52 Mountain Street, Ultimo, NSW 2007, Australia +61 (0)2 9999 9999 <
-----------	--	--	---	----------------------------	------------	---

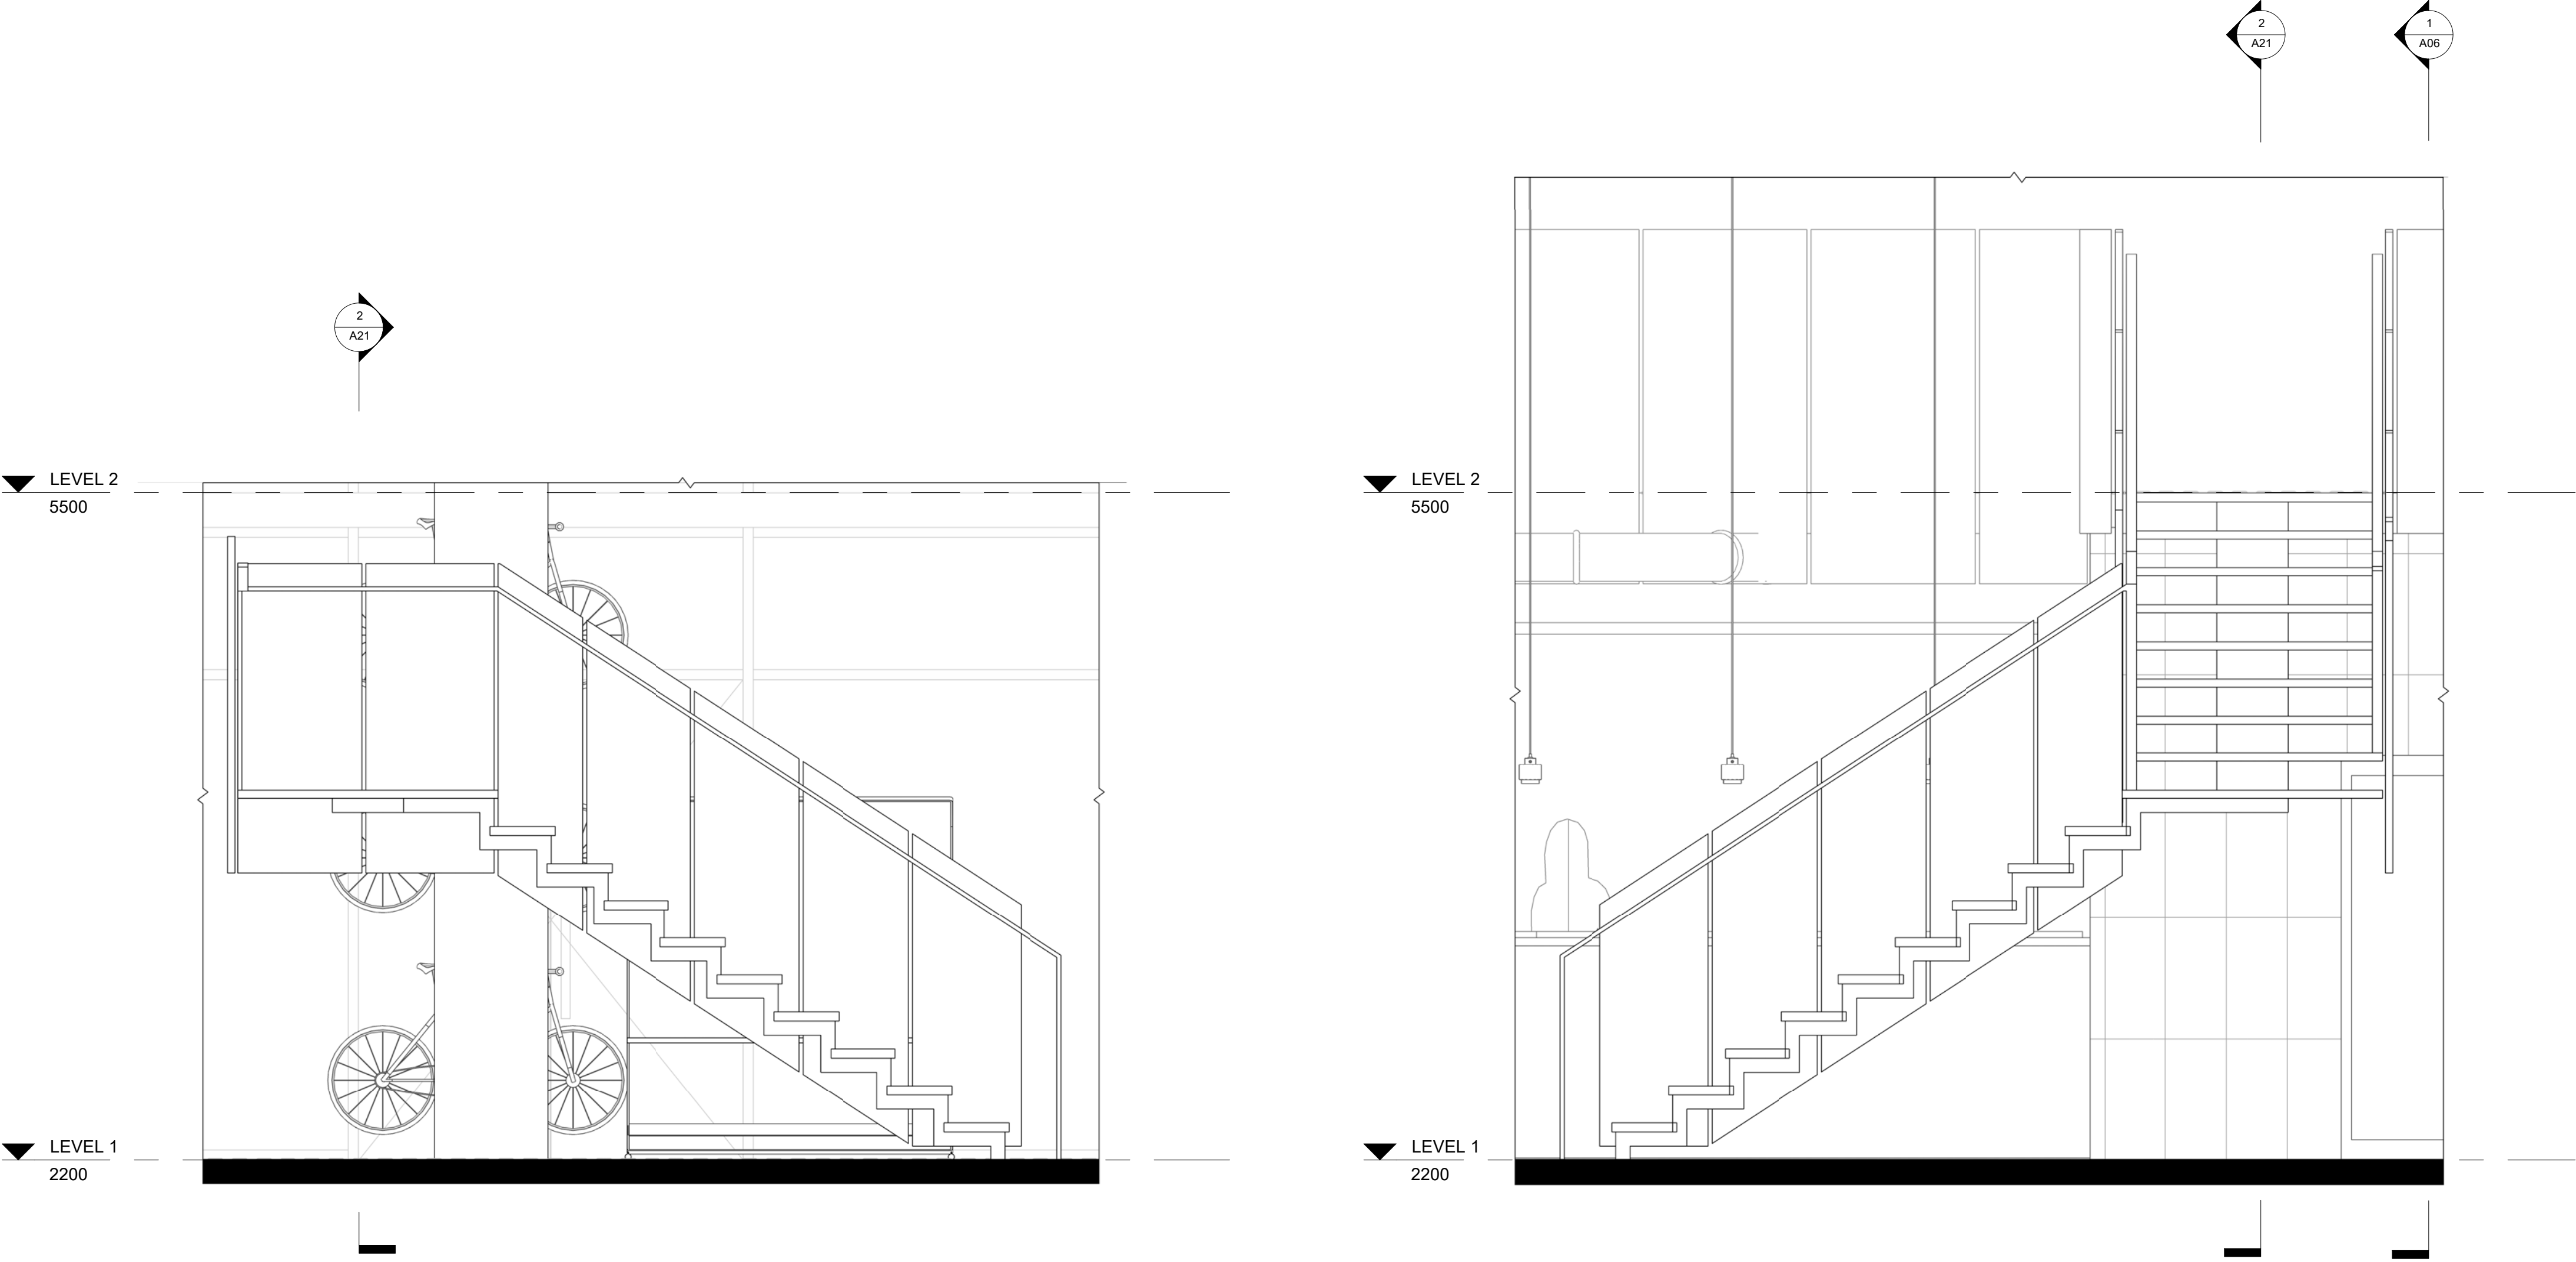

1 STAIR Elevation 5
1 : 20

2 STAIR Elevation 6
1 : 20

LEGEND

CUT PATTERN LEGEND

EXISTING	INSULATION
CONCRETE	EARTH
MDF	TILE
TIMBER	STEEL
ALUMINUM	

ABBREVIATIONS

FFL	Finished Floor Level	EQ	Specialty Equipment
FCL	Finished Ceiling Level	AP	Electrical Equipment
SE	Services	SA	Plumbing Fixture
MA	Material	LI	Lighting Fixture
FU	Furniture	WC	Water Closet

WALL TYPES

STW1

116mm Dry-Dry Wall
13mm Plaster Board, 90mm Timber Stud
Frame13mm Plaster Board

STW2

116mm Wet-Dry Wall
13mm Plaster Board, 90mm Timber Stud
Frame13mm Plaster Board, 2mm Glue,
10mm Tile

STW3

116mm Wet-Wet Wall
10mm Tile, 2mm Glue, 13mm Plaster
Board, 90mm Timber Stud Frame13mm
Plaster Board, 2mm Glue, 10mm Tile

DOOR AND WINDOW TAGS

D1

Door Tag

W1


Window Tag

Keynote Legend

NOTES



Revisions			Do not scale drawings. Use figured dimensions only. Check and verify levels and dimensions on site prior to commencement of any work, the preparation of drawings or the fabrication of components. This drawing is copyright and can not be reproduced without written consent.	Client Sue & Andy Baker Le Velo	True North	Billy Blue College of Design 46-52 Mountain Street, Ultimo, NSW 2007, Australia +61 (0)2 9999 9999 BILLY BLUE COLLEGE OF DESIGN TORRENS UNIVERSITY AUSTRALIA	Project IDC302A Assessment Brief 2 46 Baywater Drive, Wentworth Point, NSW, 2127 Project number Year. 2019	Drawing Title STAIR ELEVATION 5 & 6 Drawing Status PRESENTATION DRAWINGS NOT FOR CONSTRUCTION	Scale	Drawing No	Issue
No	Date	Description	Ver. App'd						1:20	A19	01
01	17.05.2019	PRESENTATION DRAWINGS	Approver						Date	17.05.2019	
									Drawn by	PRM	

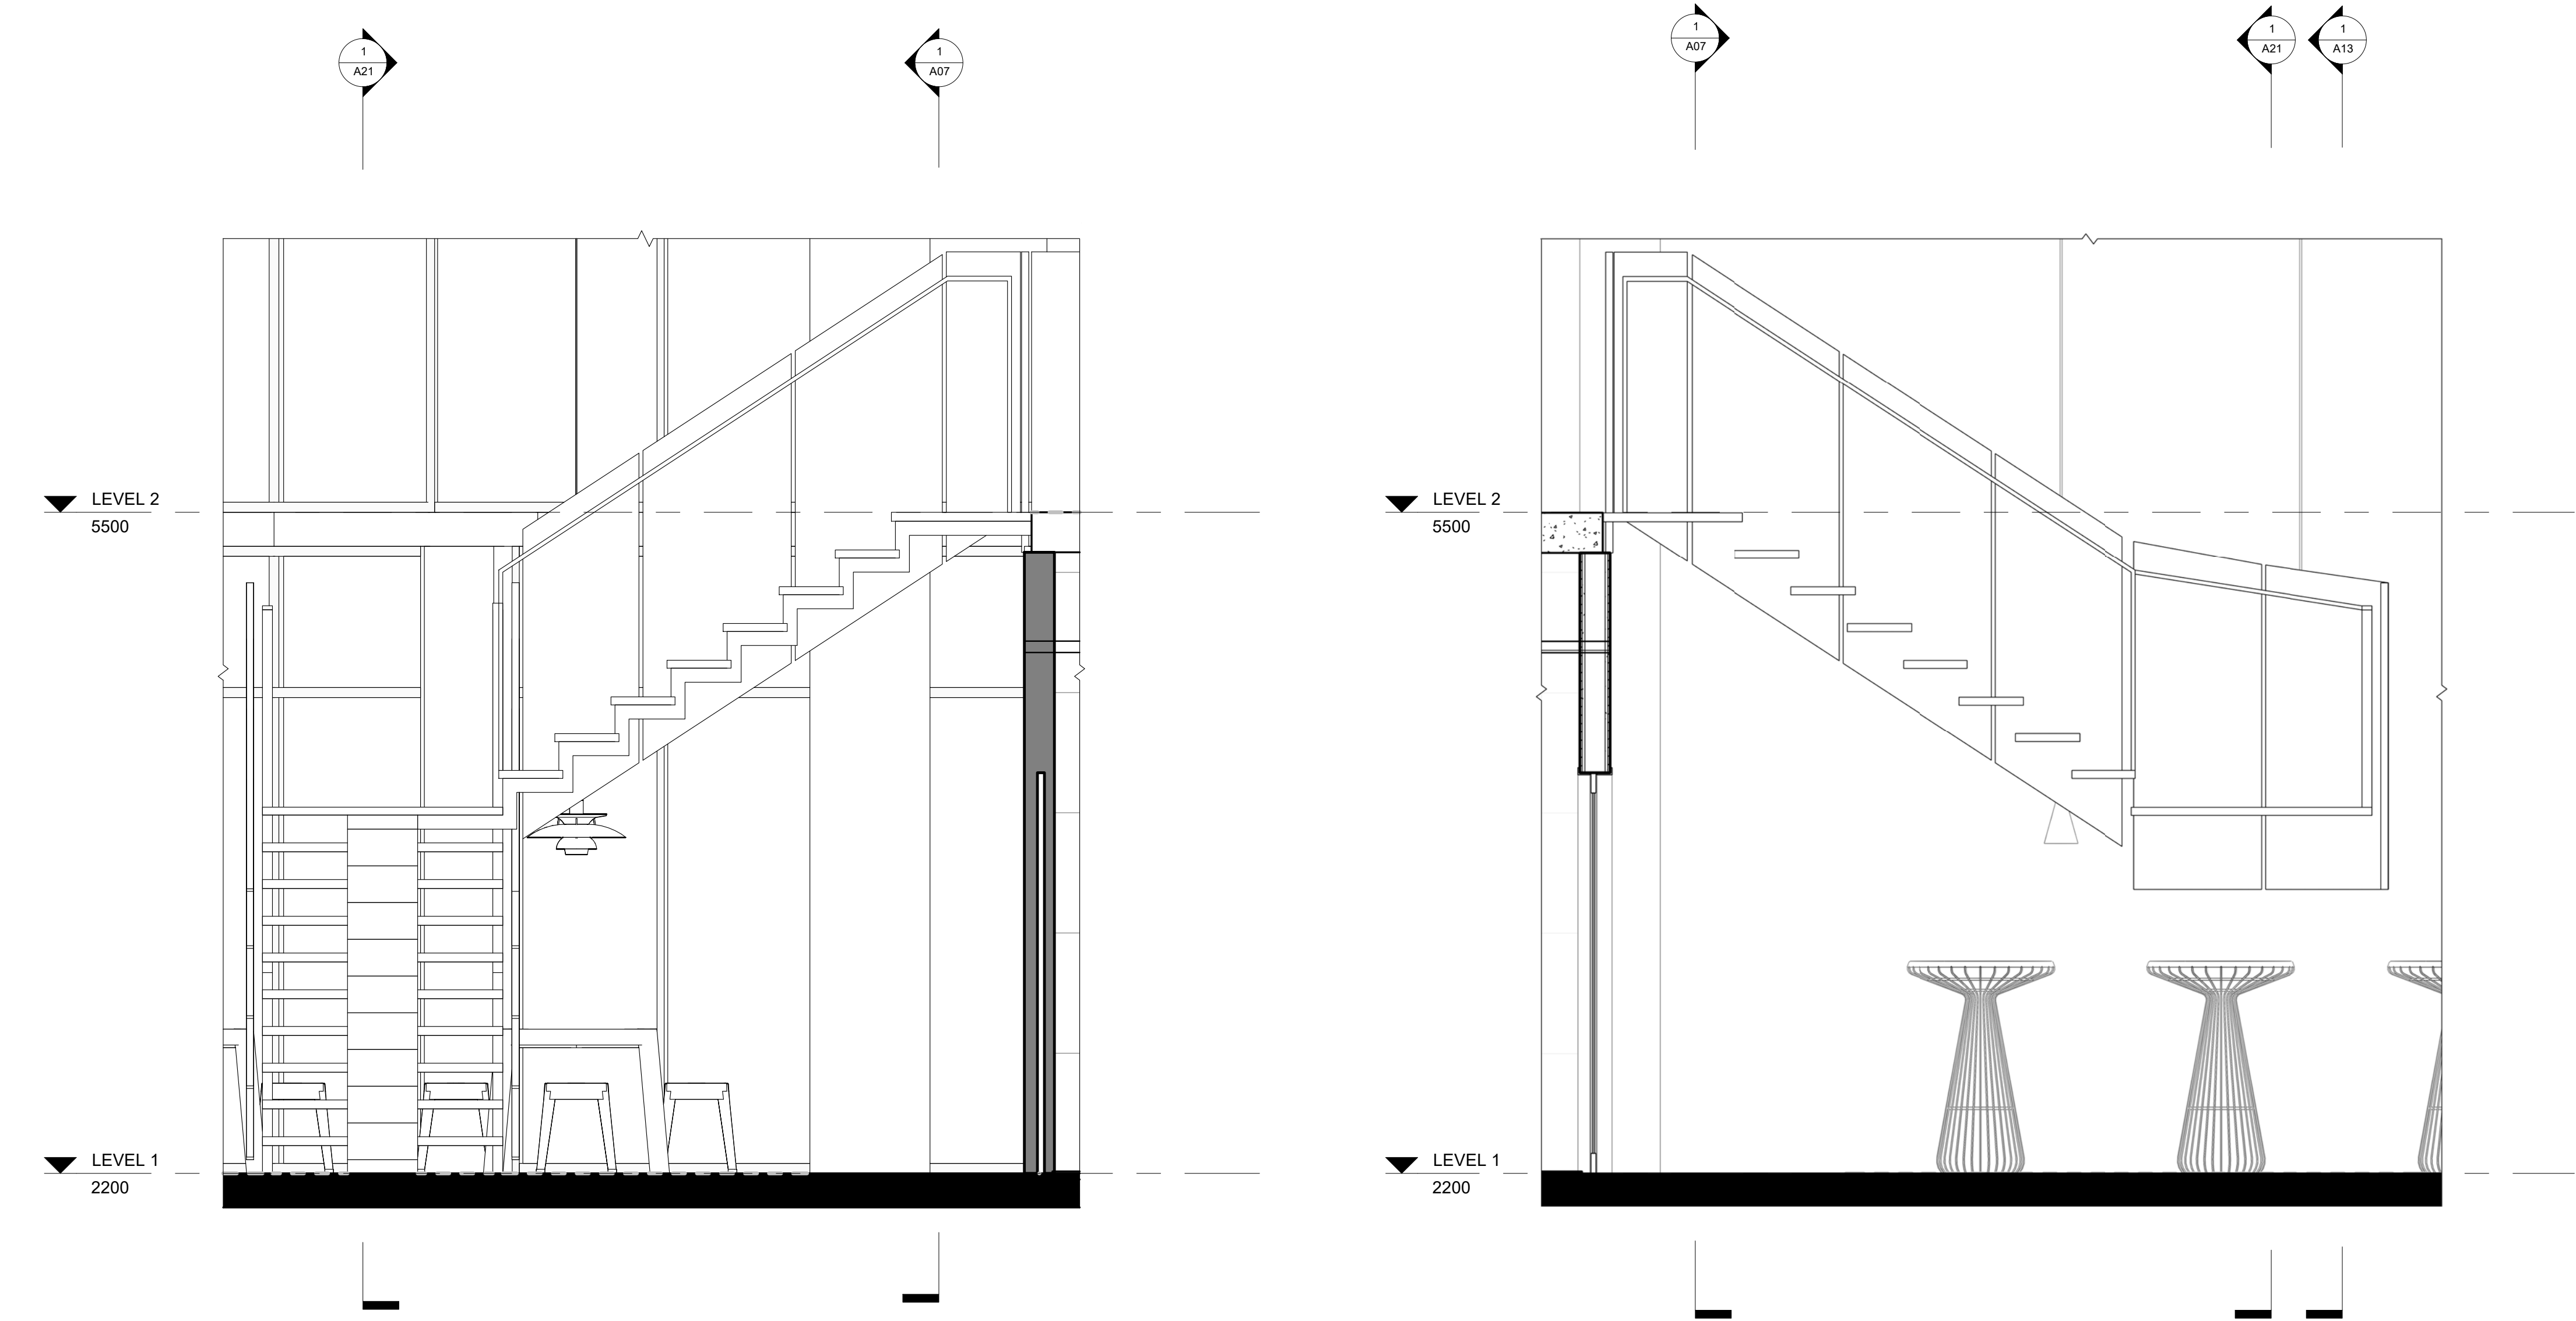

1 STAIR Elevation 7
1 : 20

2 STAIR Elevation 8
1 : 20

LEGEND

CUT PATTERN LEGEND

EXISTING		INSULATION	
CONCRETE		EARTH	
MDF		TILE	
TIMBER		STEEL	
ALUMINUM			

ABBREVIATIONS

FFL	Finished Floor Level	EQ	Specialty Equipment
FCL	Finished Ceiling Level	AP	Electrical Equipment
SE	Services	SA	Plumbing Fixture
MA	Material	LI	Lighting Fixture
FU	Furniture	WC	Water Closet

WALL TYPES

STW1

116mm Dry-Dry Wall
13mm Plaster Board, 90mm Timber Stud
Frame 13mm Plaster Board

STW2

116mm Wet-Dry Wall
13mm Plaster Board, 90mm Timber Stud
Frame 13mm Plaster Board, 2mm Glue,
10mm Tile

STW3

116mm Wet-Wet Wall
10mm Tile, 2mm Glue, 13mm Plaster
Board, 90mm Timber Stud Frame 13mm
Plaster Board, 2mm Glue, 10mm Tile

DOOR AND WINDOW TAGS

D1

Door Tag

W1

Window Tag


Keynote Legend

NOTES


0 0.1 0.2 0.5 1.0

m

Revisions			Do not scale drawings. Use figured dimensions only. Check and verify levels and dimensions on site prior to commencement of any work, the preparation of drawings or the fabrication of components. This drawing is copyright and can not be reproduced without written consent.	Client Sue & Andy Baker 	True North	 BILLY BLUE COLLEGE OF DESIGN  TORRENS UNIVERSITY AUSTRALIA  LAUREATE INTERNATIONAL UNIVERSITIES	Project IDC302A Assessment Brief 2 46 Baywater Drive, Wentworth Point, NSW, 2127 Project number Year. 2019	Drawing Title STAIR ELEVATION 7 & 8 Drawing Status PRESENTATION DRAWINGS NOT FOR CONSTRUCTION	Scale	Drawing No	Issue	
No	Date	Description							Ver. App'd	1:20	A20	01
01	17.05.2019	PRESENTATION DRAWINGS							Approver	Date	17.05.2019	
										Drawn by	PRM	

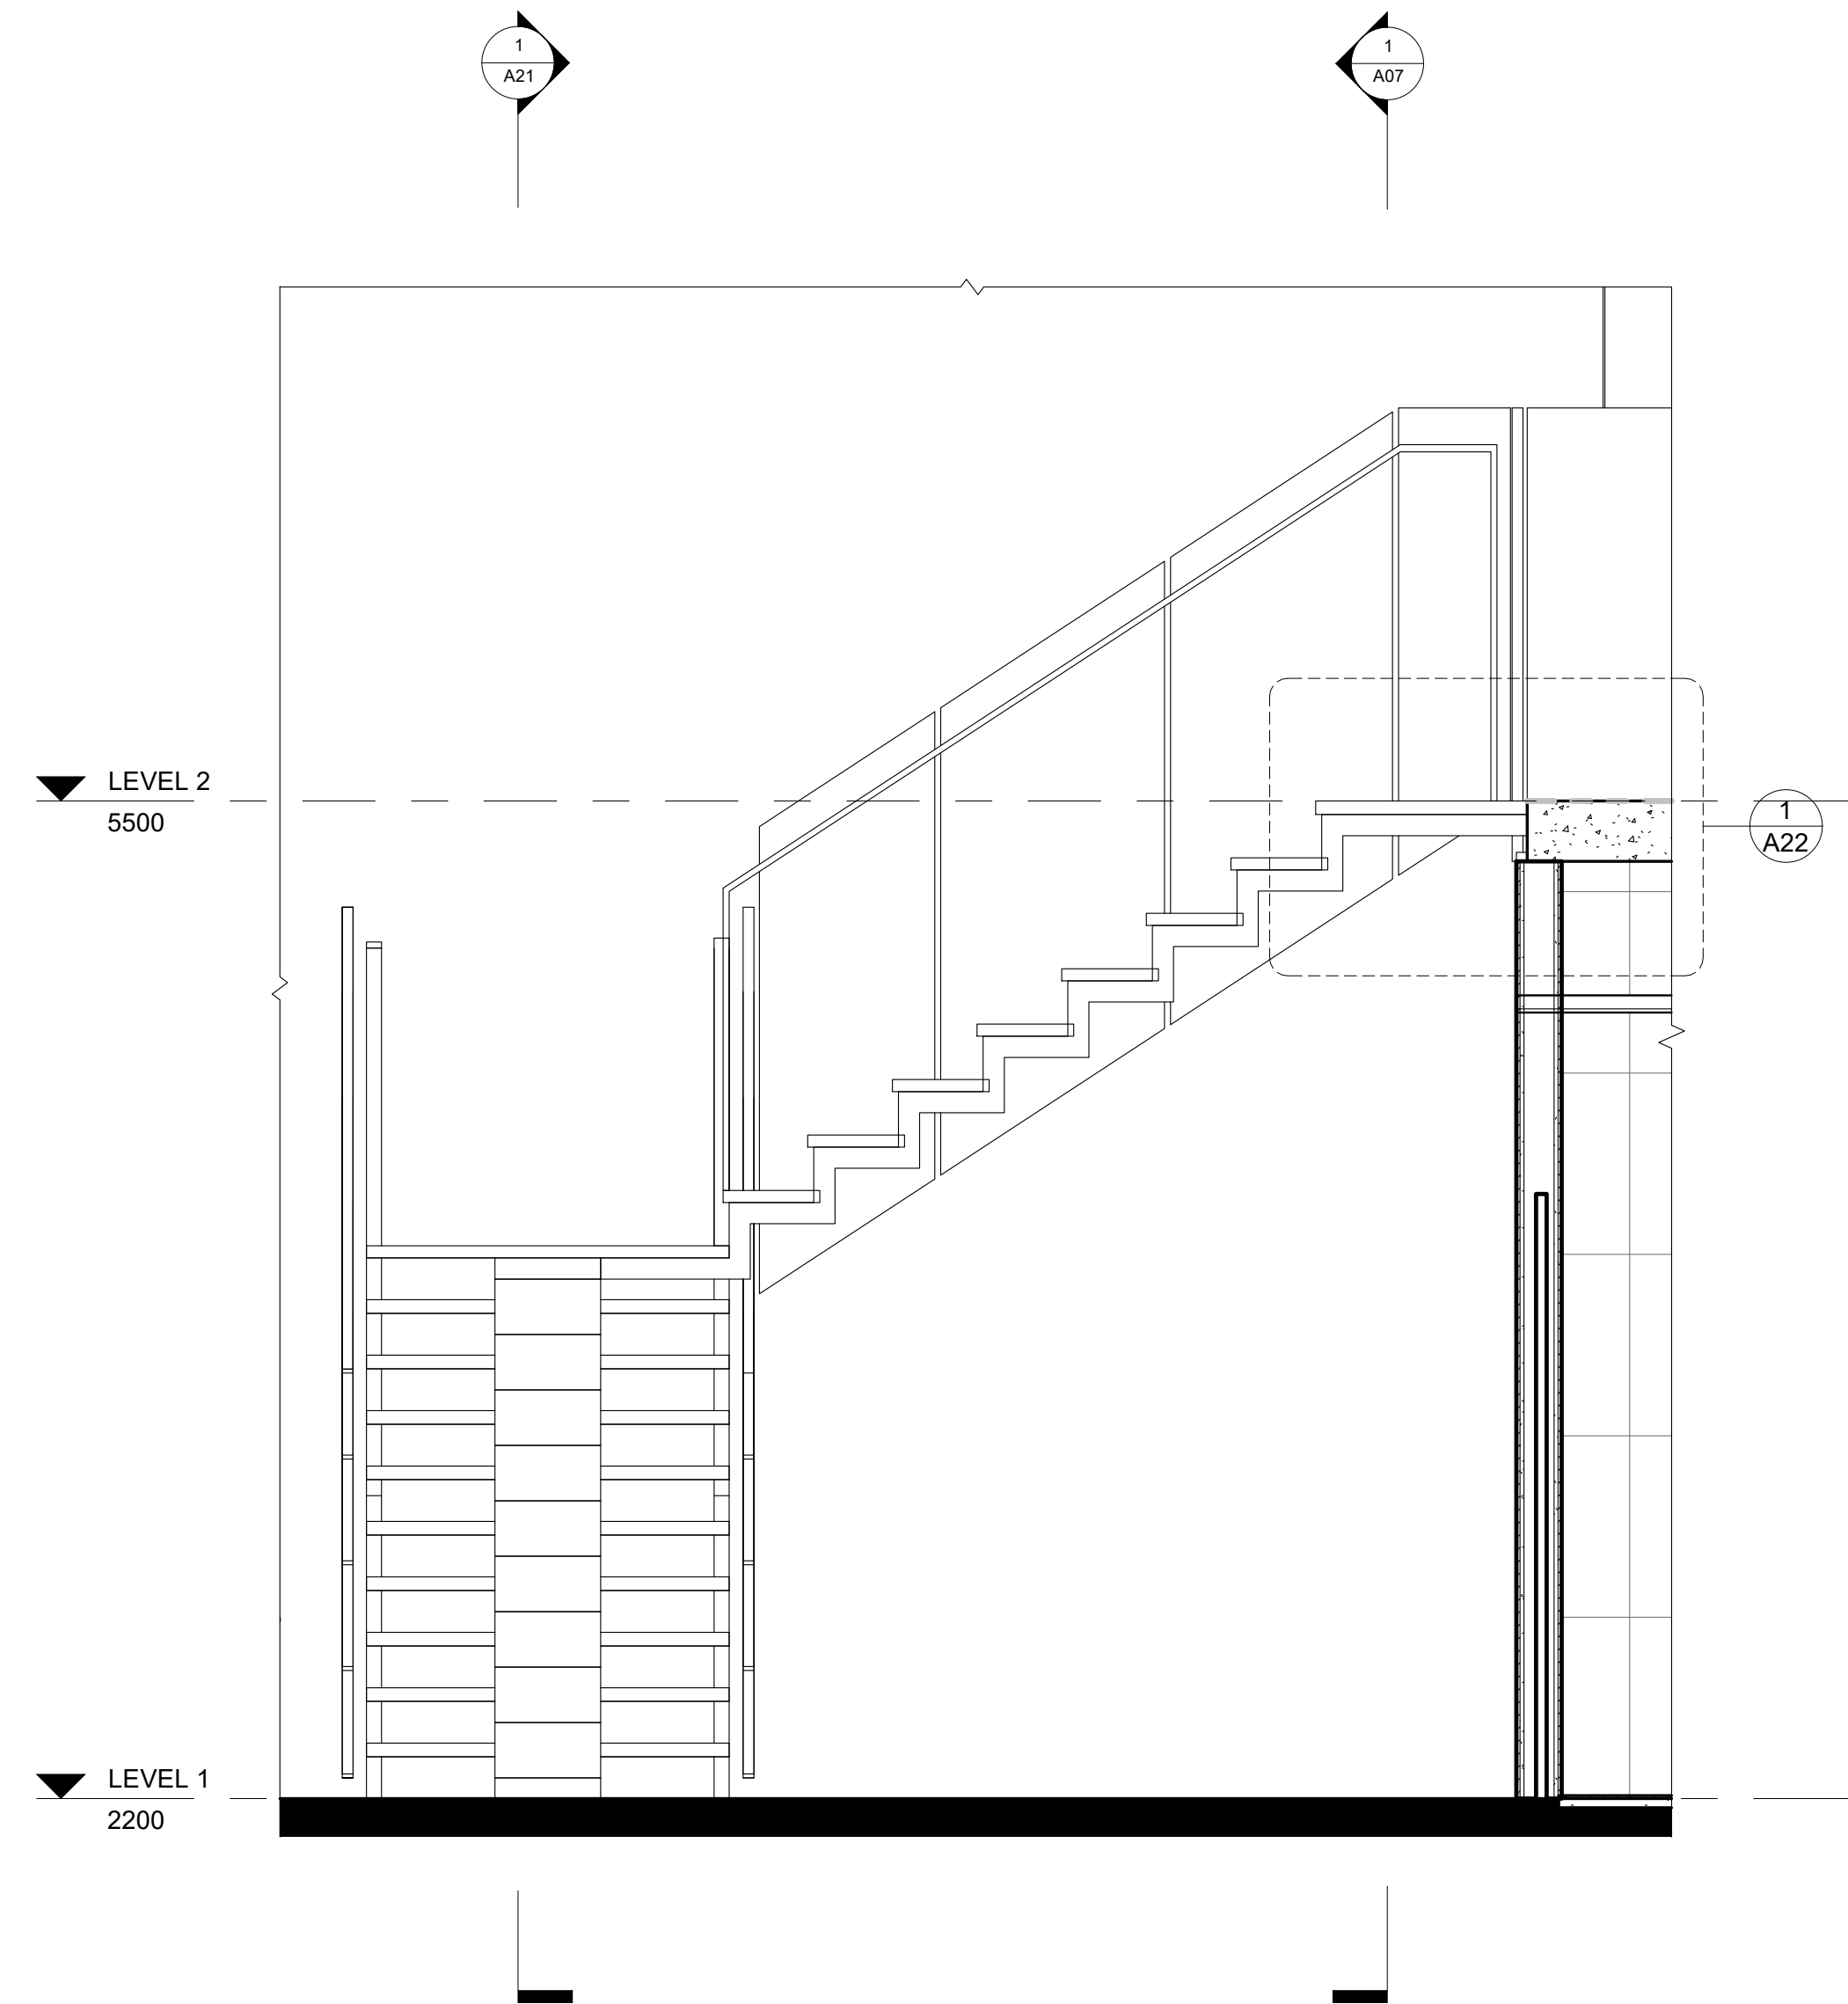

2 STAIR Section 1
1:20

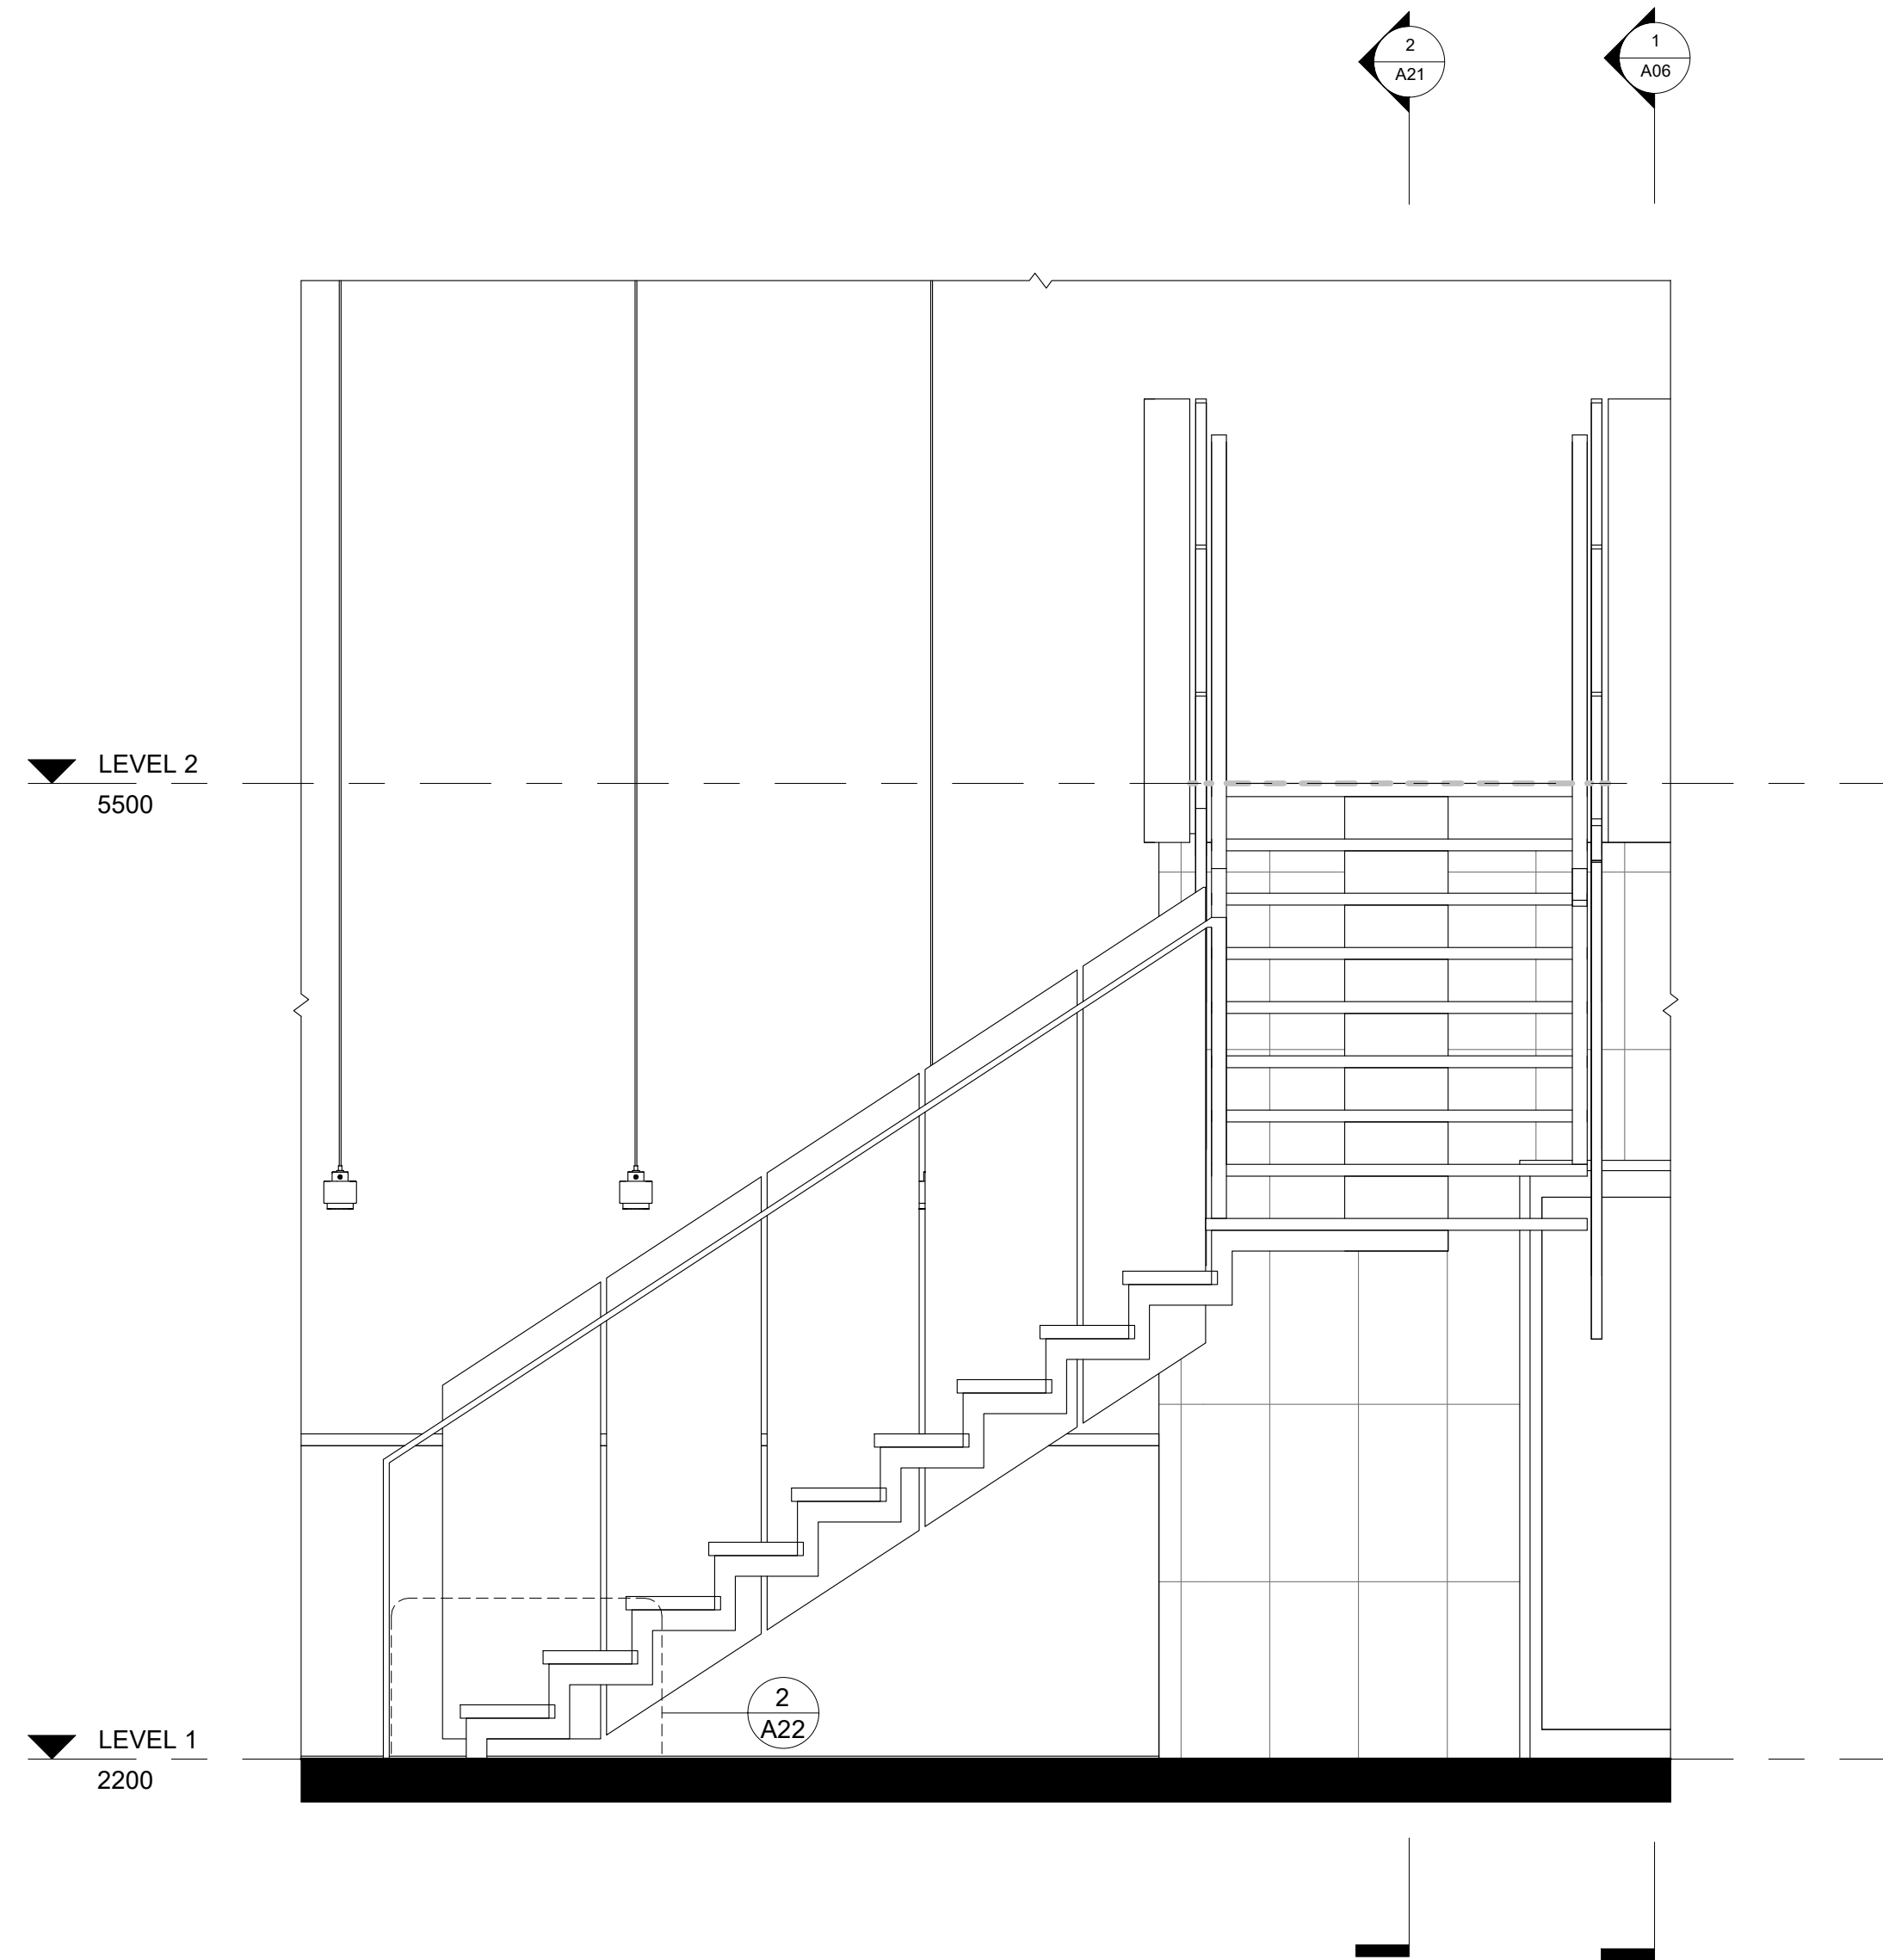

1 STAIR Section 2
1:20

LEGEND

CUT PATTERN LEGEND

EXISTING	INSULATION
CONCRETE	EARTH
MDF	TILE
TIMBER	STEEL
ALUMINUM	

ABBREVIATIONS

FFL	Finished Floor Level	EQ	Specialty Equipment
FCL	Finished Ceiling Level	AP	Electrical Equipment
SE	Services	SA	Plumbing Fixture
MA	Material	LI	Lighting Fixture
FU	Furniture	WC	Water Closet

WALL TYPES

STW1

116mm Dry-Dry Wall
13mm Plaster Board, 90mm Timber Stud Frame
13mm Plaster Board

STW2

116mm Wet-Dry Wall
13mm Plaster Board, 90mm Timber Stud Frame
13mm Plaster Board, 2mm Glue, 10mm Tile

STW3

116mm Wet-Wet Wall
10mm Tile, 2mm Glue, 13mm Plaster Board, 90mm Timber Stud Frame
13mm Plaster Board, 2mm Glue, 10mm Tile

DOOR AND WINDOW TAGS

D1

 
Door Tag

W1


Window Tag

Keynote Legend


NOTES



Revisions			Do not scale drawings. Use figured dimensions only. Check and verify levels and dimensions on site prior to commencement of any work, the preparation of drawings or the fabrication of components. This drawing is copyright and can not be reproduced without written consent.	Client Sue & Andy Baker Le Velo	True North	Billy Blue College of Design 46-52 Mountain Street, Ultimo, NSW 2007, Australia +61 (0)2 9999 9999 BILLY BLUE COLLEGE OF DESIGN TORRENS UNIVERSITY AUSTRALIA LAUREATE INTERNATIONAL UNIVERSITIES	Project IDC302A Assessment Brief 2 46 Baywater Drive, Wentworth Point, NSW, 2127 Project number Year. 2019	Drawing Title STAIR SECTION 1 Drawing Status PRESENTATION DRAWINGS NOT FOR CONSTRUCTION	Scale 1:20 Date 17.05.2019 Drawn by PRM	Drawing No A21 Issue 01
No	Date	Description								
01	17.05.2019	PRESENTATION DRAWINGS								

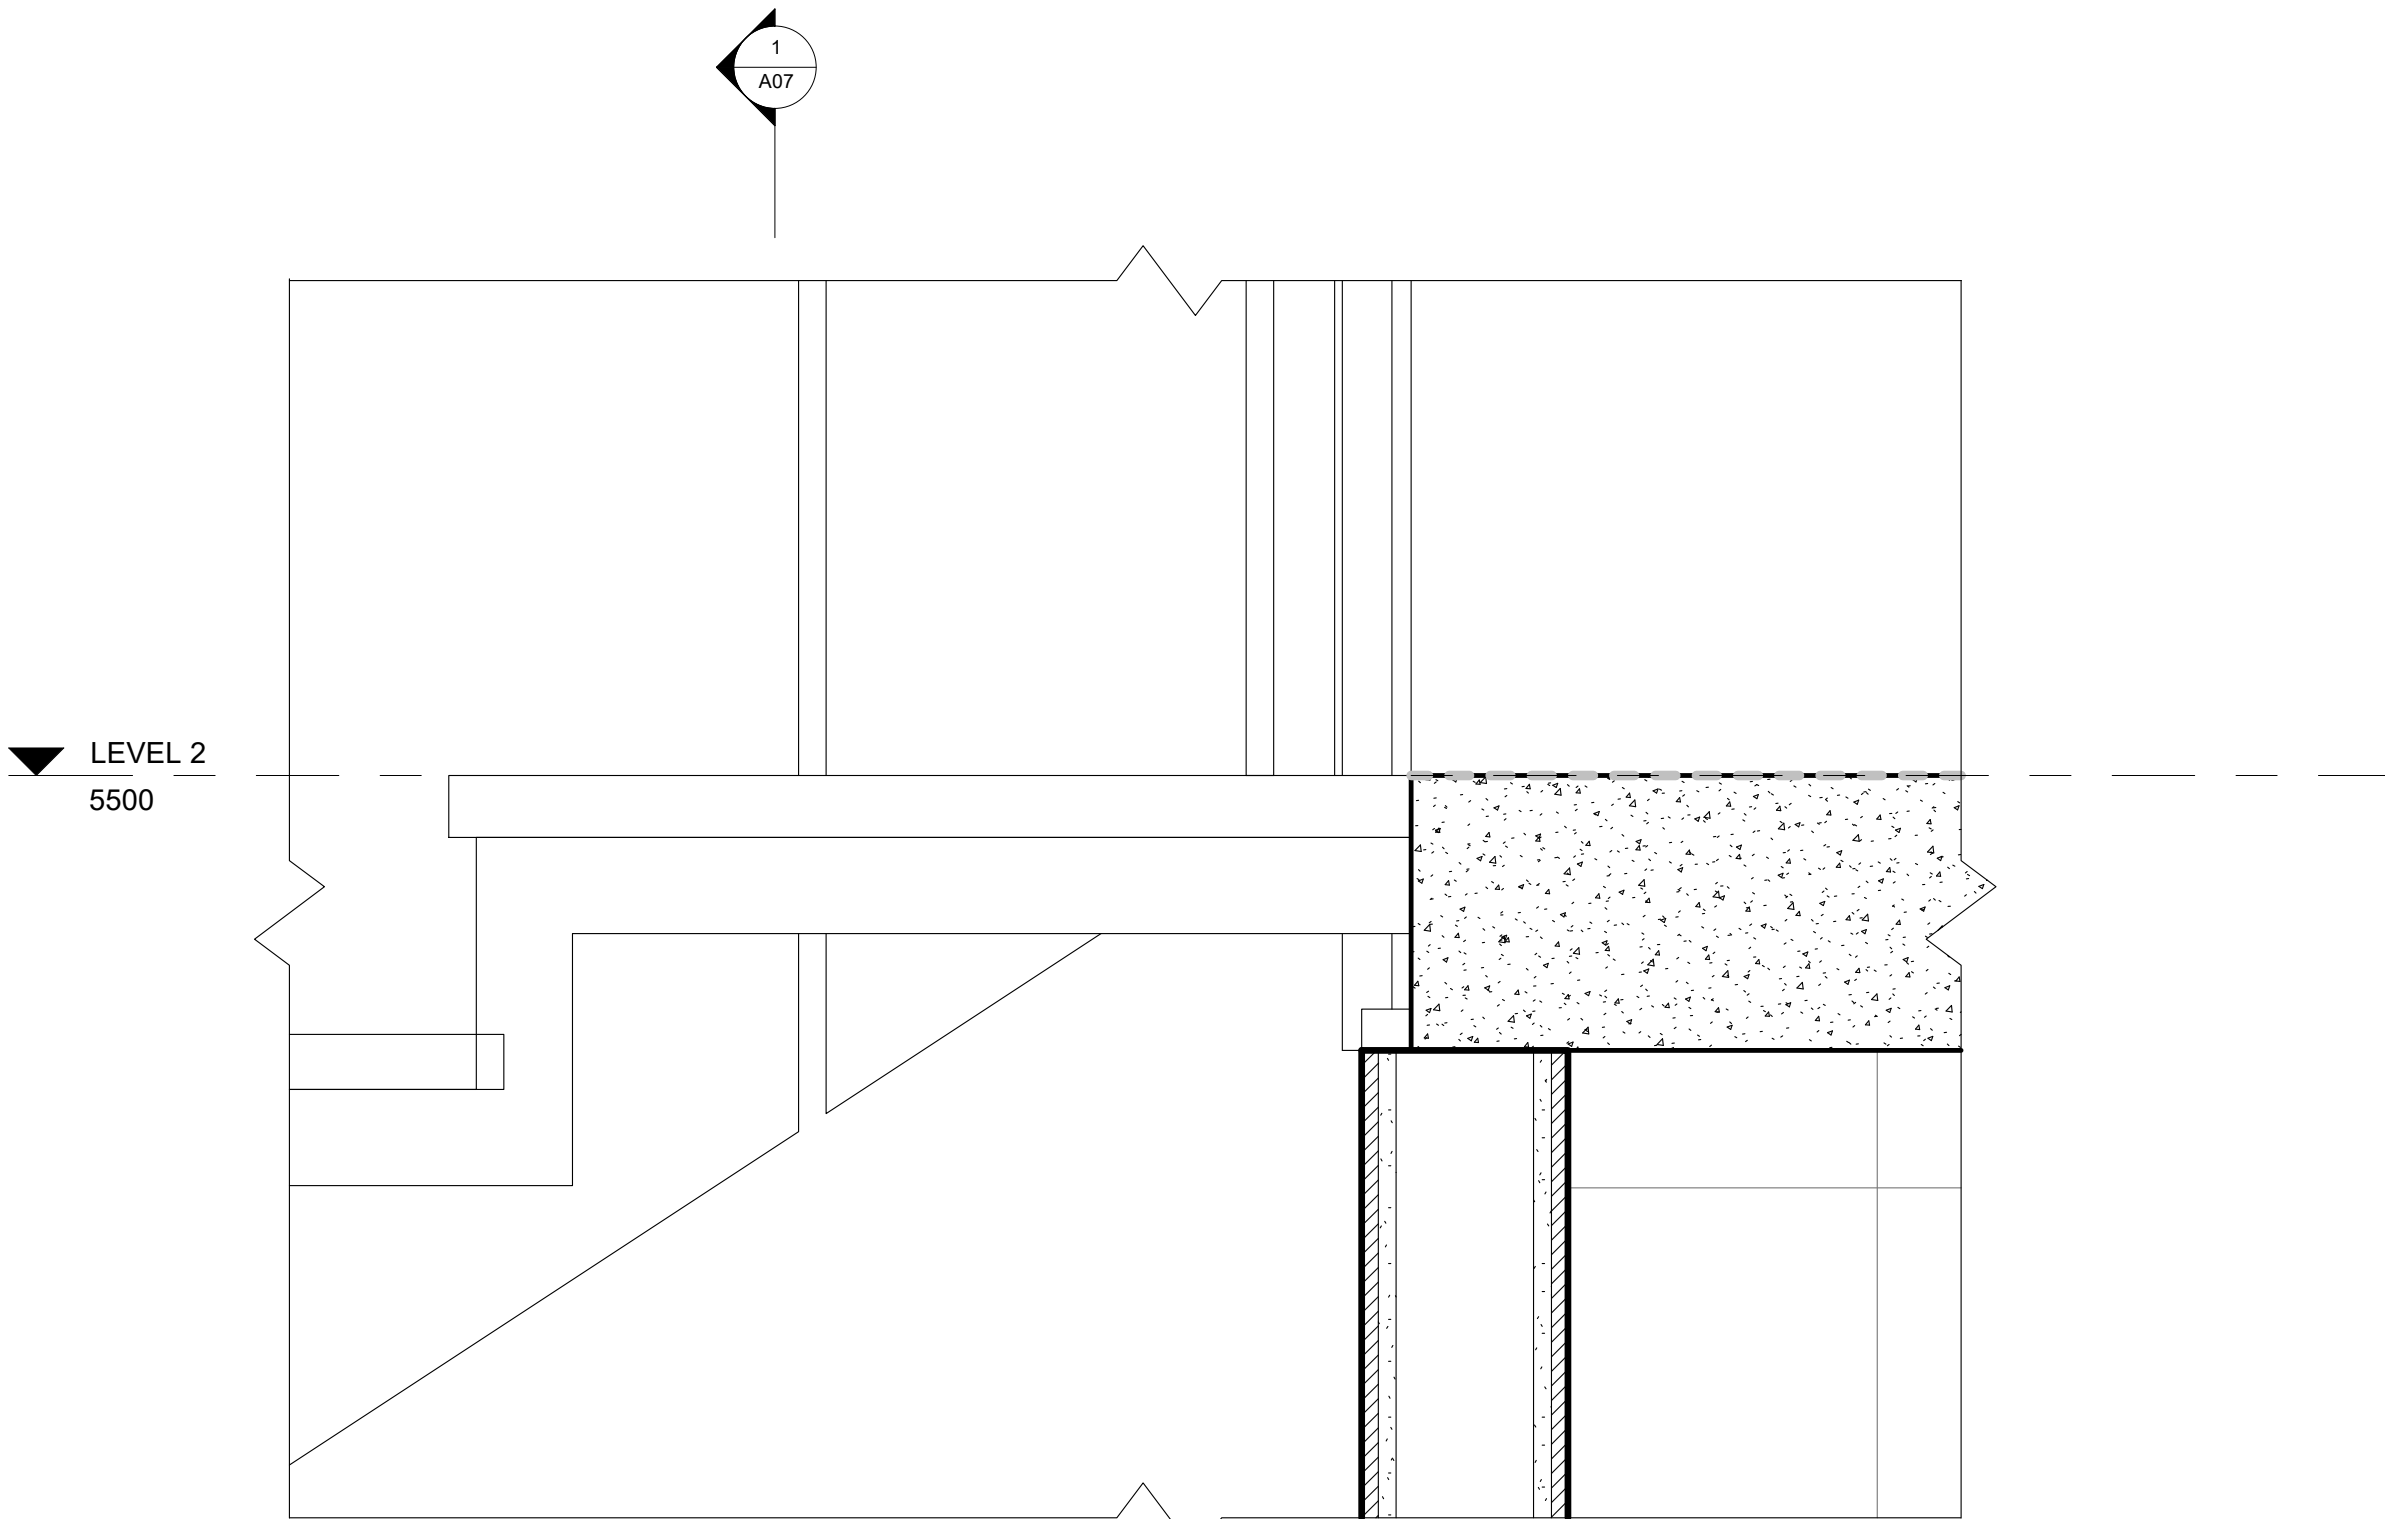

1 STAIR Tread
1:5

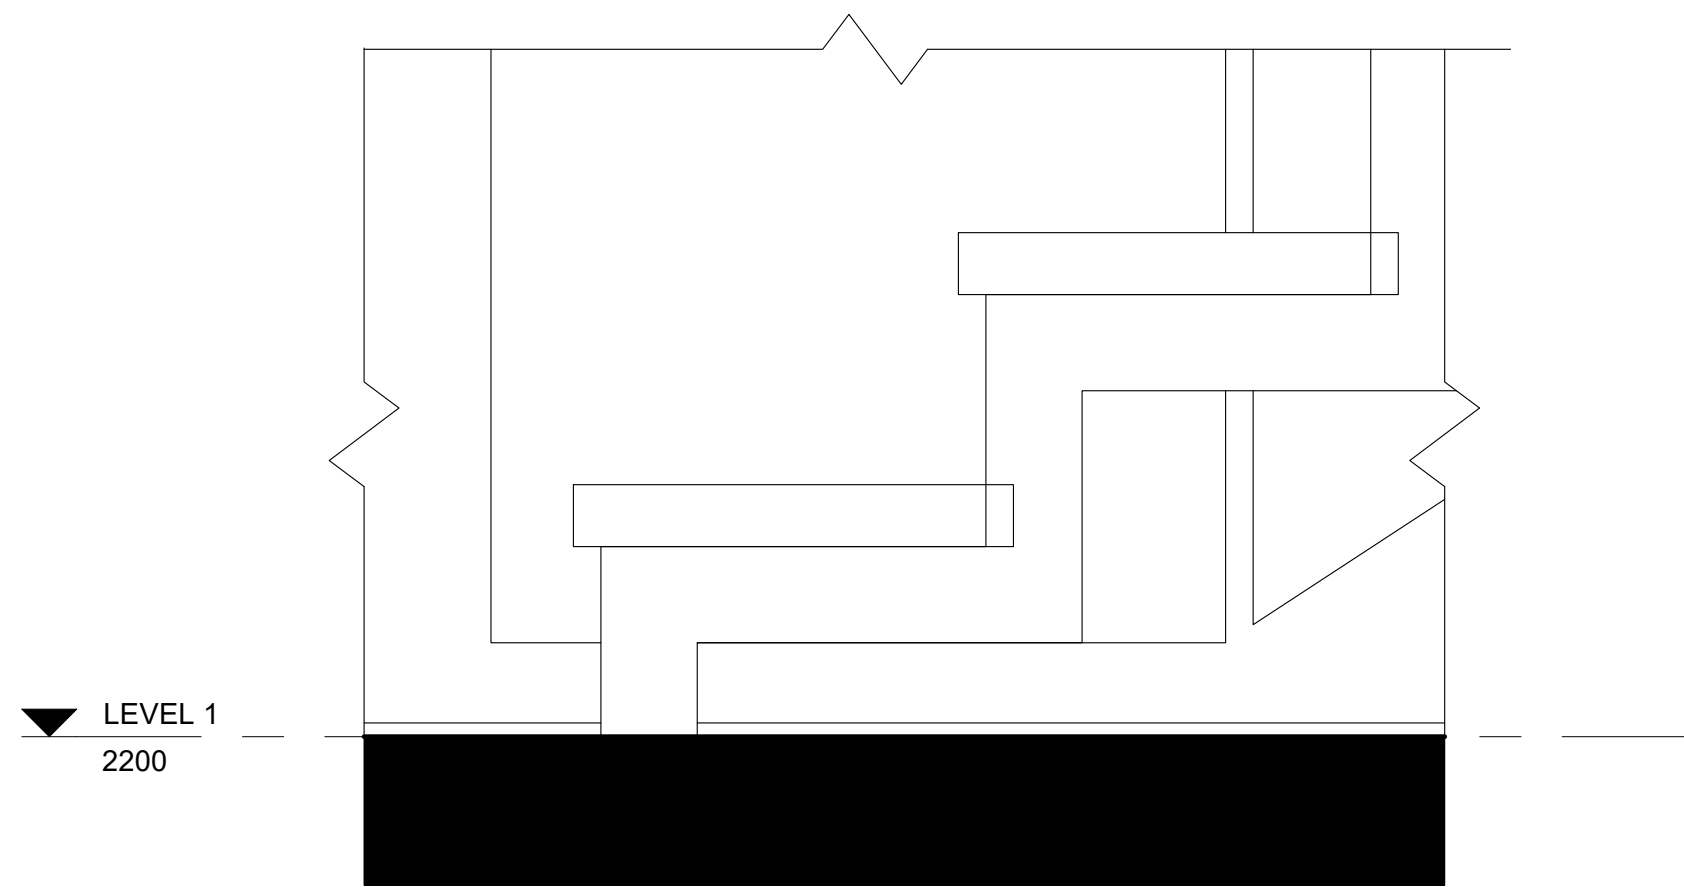

2 STAIR Landing
1:5

LEGEND

CUT PATTERN LEGEND

EXISTING		INSULATION	
CONCRETE		EARTH	
MDF		TILE	
TIMBER		STEEL	
ALUMINUM			

ABBREVIATIONS

FFL	Finished Floor Level	EQ	Specialty Equipment
FCL	Finished Ceiling Level	AP	Electrical Equipment
SE	Services	SA	Plumbing Fixture
MA	Material	LI	Lighting Fixture
FU	Furniture	WC	Water Closet

WALL TYPES

STW1 116mm Dry-Dry Wall
13mm Plaster Board, 90mm Timber Stud Frame 13mm Plaster Board

STW2 116mm Wet-Dry Wall
13mm Plaster Board, 90mm Timber Stud Frame 13mm Plaster Board, 2mm Glue, 10mm Tile

STW3 116mm Wet-Wet Wall
10mm Tile, 2mm Glue, 13mm Plaster Board, 90mm Timber Stud Frame 13mm Plaster Board, 2mm Glue, 10mm Tile

DOOR AND WINDOW TAGS

D1 Door Tag W1 Window Tag

Keynote Legend

NOTES

Revisions

No	Date	Description	Ver.	App'd
01	17.05.2019	PRESENTATION DRAWINGS		Approver

Do not scale drawings. Use figured dimensions only. Check and verify levels and dimensions on site prior to commencement of any work, the preparation of drawings or the fabrication of components. This drawing is copyright and can not be reproduced without written consent.

Client

Sue & Andy Baker

True North

Billy Blue College of Design
46-52 Mountain Street, Ultimo, NSW 2007, Australia
+61 (0)2 9999 9999

Project

IDC302A Assessment Brief 2

46 Baywater Drive, Wentworth Point, NSW, 2127

Project number

Year. 2019

Drawing Title

STAIR DETAIL SECTIONS

Drawing Status

PRESENTATION DRAWINGS
NOT FOR CONSTRUCTION

Scale

1:5

Drawing No

A22

Issue

01


Date

17.05.2019


Drawn by

PRM



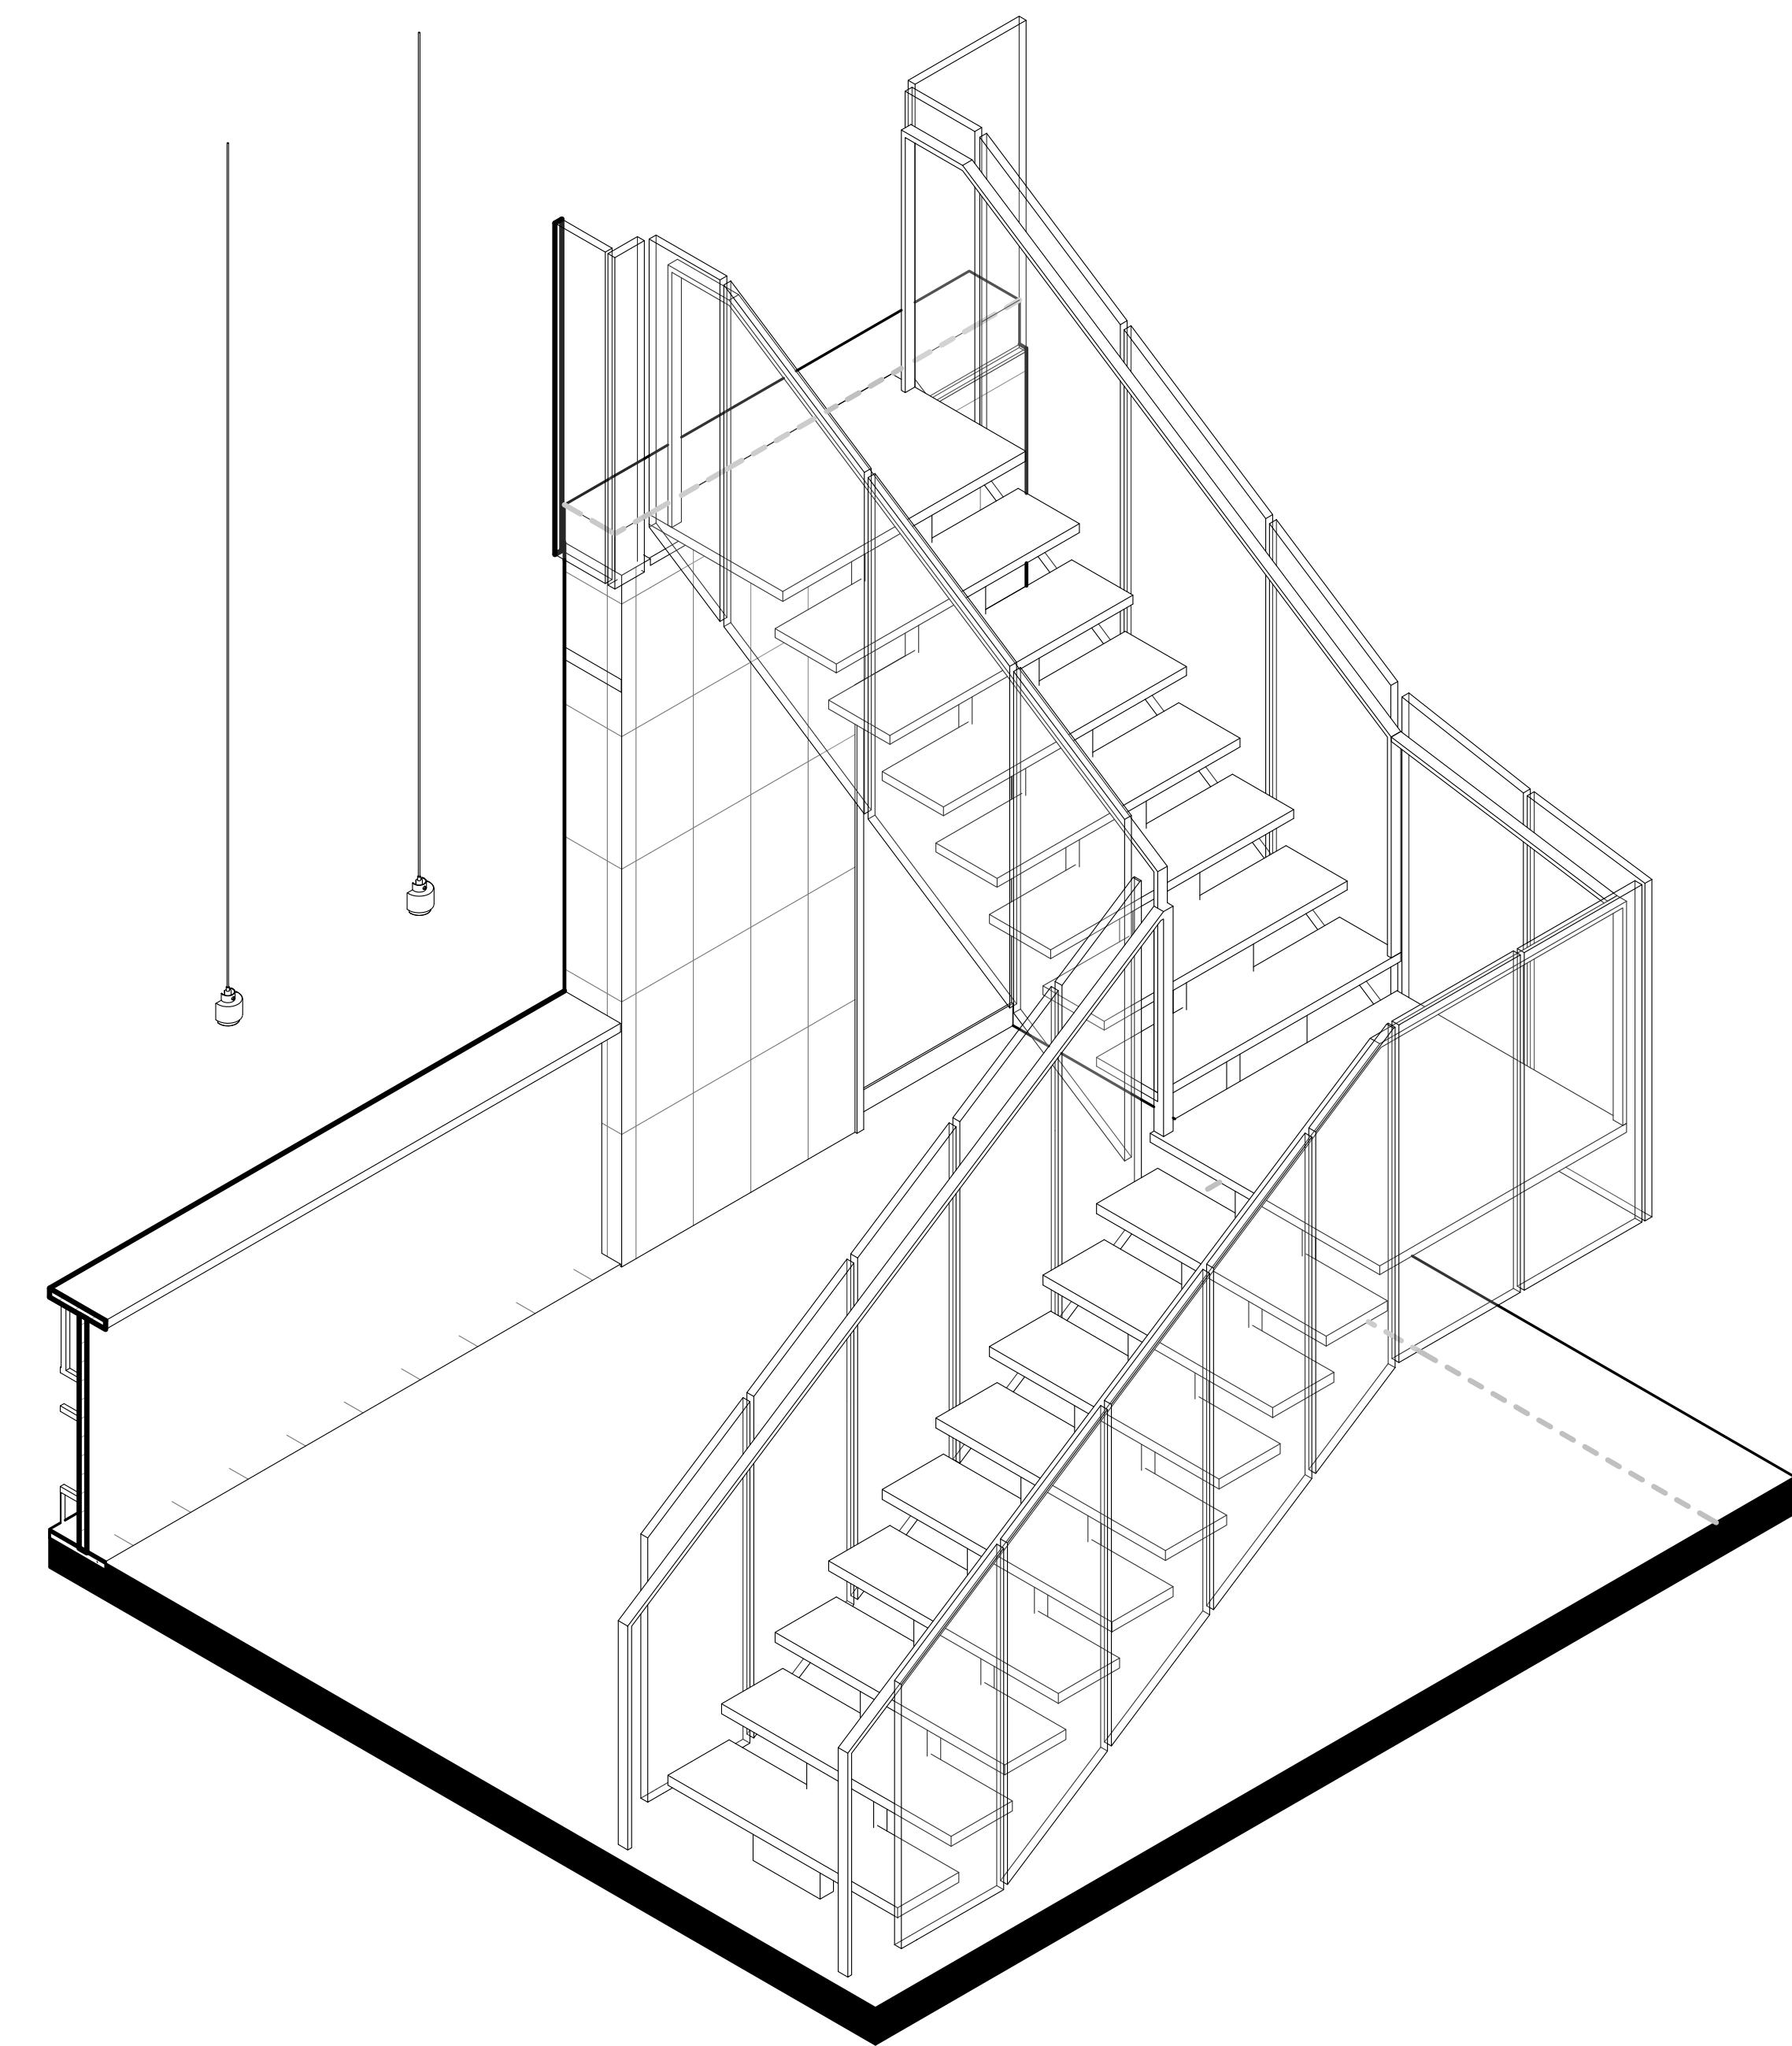

1 STAIR Isometric

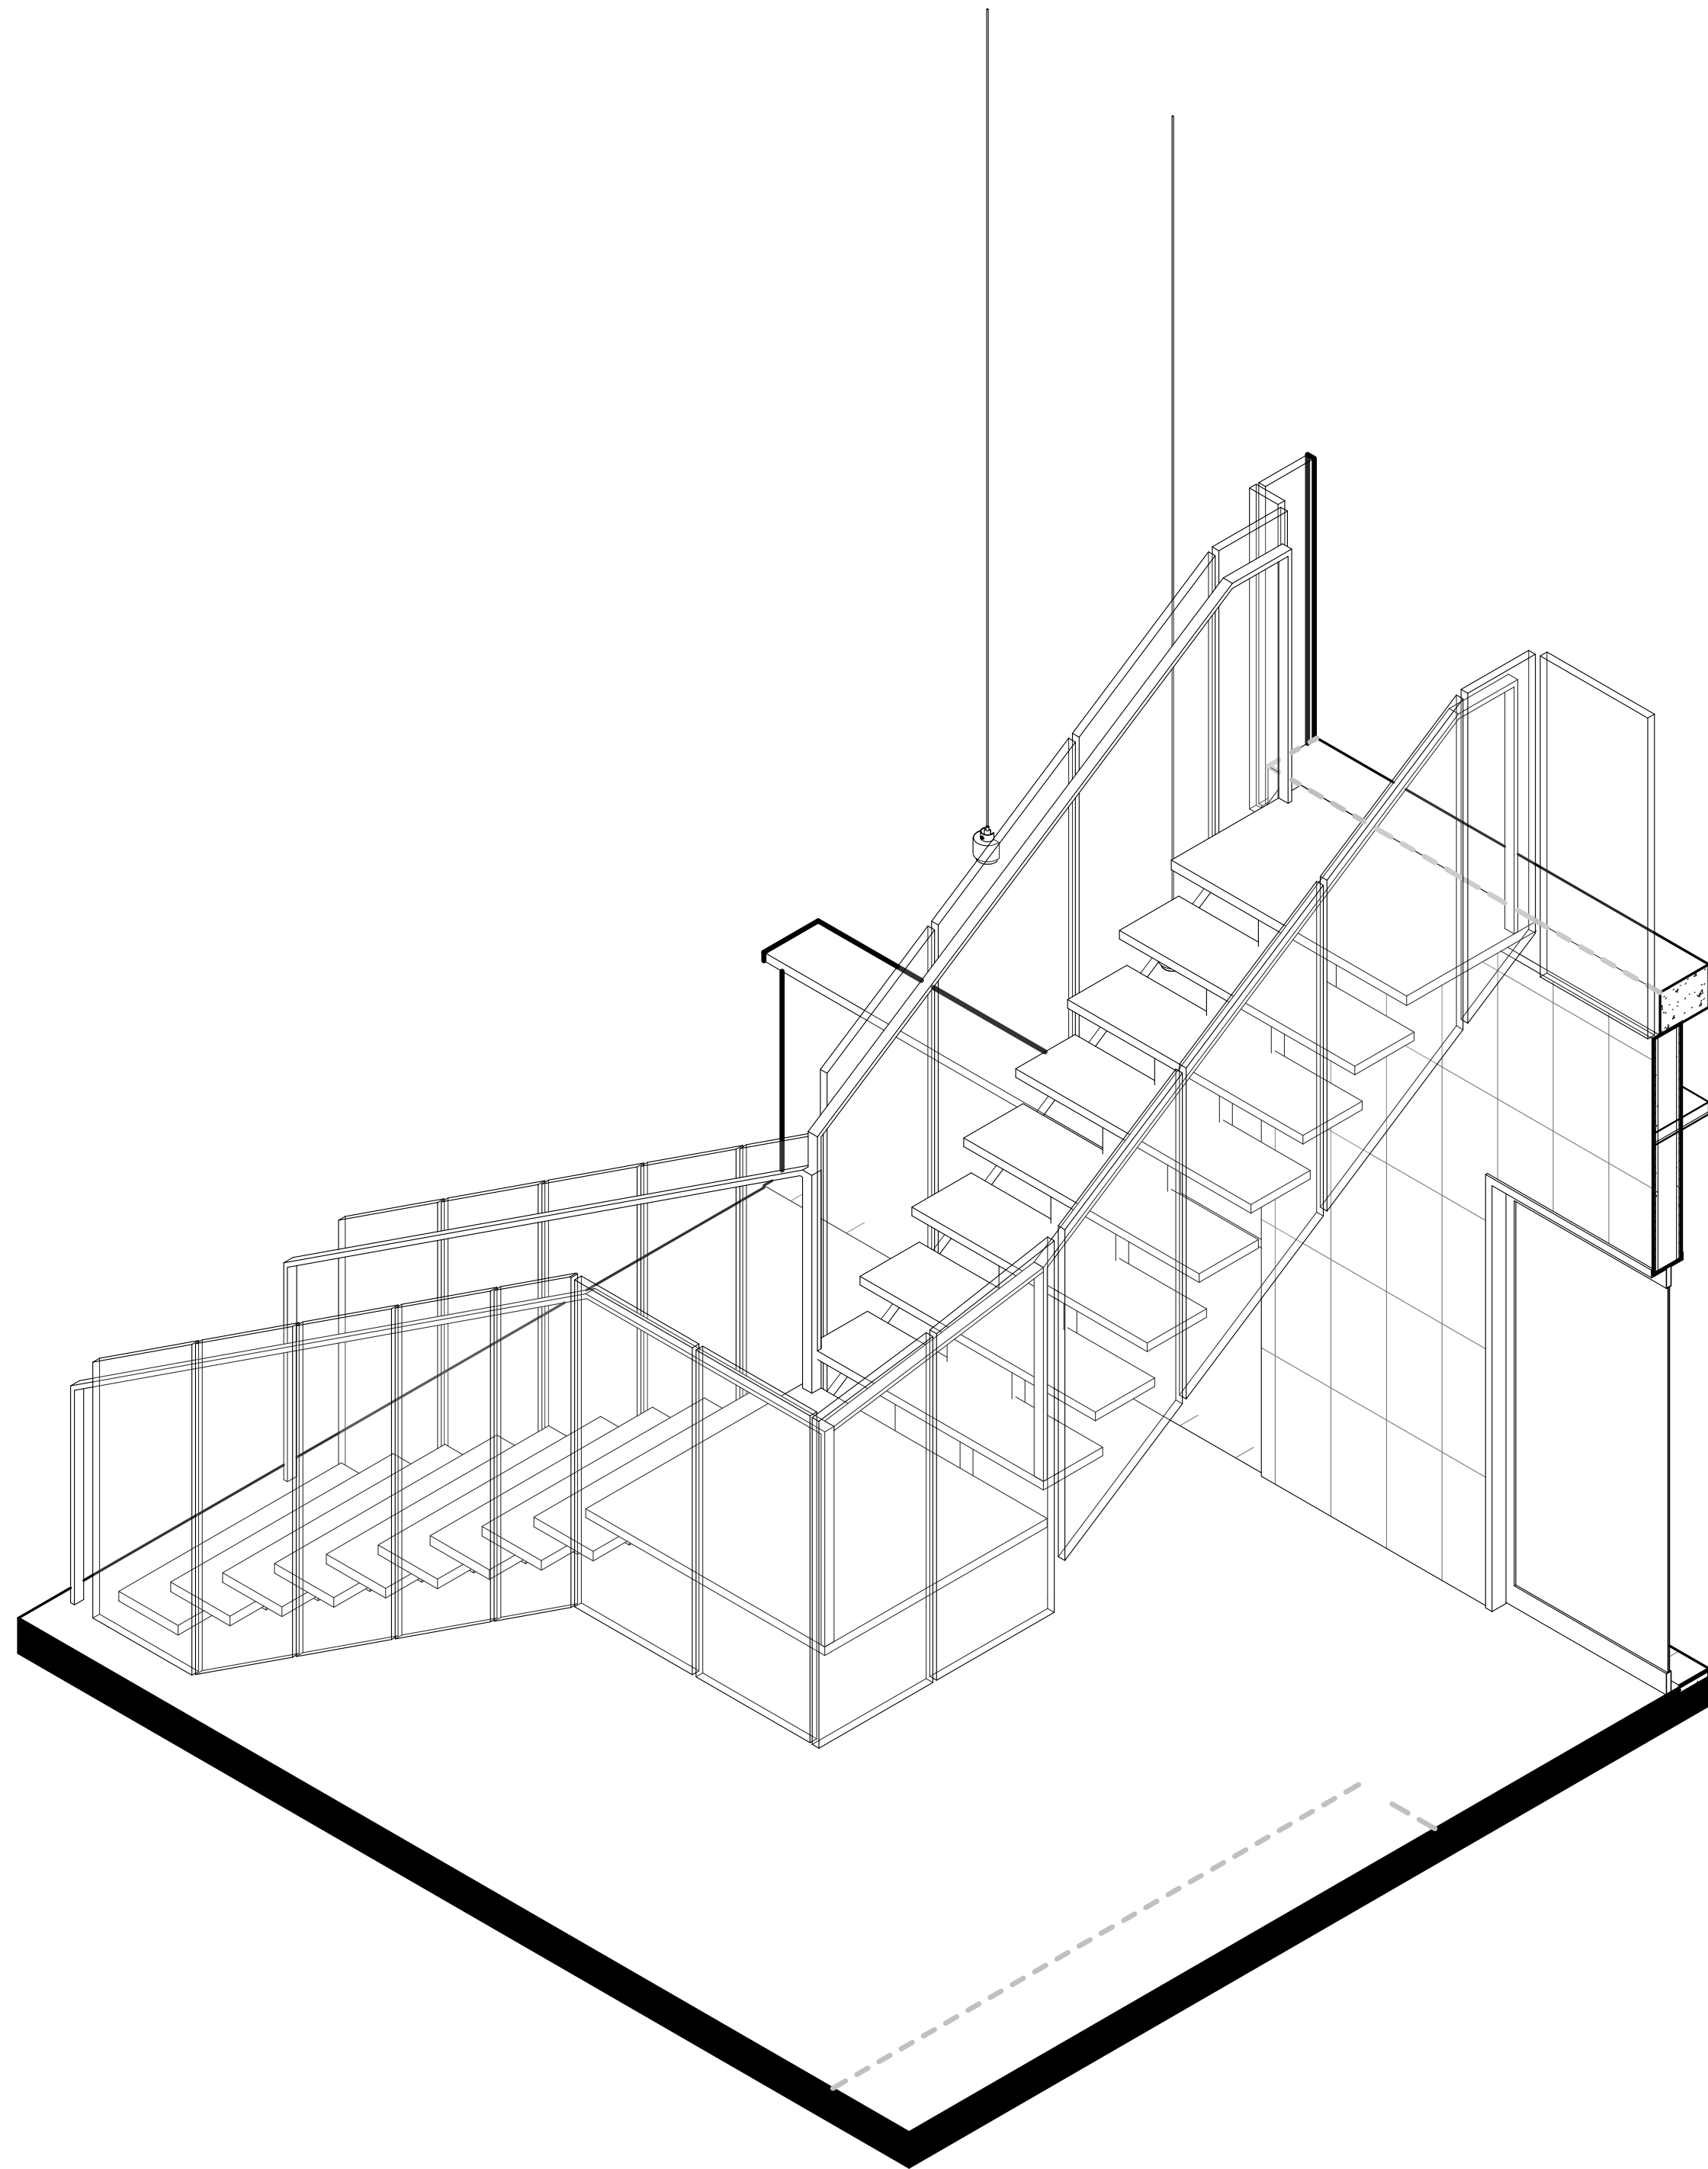

2 STAIR Isometric 2

LEGEND

CUT PATTERN LEGEND

EXISTING		INSULATION	
CONCRETE		EARTH	
MDF		TILE	
TIMBER		STEEL	
ALUMINUM			

ABBREVIATIONS

FFL	Finished Floor Level	EQ	Specialty Equipment
FCL	Finished Ceiling Level	AP	Electrical Equipment
SE	Services	SA	Plumbing Fixture
MA	Material	LI	Lighting Fixture
FU	Furniture	WC	Water Closet

WALL TYPES

STW1	116mm Dry-Dry Wall 13mm Plaster Board, 90mm Timber Stud Frame13mm Plaster Board
STW2	116mm Wet-Dry Wall 13mm Plaster Board, 90mm Timber Stud Frame13mm Plaster Board, 2mm Glue, 10mm Tile
STW3	116mm Wet-Wet Wall 10mm Tile, 2mm Glue, 13mm Plaster Board, 90mm Timber Stud Frame13mm Plaster Board, 2mm Glue, 10mm Tile

DOOR AND WINDOW TAGS

D1	Door Tag	W1	Window Tag
----	----------	----	------------

Keynote Legend

NOTES



Revisions			Do not scale drawings. Use figured dimensions only. Check and verify levels and dimensions on site prior to commencement of any work, the preparation of drawings or the fabrication of components. This drawing is copyright and can not be reproduced without written consent.	Client Sue & Andy Baker 	True North	 BILLY BLUE COLLEGE OF DESIGN   LAUREATE INTERNATIONAL UNIVERSITIES	Project IDC302A Assessment Brief 2 46 Baywater Drive, Wentworth Point, NSW, 2127 Project number Year. 2019	Drawing Title STAIR ISOMETRIC VIEWS Drawing Status PRESENTATION DRAWINGS NOT FOR CONSTRUCTION	Scale	Drawing No	Issue	
No	Date	Description							Ver. App'd	1:20	A23	01
01	17.05.2019	PRESENTATION DRAWINGS							Approver			

Date

17.05.2019

Drawn by

PRM

10/05/2019 8:08:25 AM

10/05/2019 8:08:25 AM
A1